

MUNICIPALITY OF METROPOLITAN SEATTLE - KING COUNTY, WASHINGTON
METRO TRANSIT PROJECT CONTRACT NUMBER T6A-76
FOR
AUBURN PARK - AND - RIDE FACILITY
VICTOR O. GRAY & COMPANY CONSULTING ENGINEERS & PLANNERS
RICHARD HAAG & ASSOCIATES CONSULTING LANDSCAPE ARCHITECTS
JD-21 LIGHTING ENGINEERS CONSULTING ELECTRICAL ENGINEERS

INDEX TO DRAWINGS

CIVIL

C-1 EXISTING SITE DATA
C-2 SITE LAYOUT
C-3 GRADING PLAN
C-4 UTILITIES PLAN
C-5 SIGNING & STRIPING PLAN
C-6 BUS & HANDICAPPED ISLAND DETAILS
C-7 SITE PROFILES
C-8 DETENTION POND DETAILS
C-9 TYPICAL DETAILS
C-10 TYPICAL SECTIONS

LANDSCAPE & IRRIGATION

L-1 LANDSCAPE PLAN
L-2 LANDSCAPE DETAILS
L-3 IRRIGATION PLAN
LIGHTING & ELECTRICAL
E-1 LIGHTING & ELECTRICAL PLAN
E-2 ELECTRICAL DETAILS


PASSENGER SHELTER & DRIVERS TOILET

A-1 PASSENGER SHELTER SITE PLAN
A-2 GENERAL STRUCTURAL NOTES


A-3 CONCRETE FOOTINGS
A-4 FRAME PLAN & ELEVATIONS
A-5 FRAME DETAILS
A-6 DRIVERS TOILET-PLANS & ELEVATIONS
A-7 DRIVERS TOILET-WALL DETAILS
A-8 PANEL SERIES P20
A-9 PANEL SERIES P30
A-10 ROOF SERIES R30
A-11 ELECTRICAL DETAILS
A-12 BENCH SERIES S10

"AS CONSTRUCTED"
FEB 10 1978

87M-671 1 OF 17

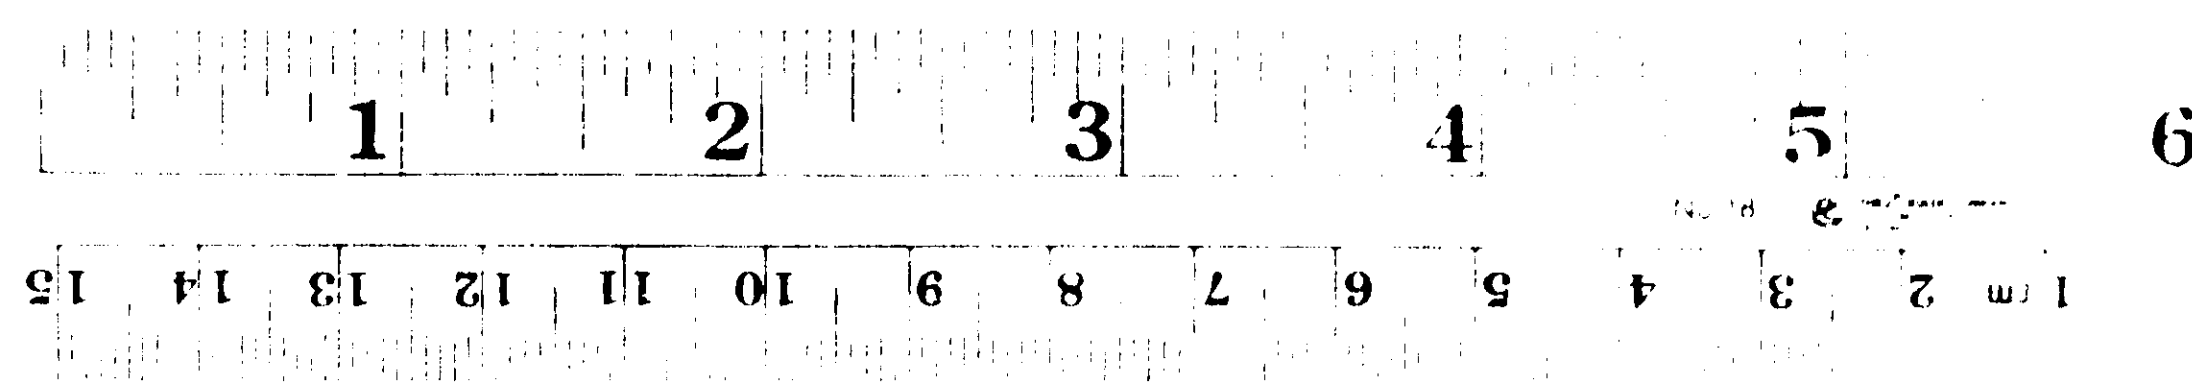


16 X

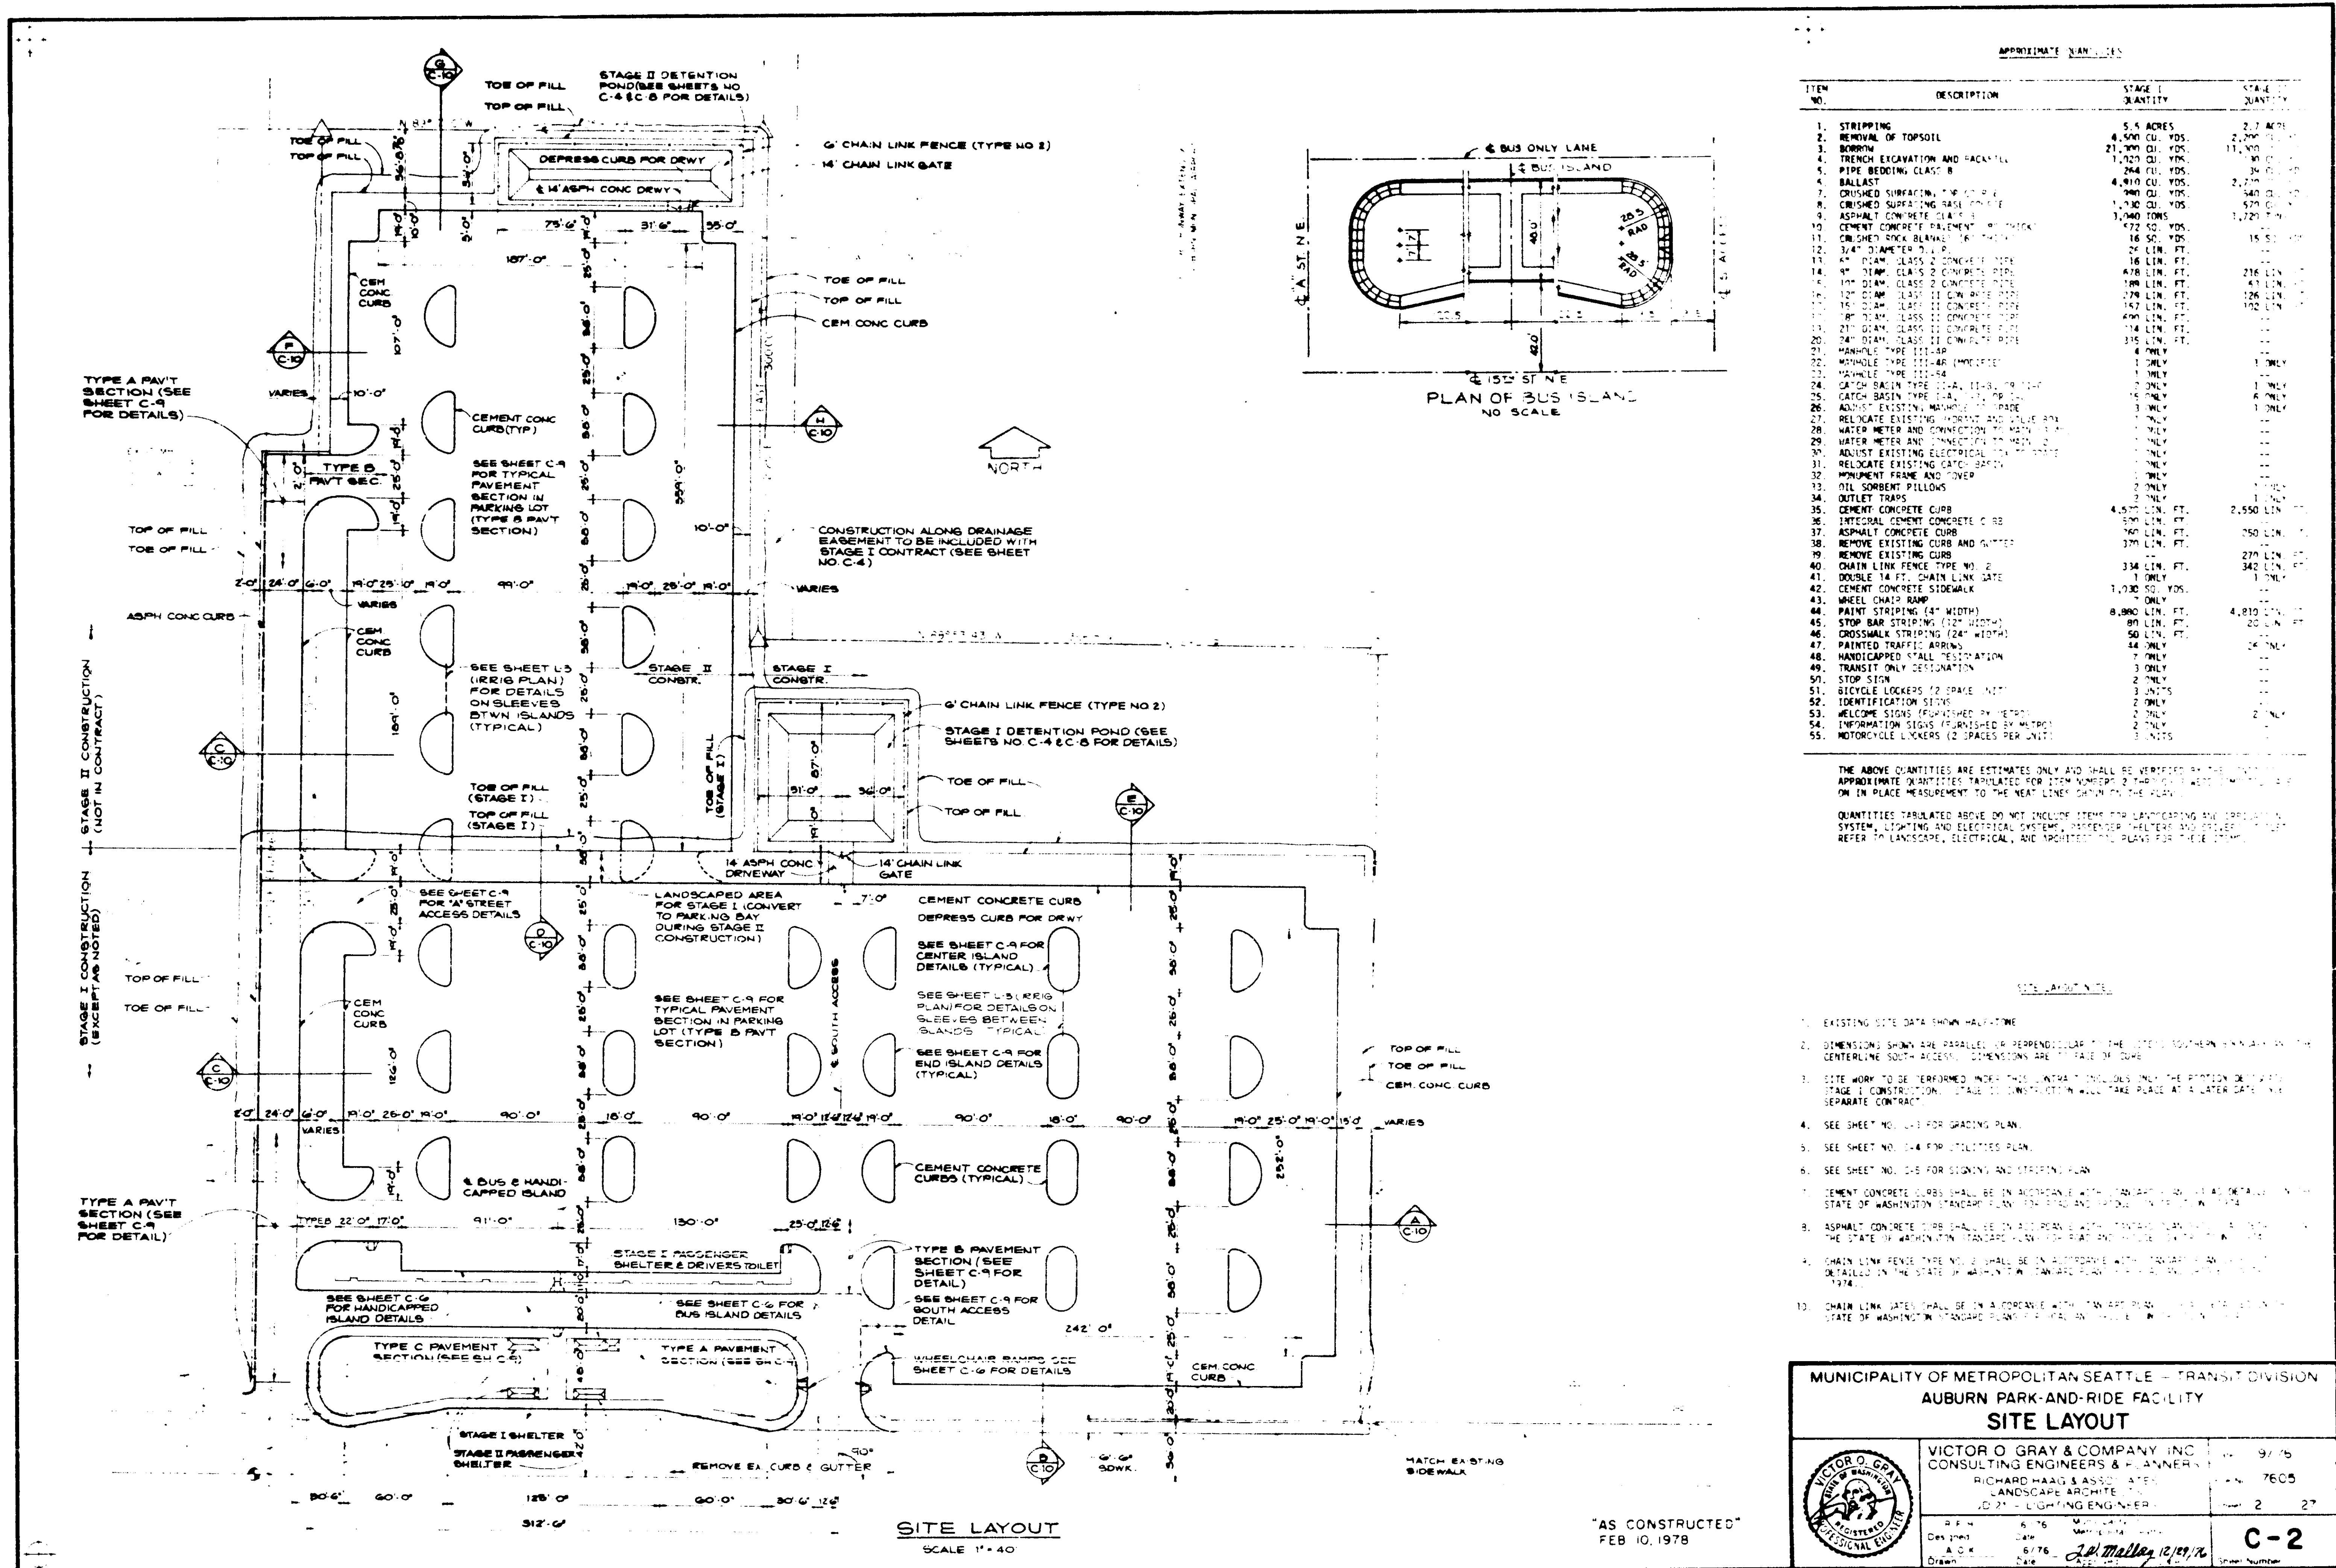


1 2 3 4 5 6
15 14 13 12 11 10 9 8 7 6 5 4 3 2 1

16 X

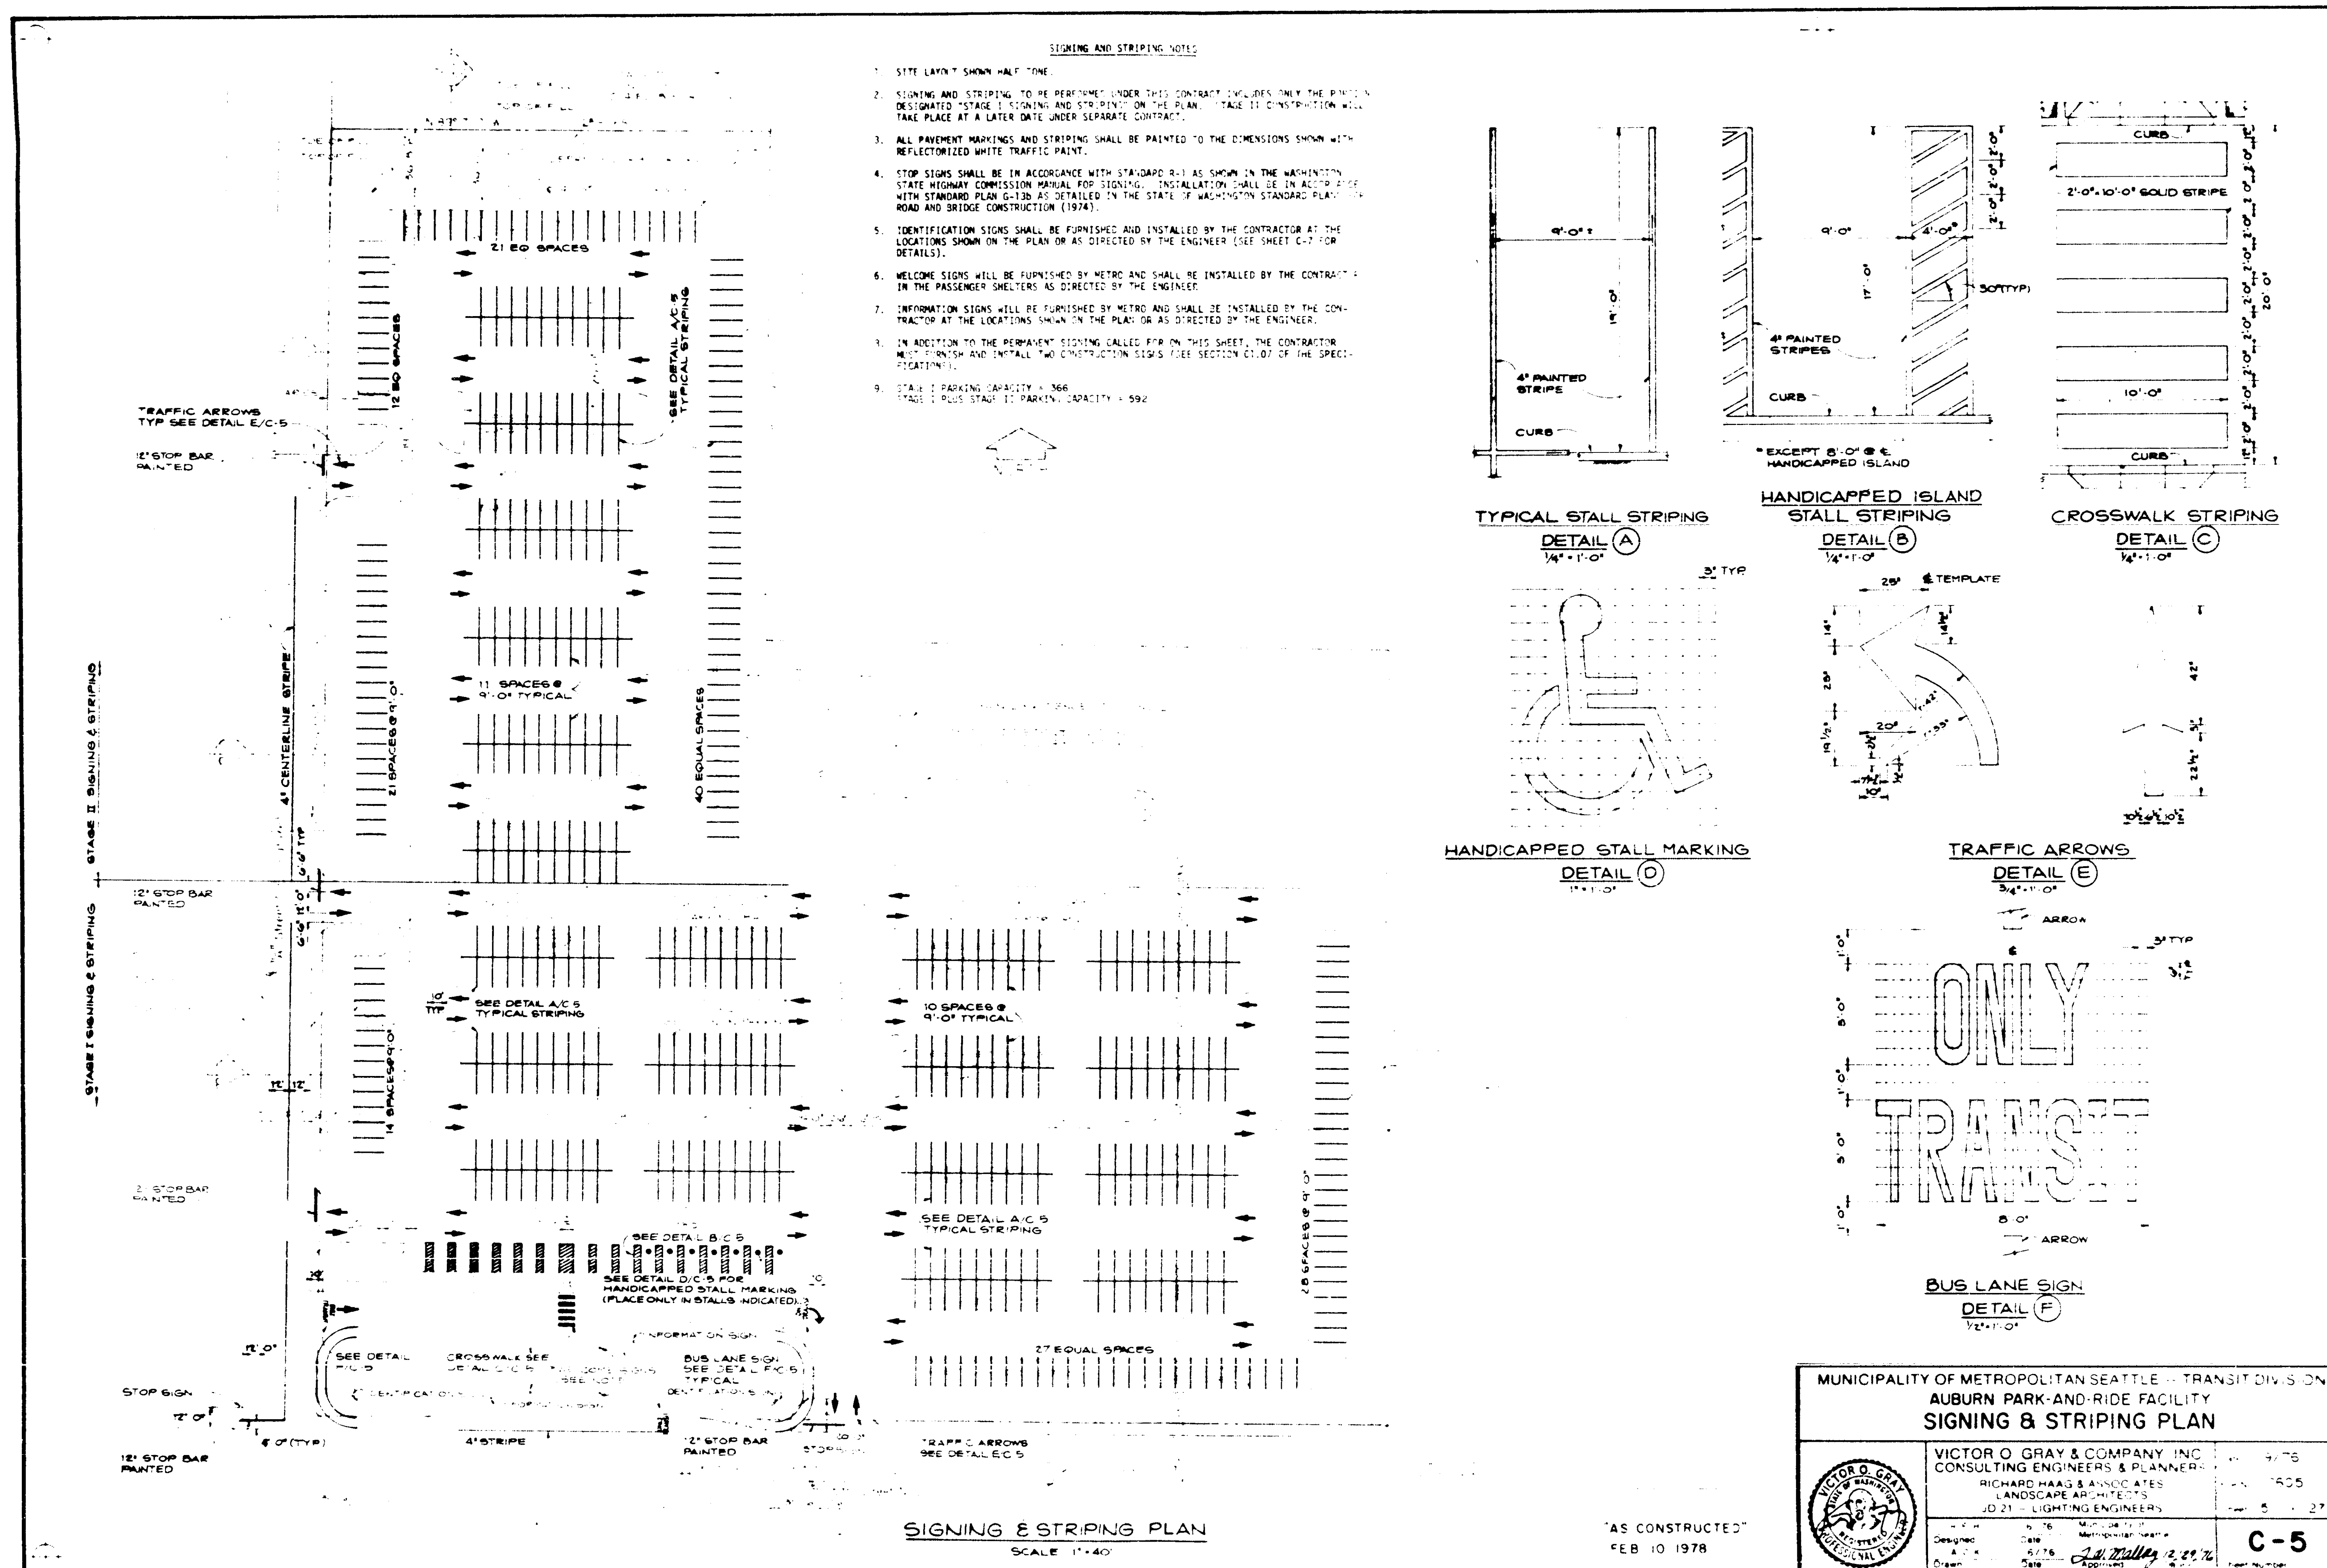


1 2 3 4 5 6
91 F1 E1 D1 C1 B1 A1 6 8 2 9 2 1 8 7 1



16 X

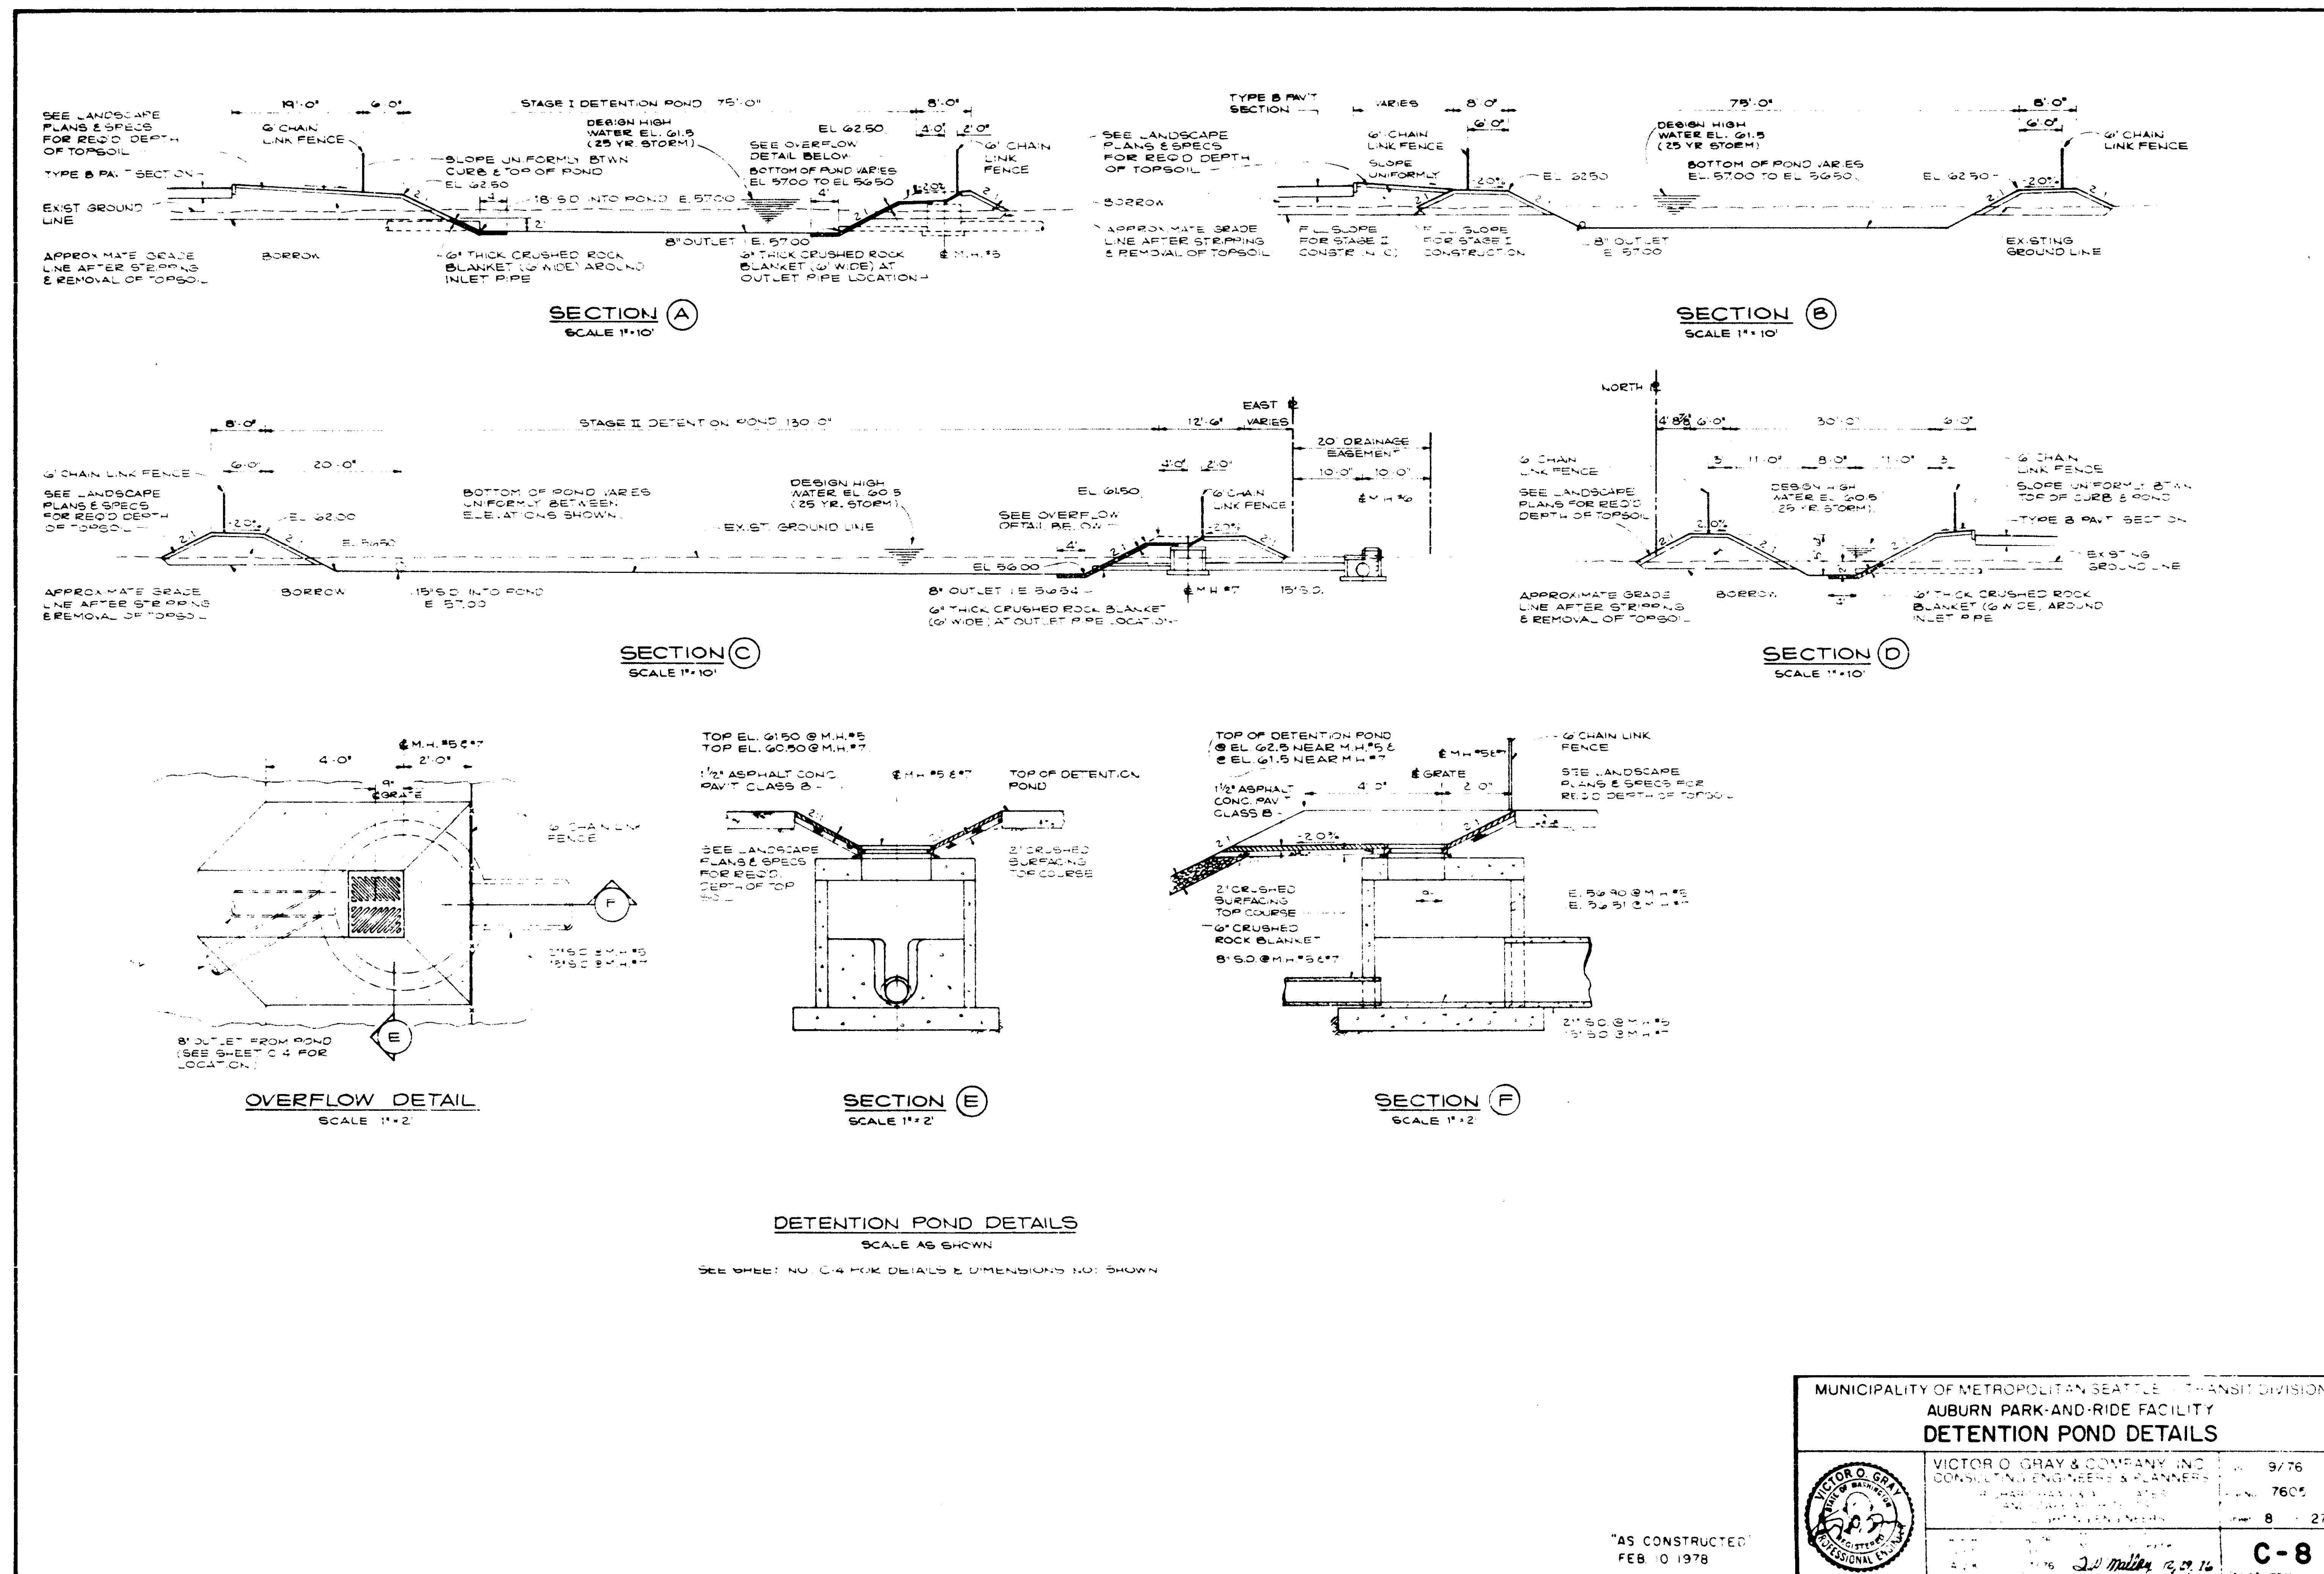


87M-671 9 OF 17

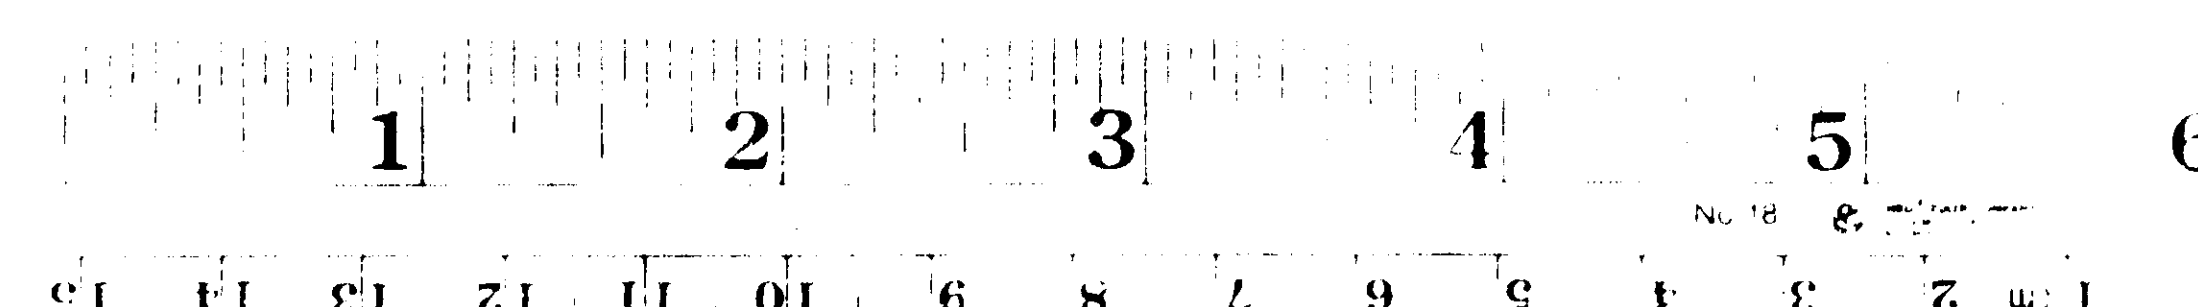

16 X

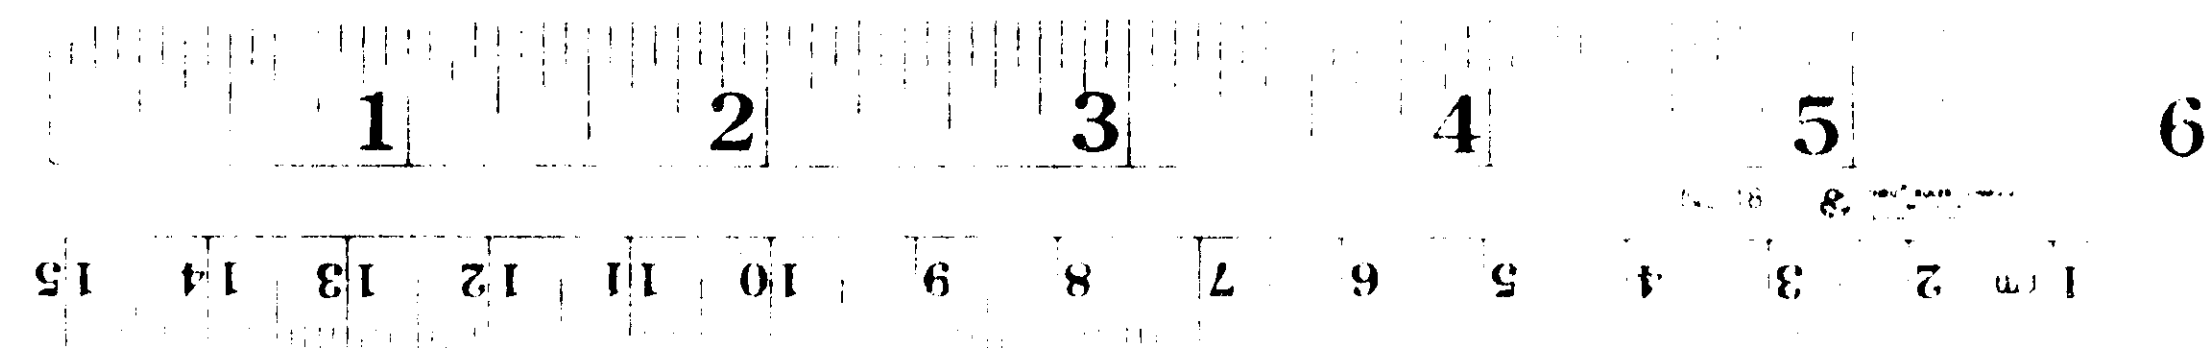
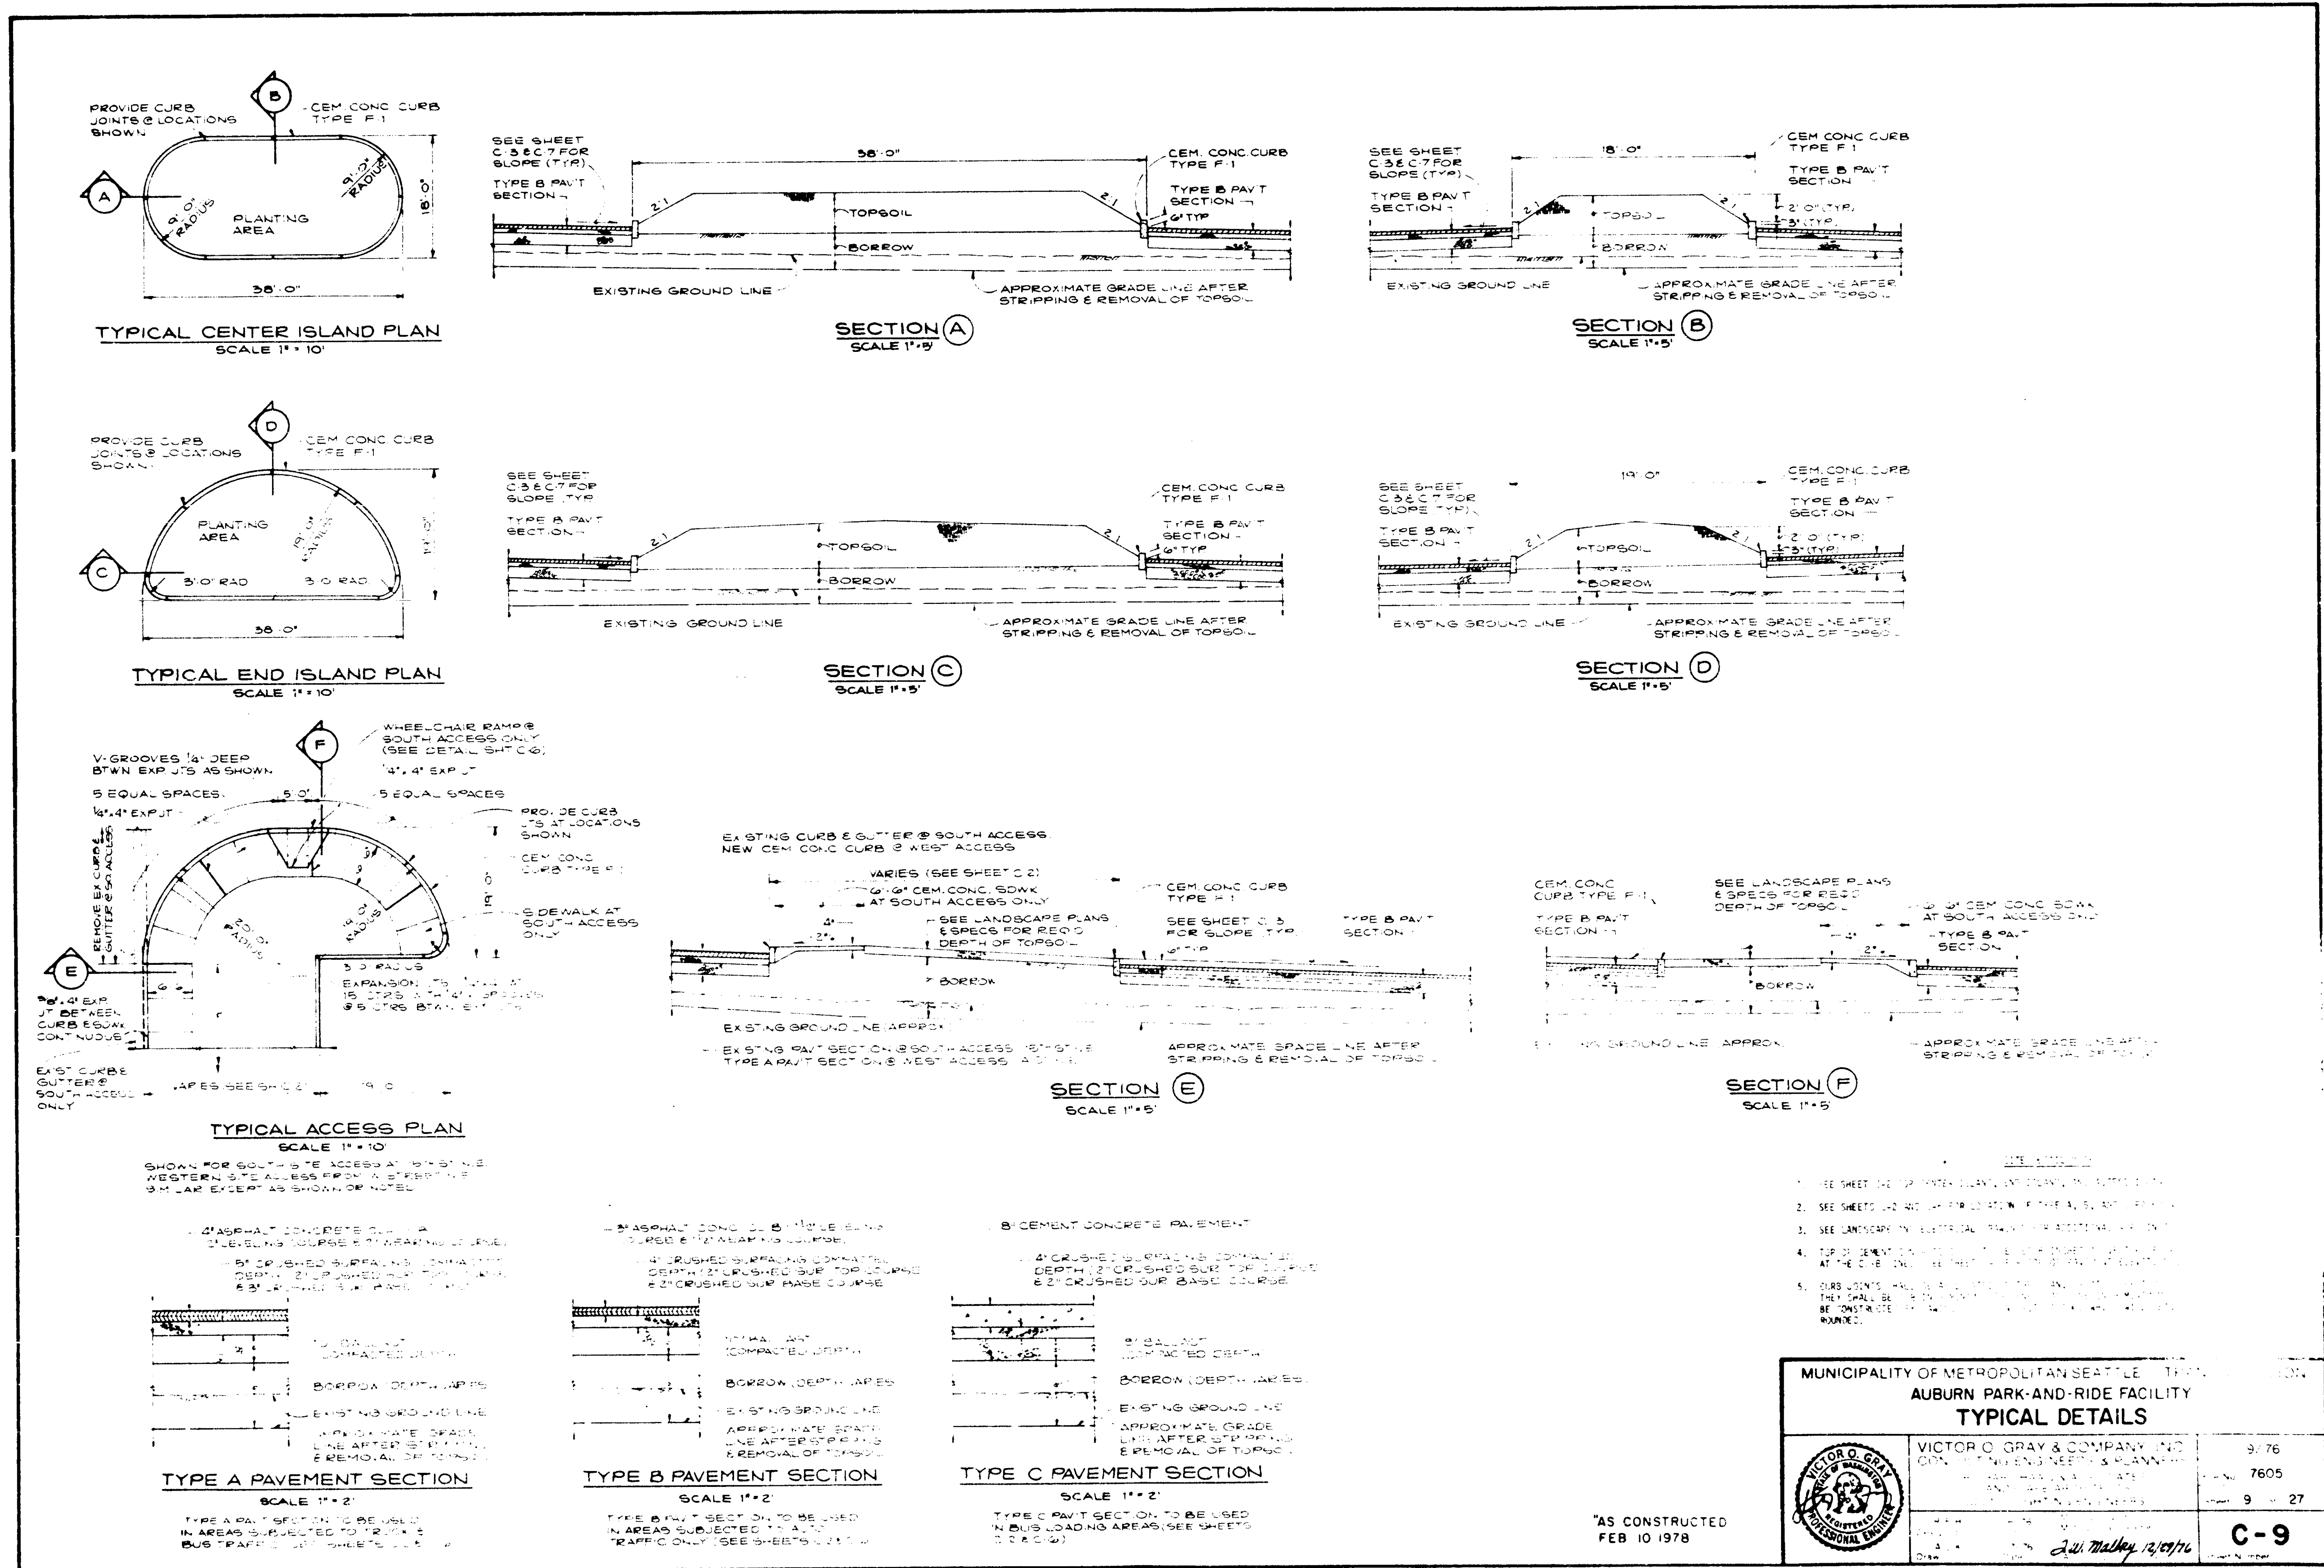


16 X

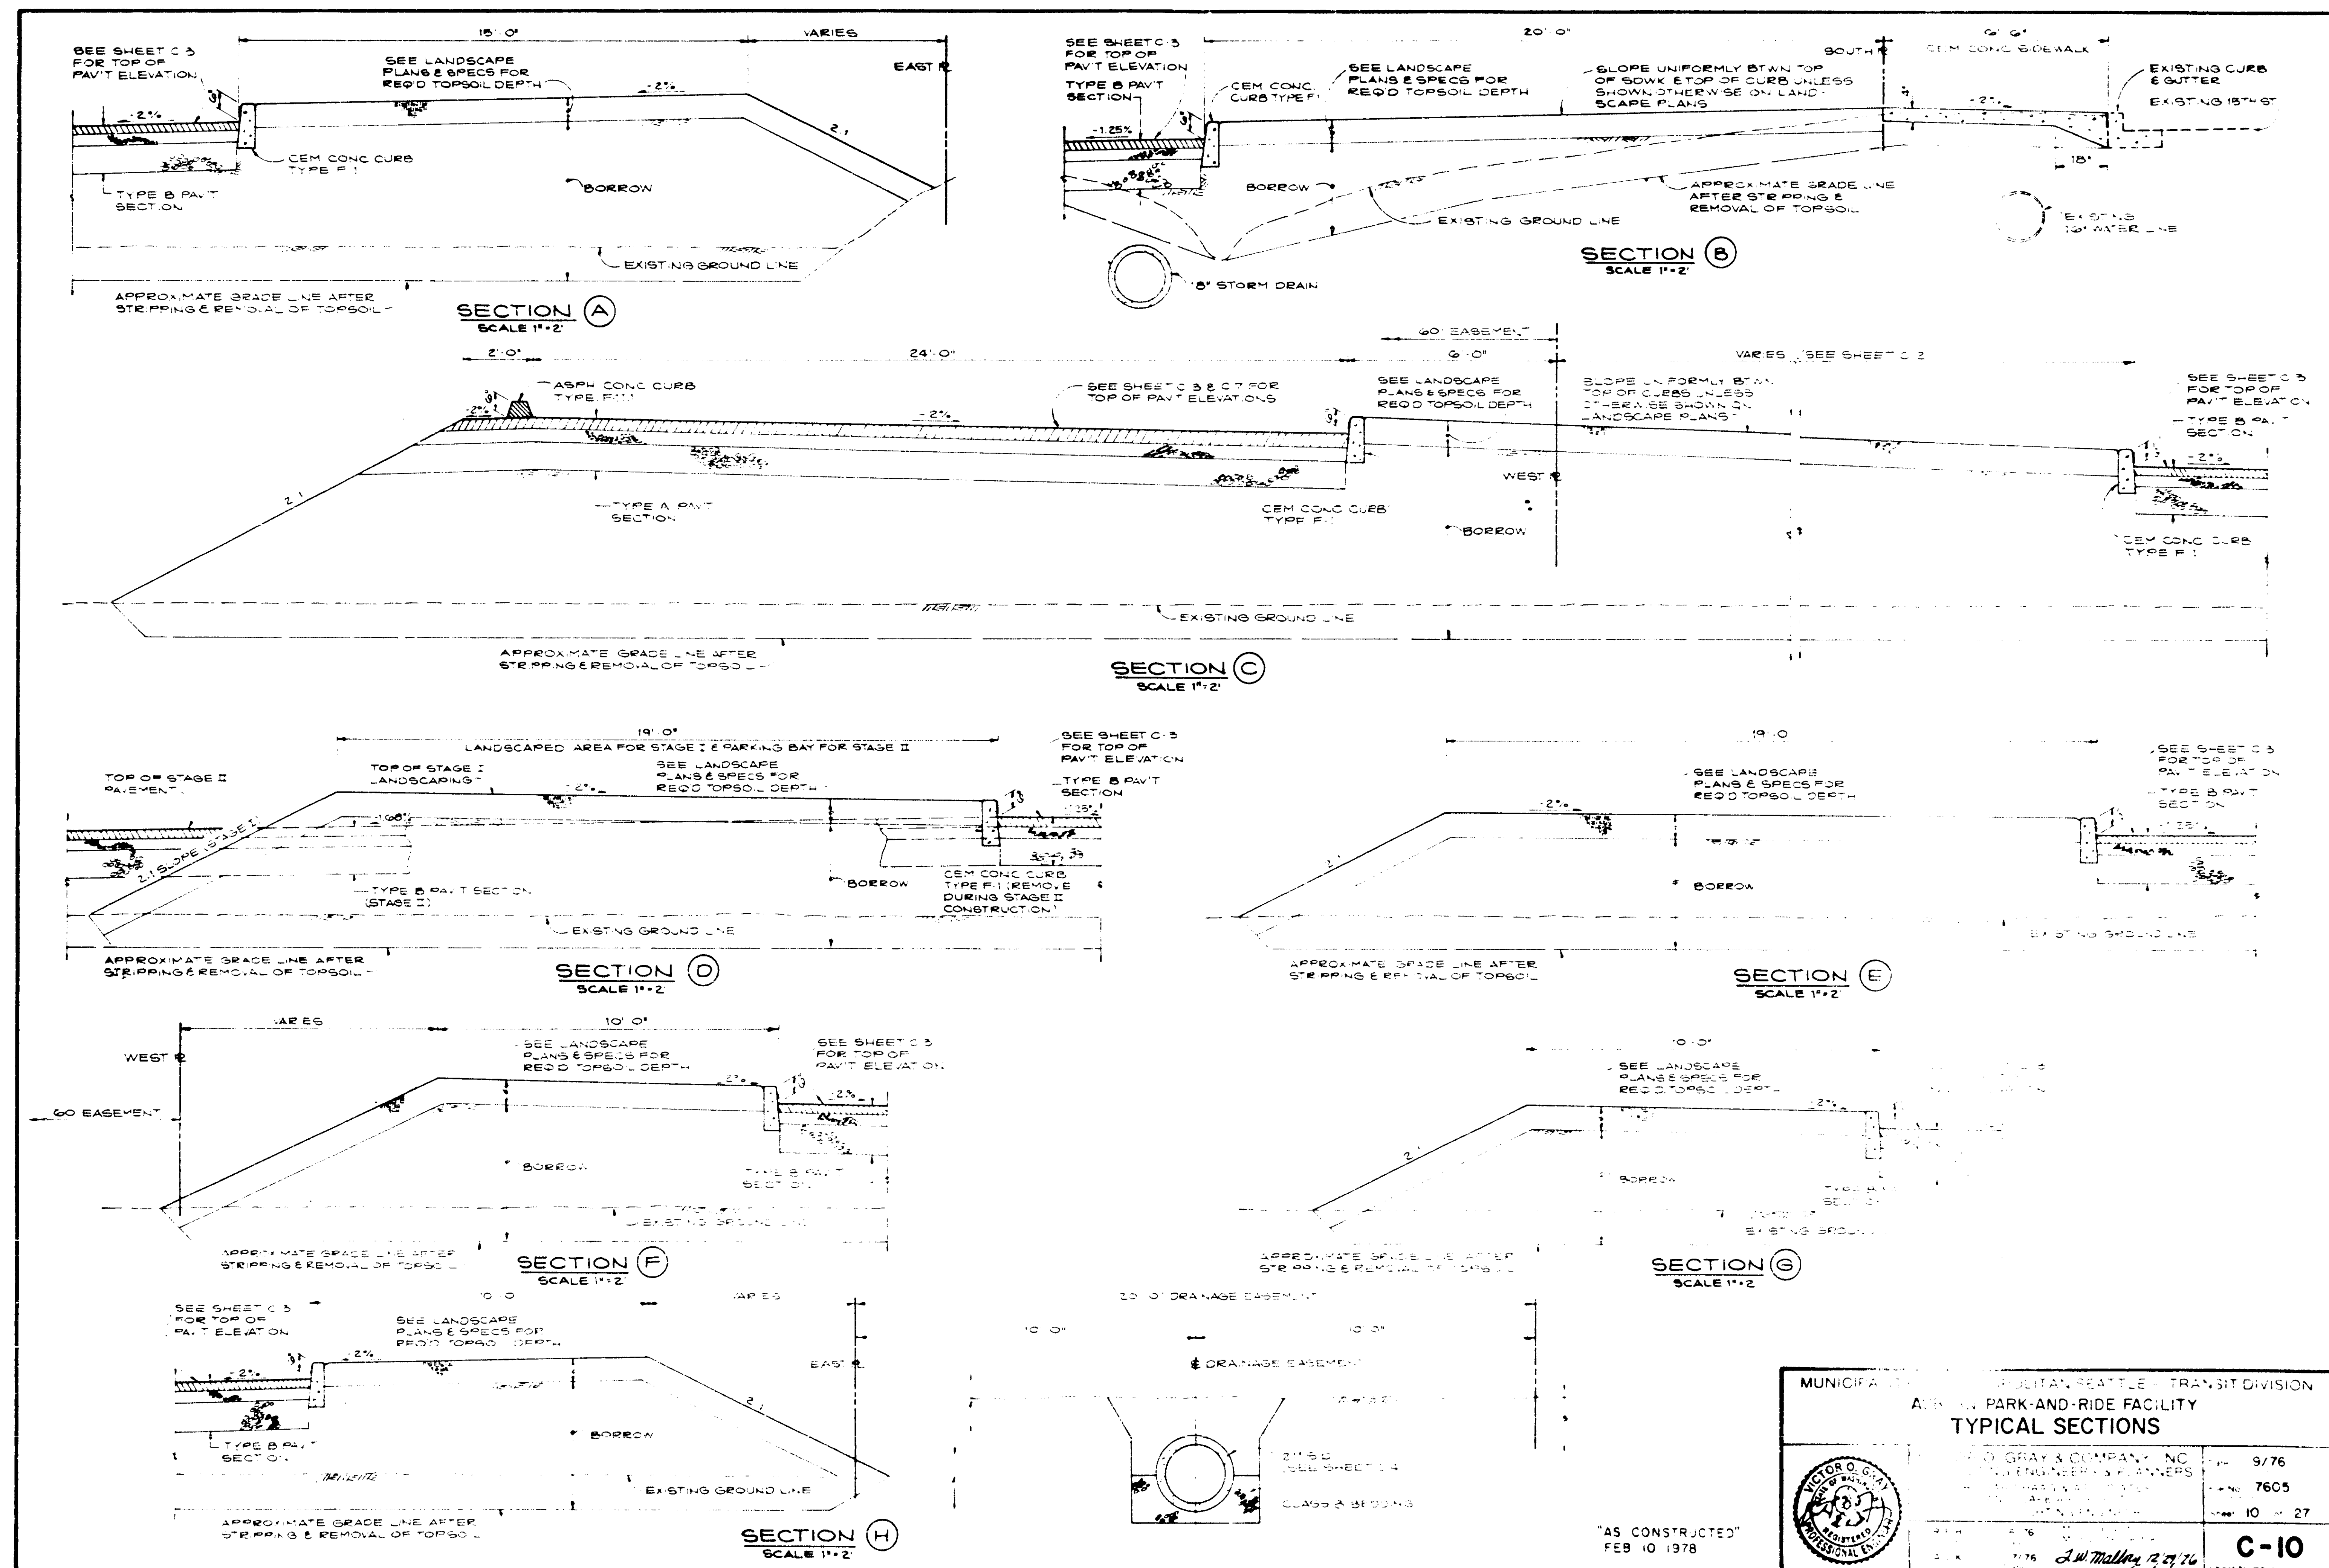


1 2 3 4 5 6
ST FT IN 21 11 01 6 8 2 9 2 4 6 7 0 1


16 X

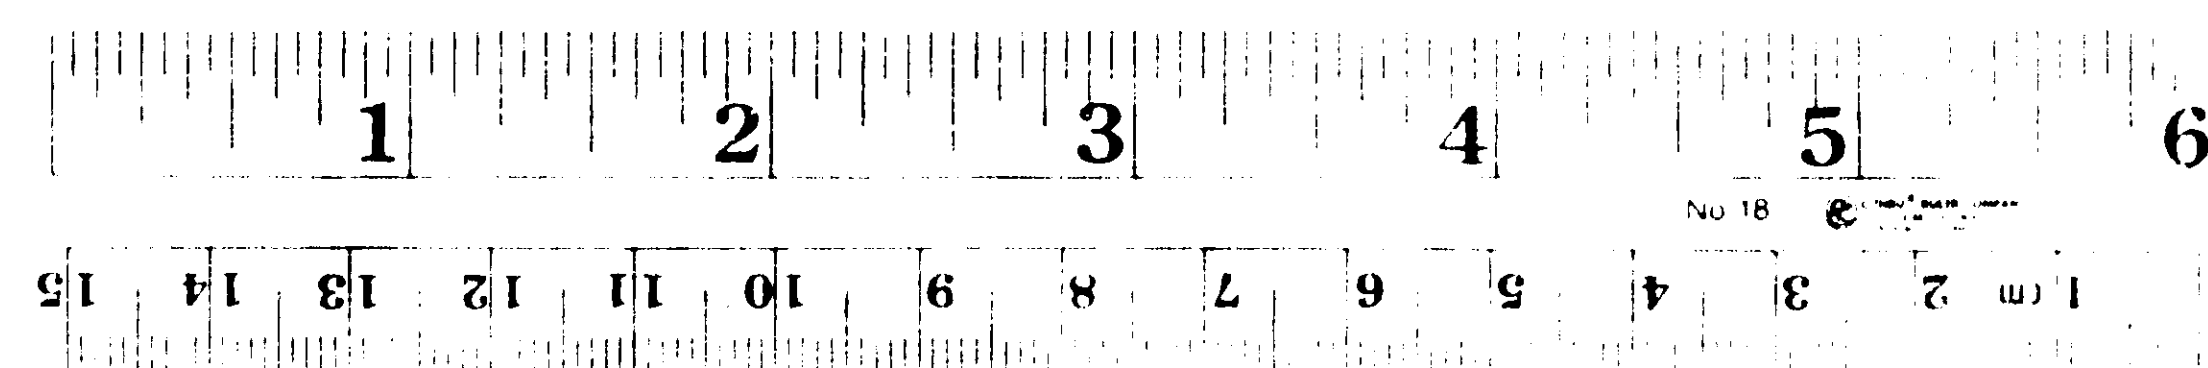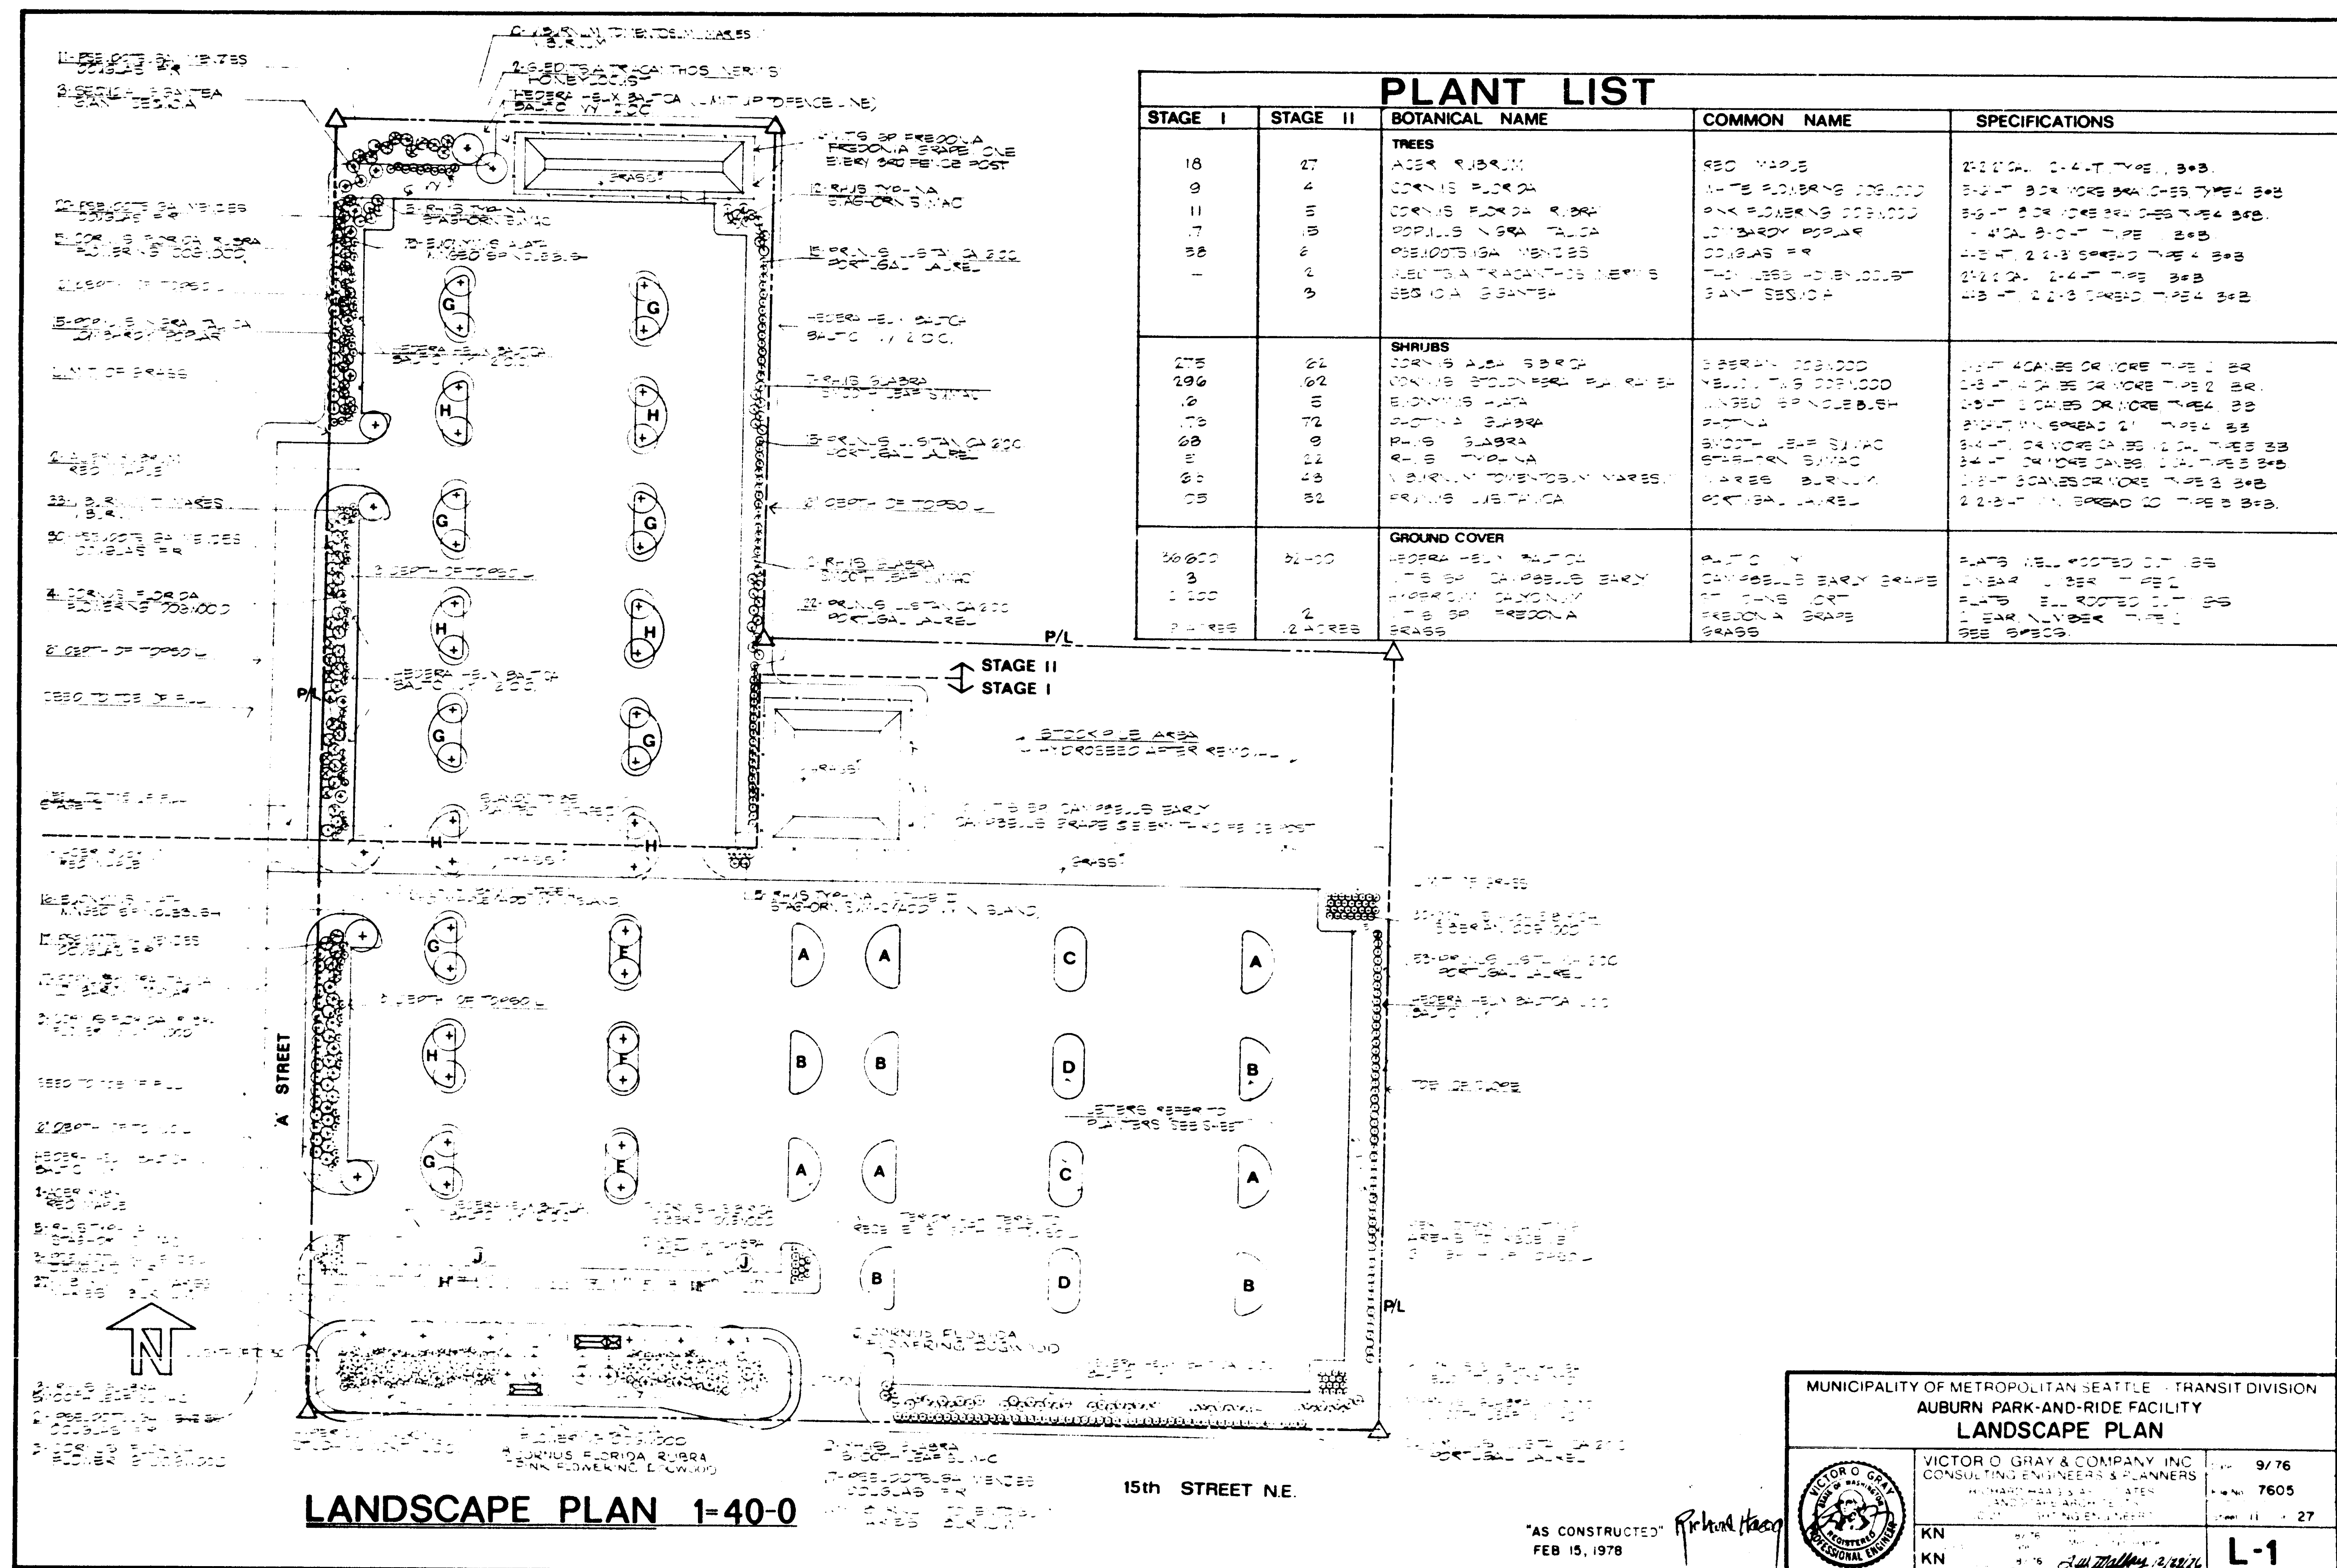


16 X

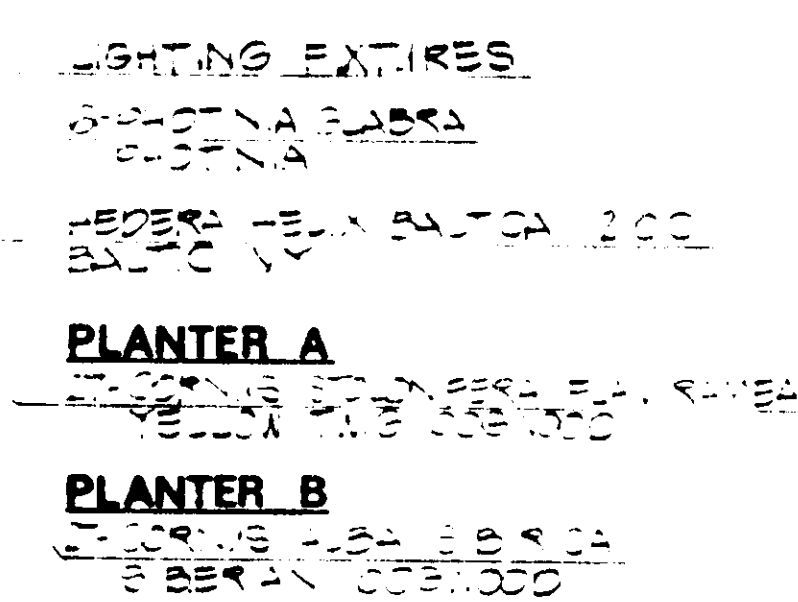


PLANTERS A & B

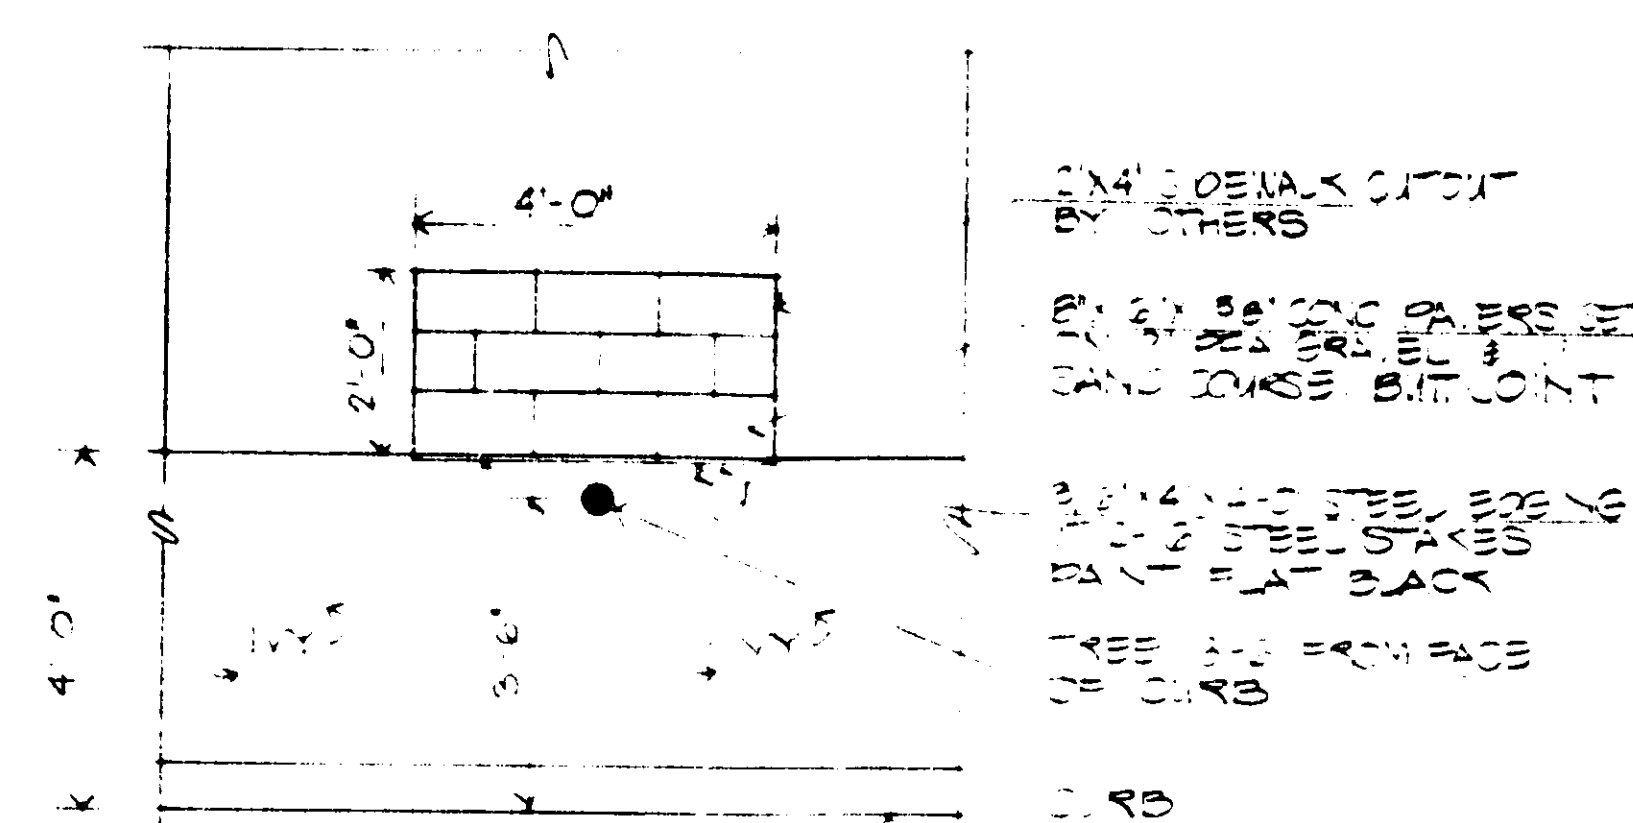


TREE CUTOUT 1 100 100

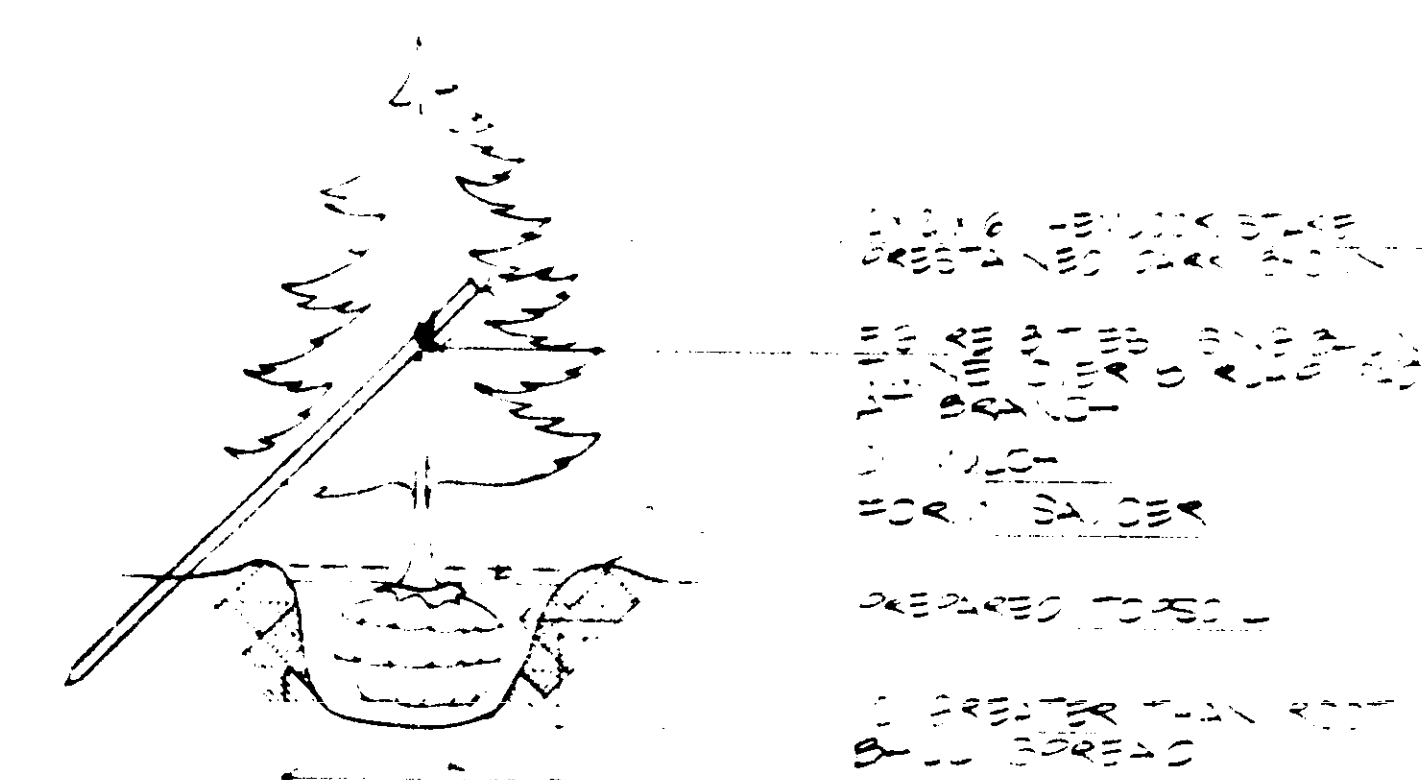


EVERGREEN STAKING

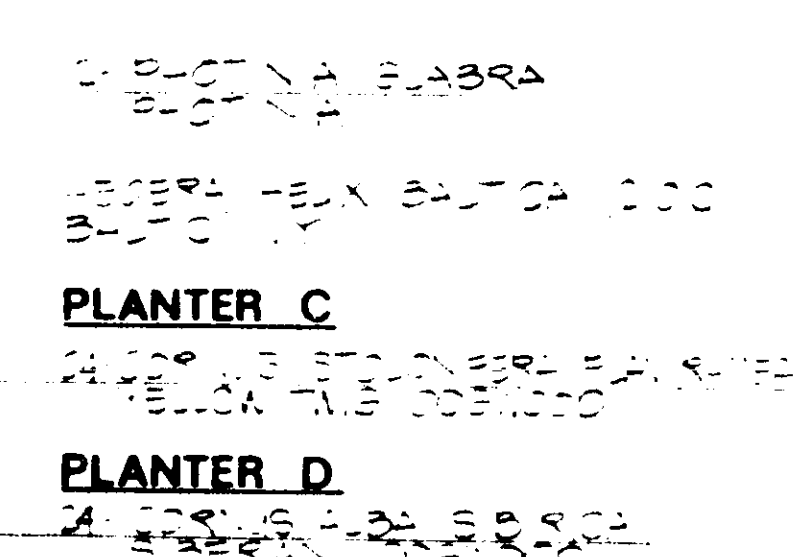


PLANTERS C & D

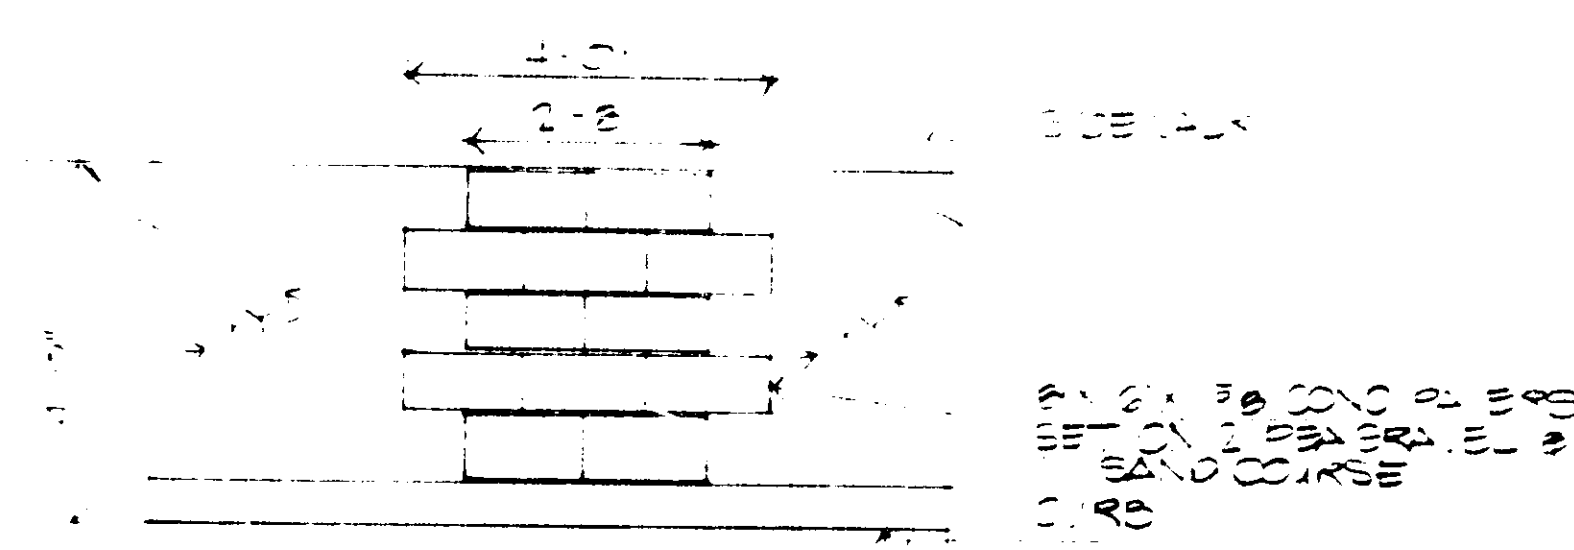


PAVER WALK J

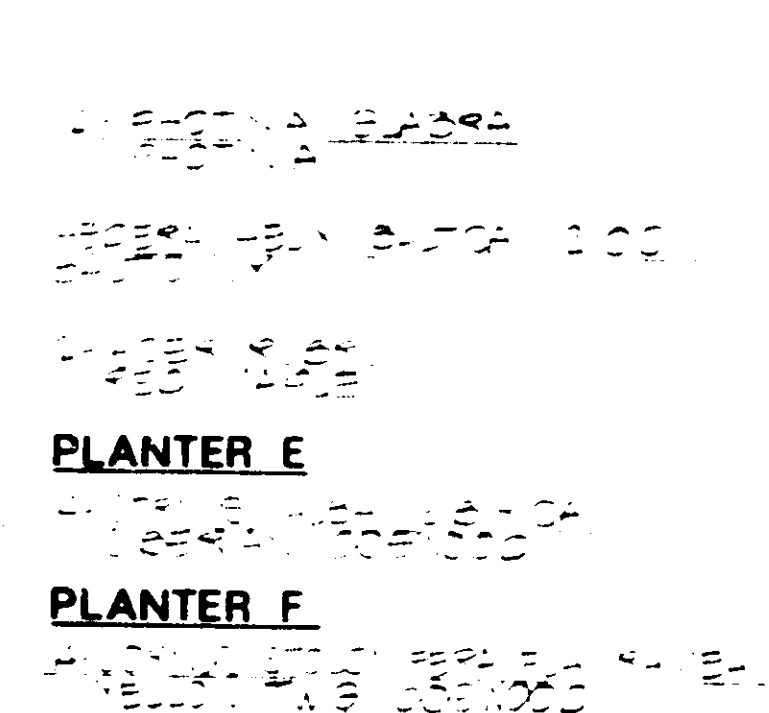


PLANTER E & F

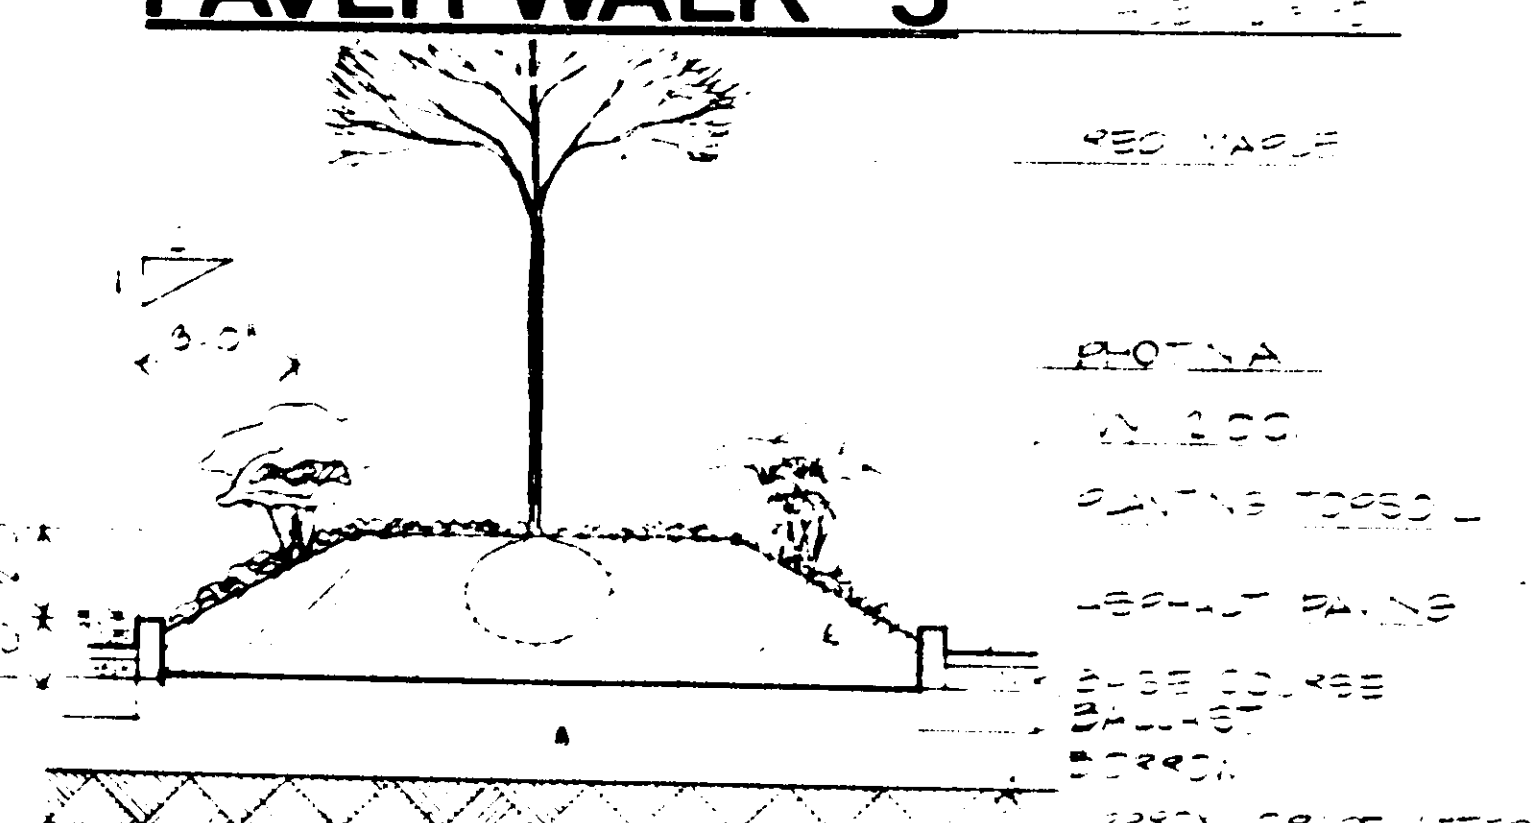


SECTION A-A'

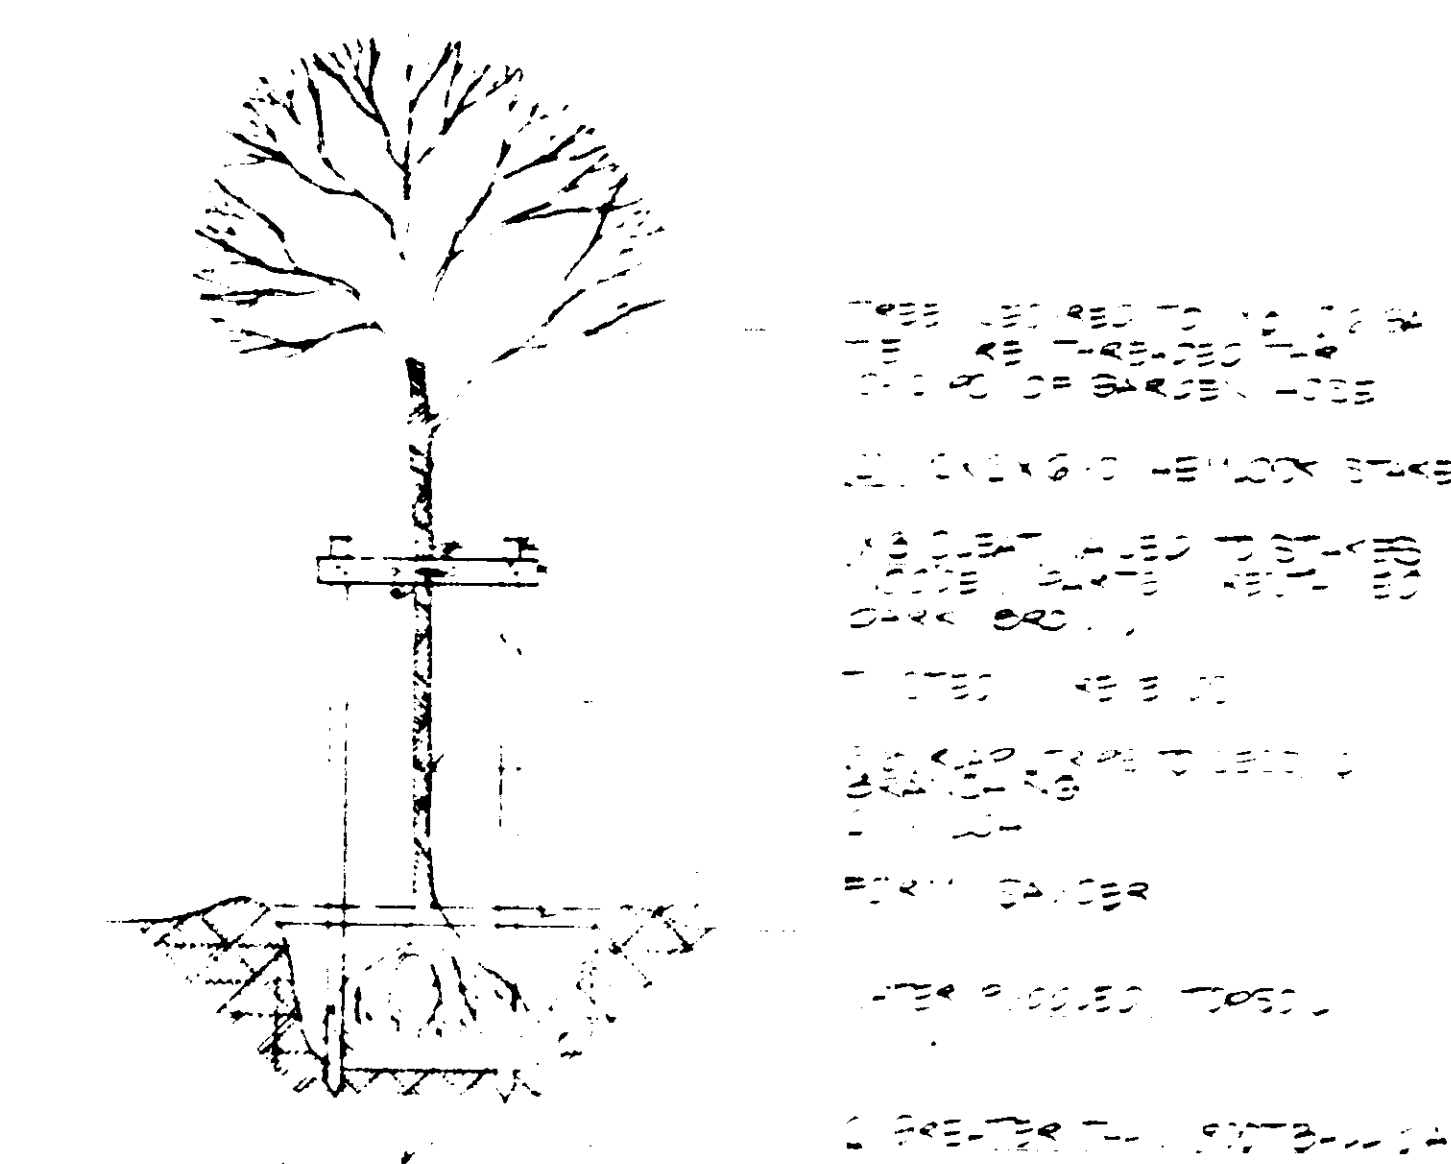

DEC. TREE STAKING

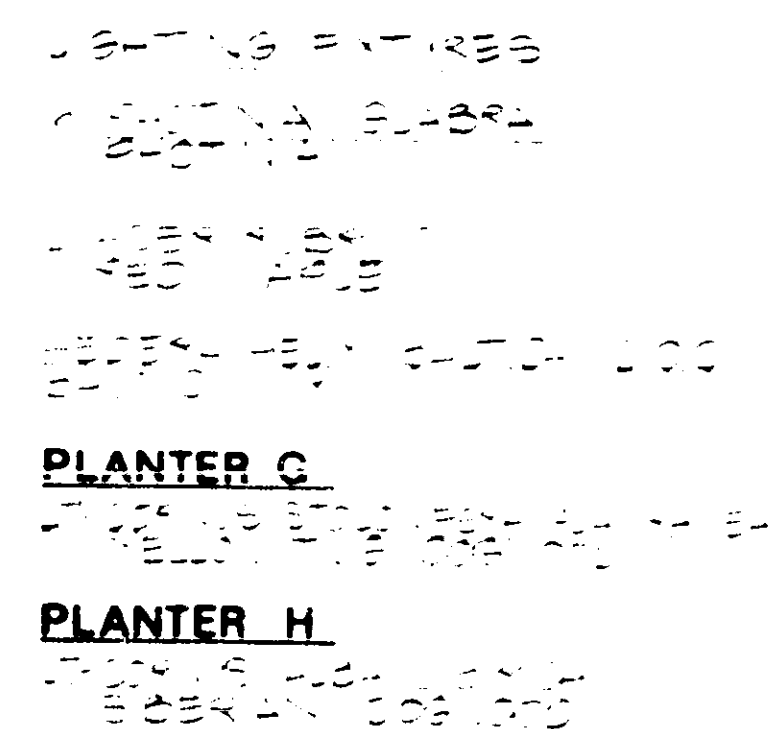

PLANTERS G & H

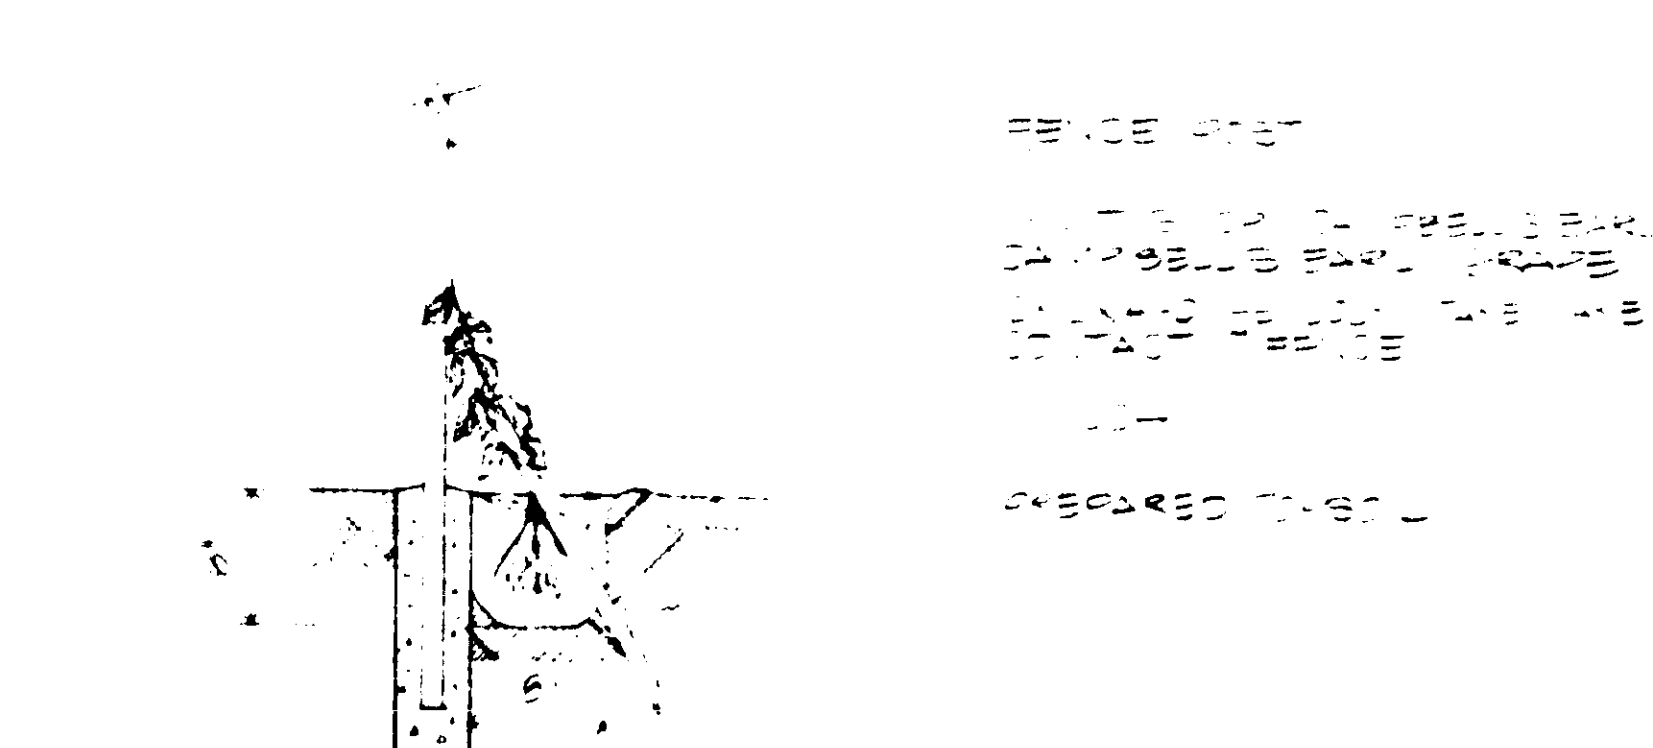



VINE STAKING


MUNICIPALITY OF METROPOLITAN SEATTLE -- TRANSIT DIVISION	
AUBURN PARK-AND-RIDE FACILITY	
LANDSCAPE DETAILS	
	VICTOR O. GRAY & COMPANY INC. CONSULTING ENGINEERS & PLANNERS 10000 1 ST AVENUE, SUITE 100 SEATTLE, WASH. 98108 PHONE 276-1111
	DATE 9/76 SHEET NO. 7605 OF 12
	KN KN L-27 S.W. Mather 10/1/76

87M-671 13 OF 17

16 X

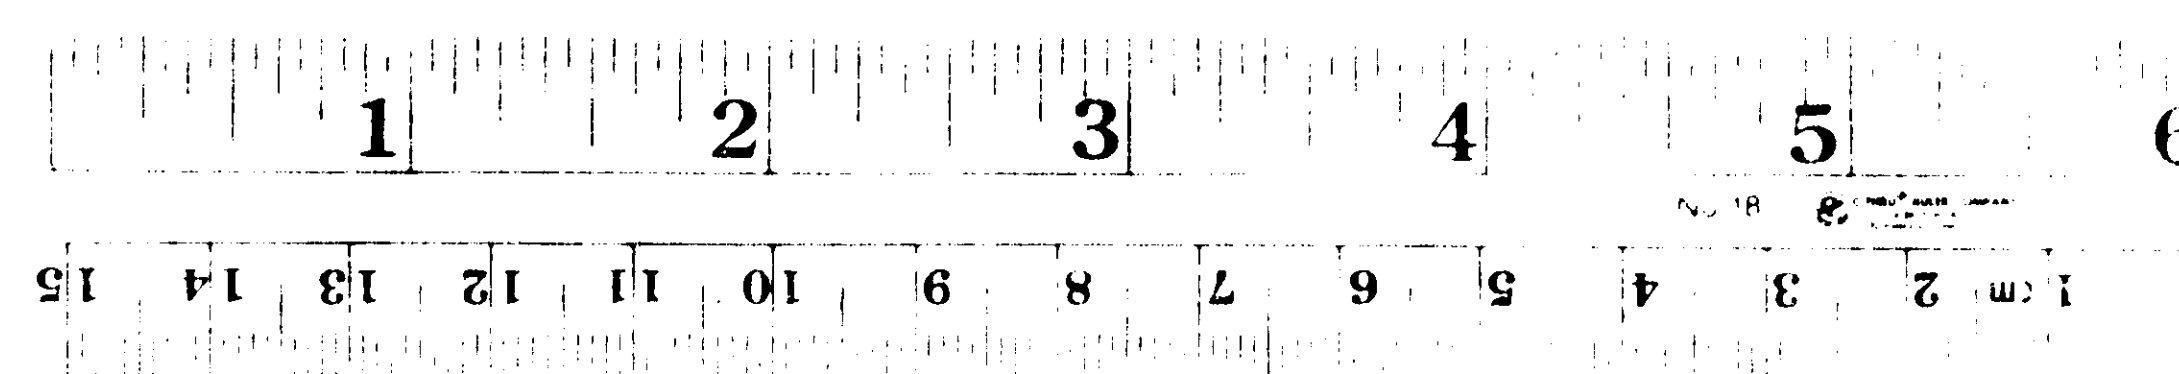

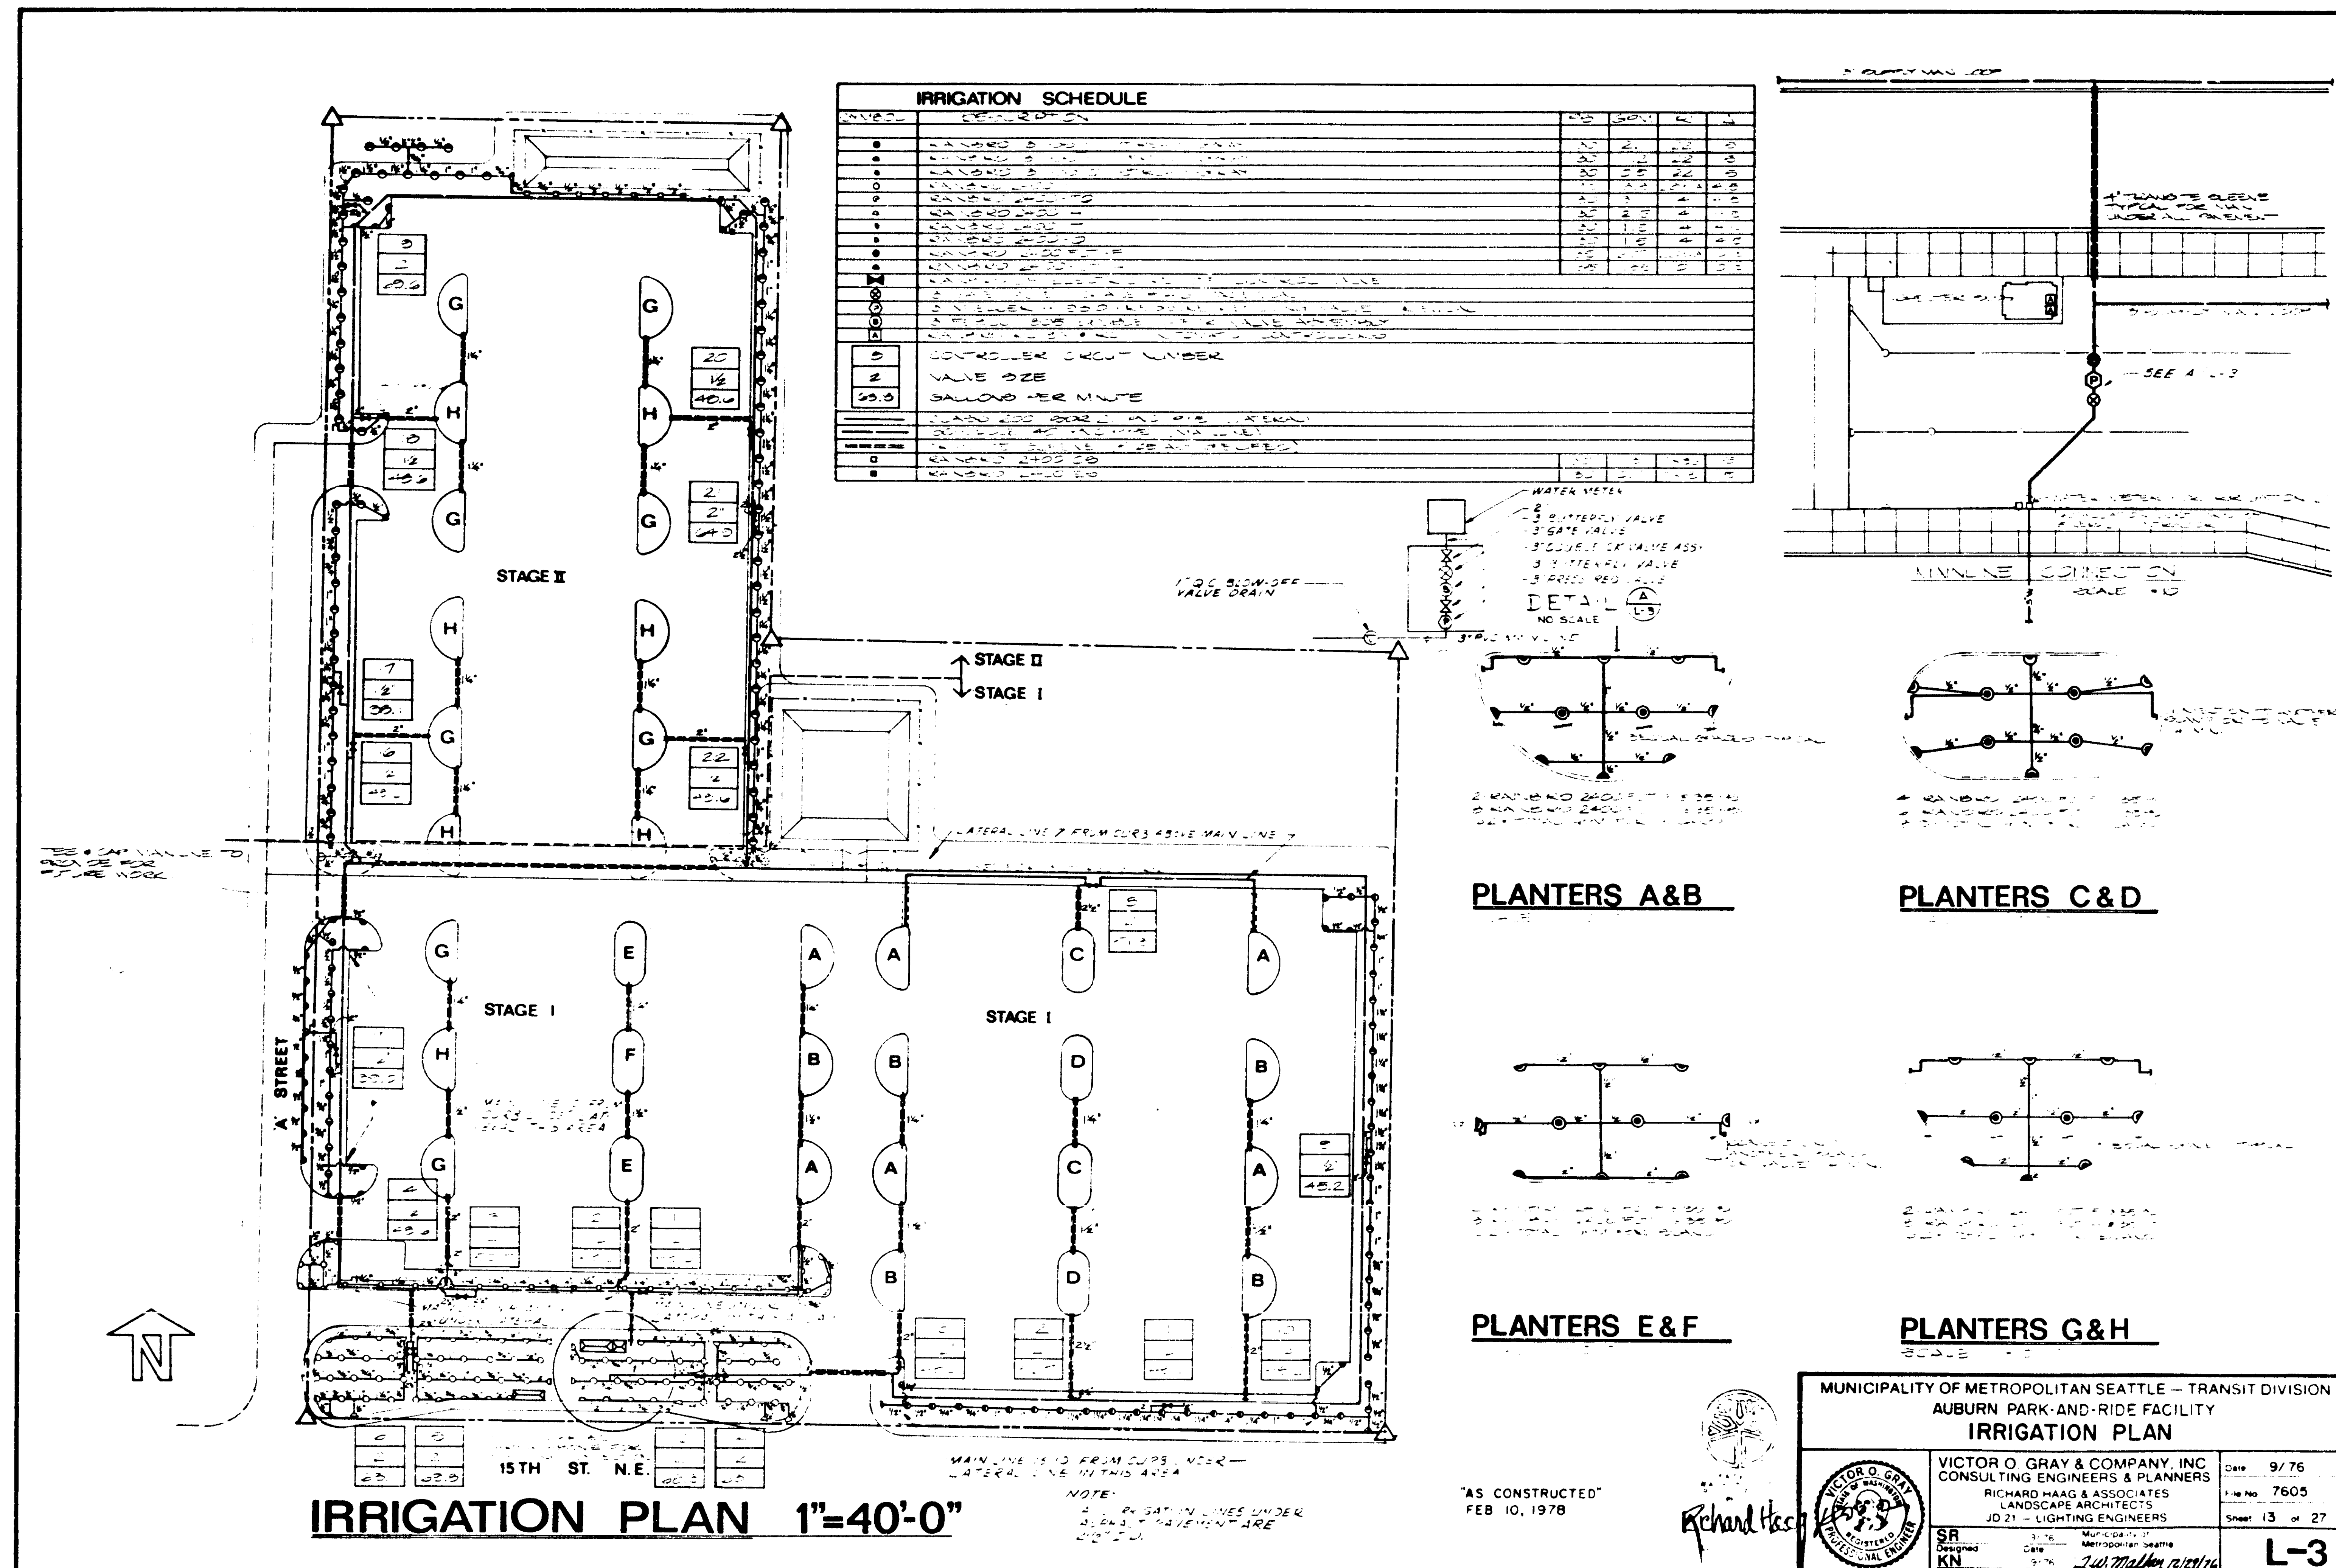

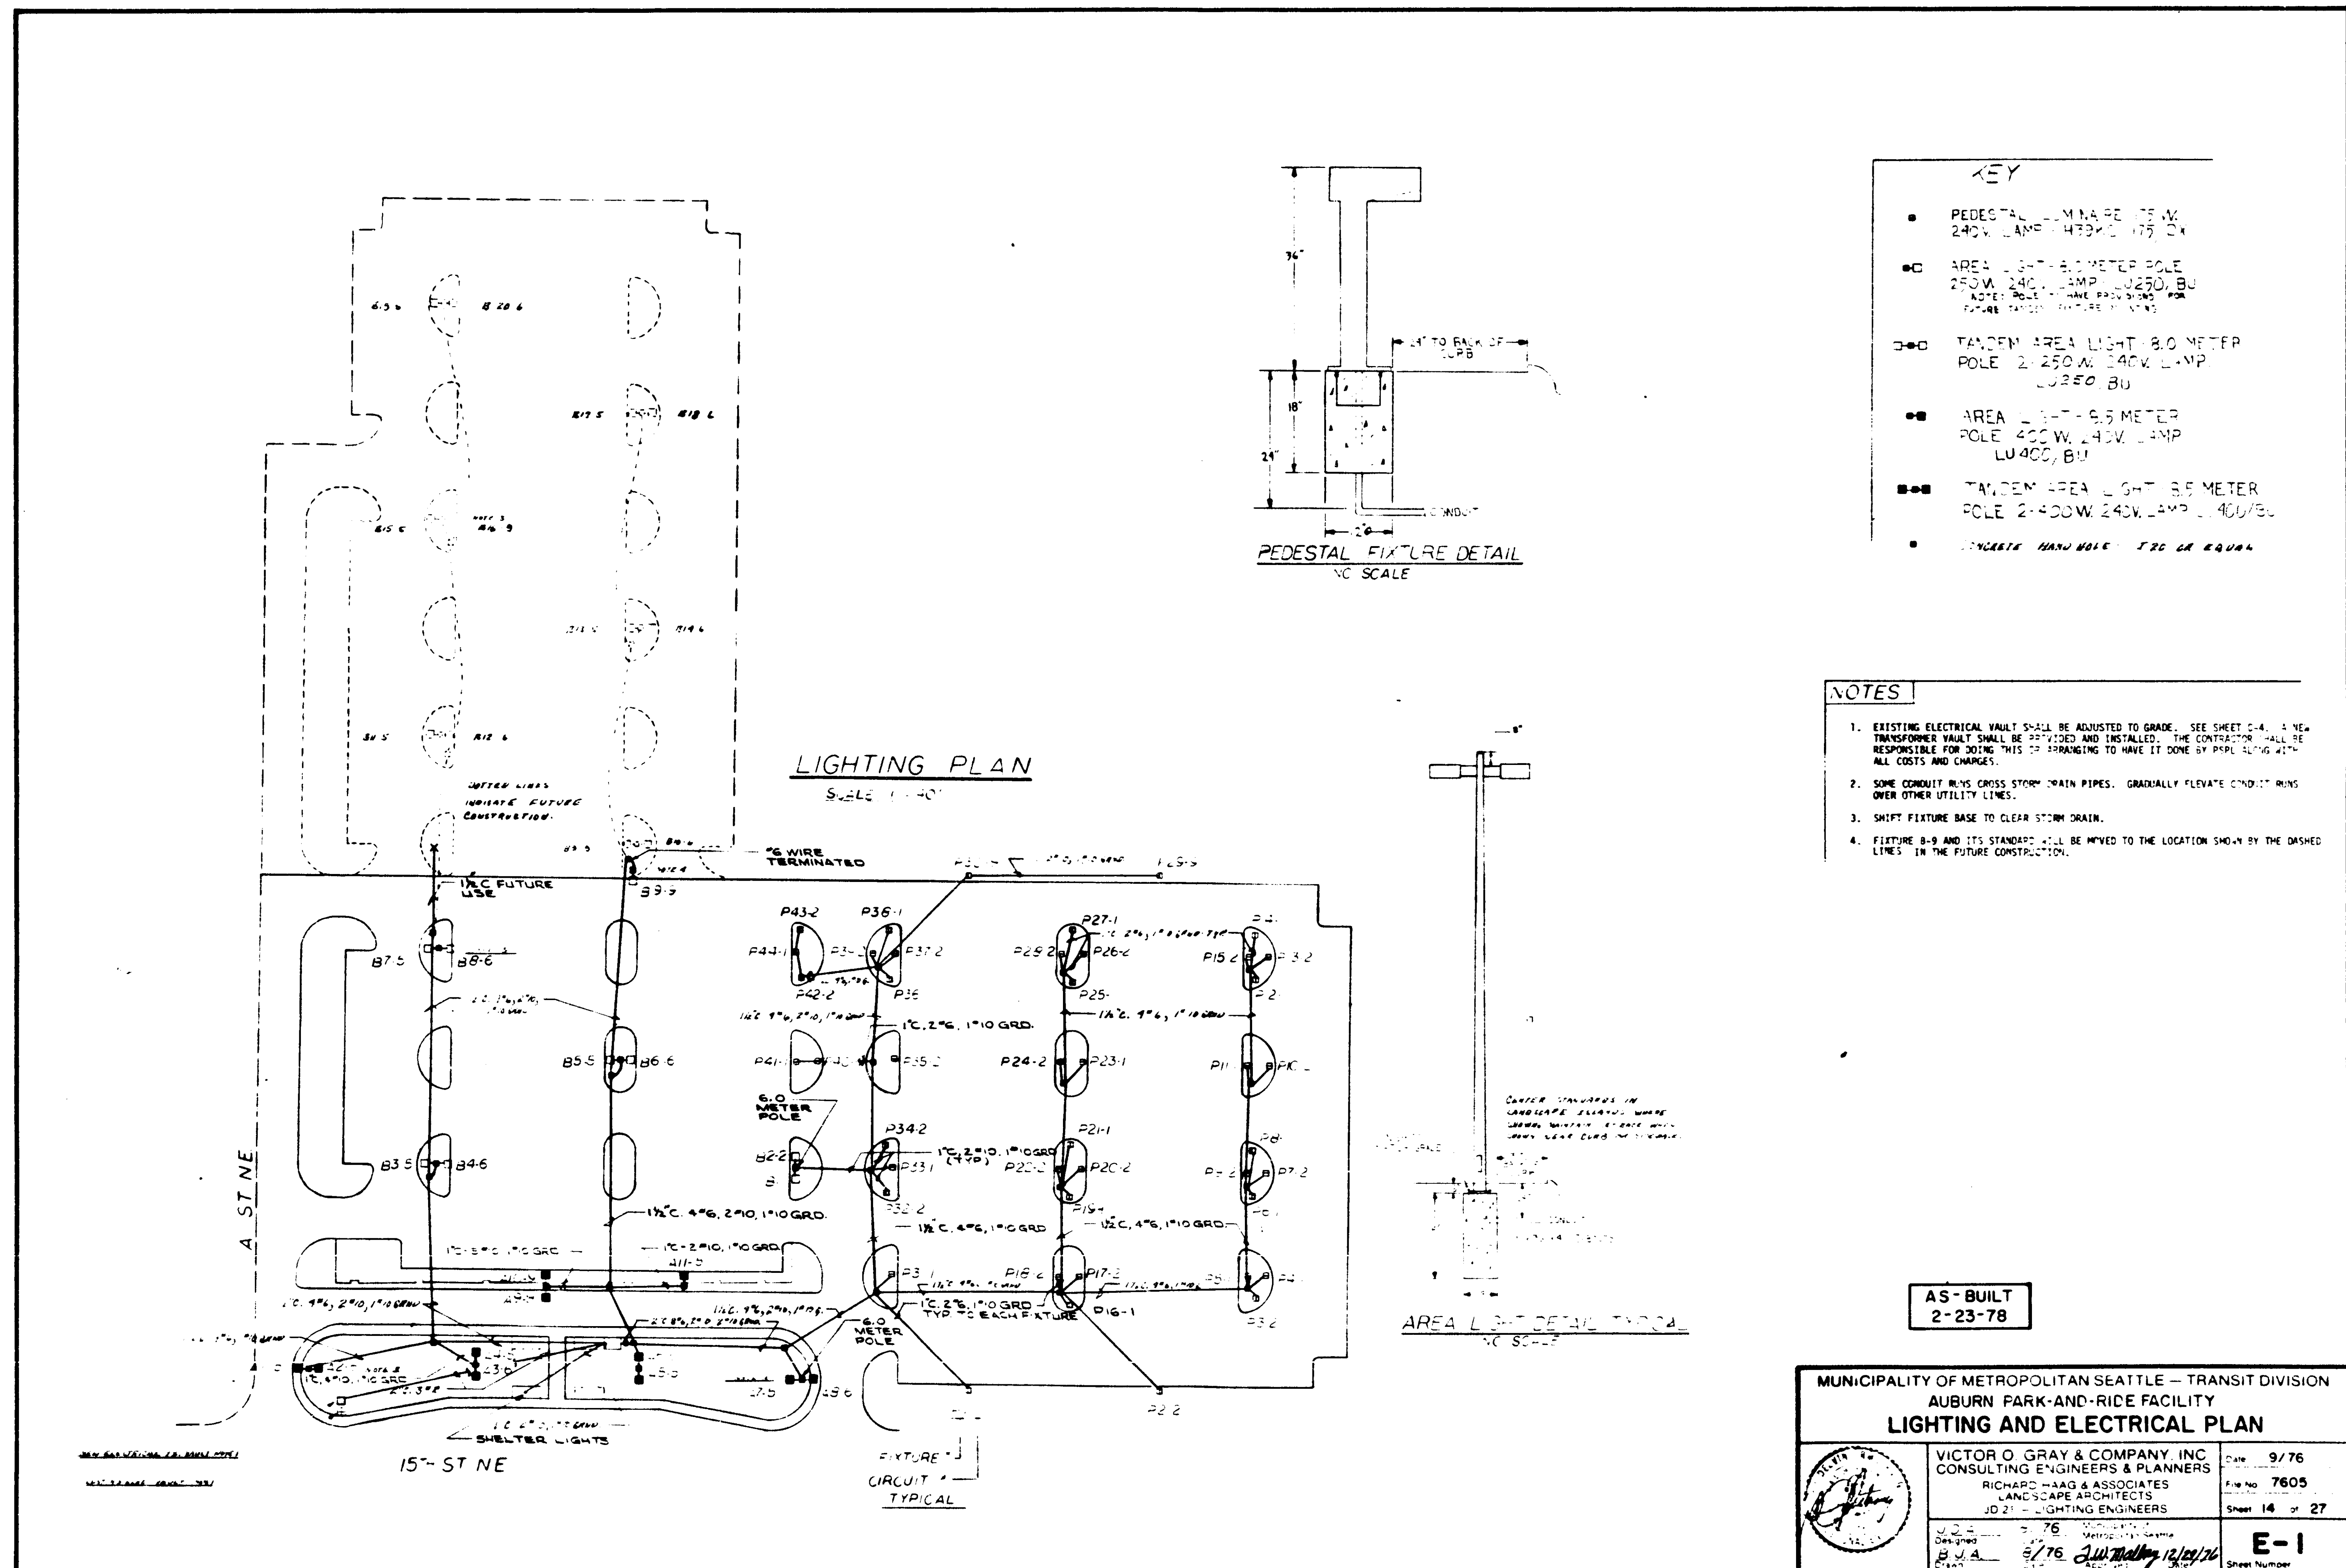



- KEY**
- PEDESTAL LAMP 175 W. 240V. LAMP LU250, BU.
 - AREA LIGHT 8.0 METER POLE 250 W. 240V. LAMP LU250, BU. (NOTE: POLE TO BE RASSED FOR FUTURE TANDUM LIGHTING)
 - TANDUM AREA LIGHT 8.0 METER POLE 2x250 W. 240V. LAMP LU250, BU.
 - AREA LIGHT 8.5 METER POLE 400 W. 240V. LAMP LU400, BU.
 - TANDUM AREA LIGHT 8.5 METER POLE 2x400 W. 240V. LAMP LU400, BU.
 - CONCRETE HAND HOLE 120 CM SQUARE

- NOTES**
- EXISTING ELECTRICAL VAULT SHALL BE ADJUSTED TO GRADE. SEE SHEET E-4. A NEW TRANSFORMER VAULT SHALL BE PROVIDED AND INSTALLED. THE CONTRACTOR SHALL BE RESPONSIBLE FOR DOING THIS OR ARRANGING TO HAVE IT DONE BY PERMITTING WITH ALL COSTS AND CHARGES.
 - SOME CONDUIT RUNS CROSS STORM DRAIN PIPES. GRADUALLY ELEVATE CONDUIT RUNS OVER OTHER UTILITY LINES.
 - SHIFT FIXTURE BASE TO CLEAR STORM DRAIN.
 - FIXTURE B-9 AND ITS STANDOFF WILL BE MOVED TO THE LOCATION SHOWN BY THE DASHED LINES IN THE FUTURE CONSTRUCTION.

AS-BUILT
2-23-78


MUNICIPALITY OF METROPOLITAN SEATTLE - TRANSIT DIVISION AUBURN PARK-AND-RIDE FACILITY LIGHTING AND ELECTRICAL PLAN		
	VICTOR O. GRAY & COMPANY, INC. CONSULTING ENGINEERS & PLANNERS	Date 9/76
	RICHARD HAAG & ASSOCIATES LANDSCAPE ARCHITECTS JD 21 - LIGHTING ENGINEERS	File No. 7605 Sheet 14 of 27
Designed by B.O.G.	5/76	Checked by J.M. Melling 12/24/76
Drawn by		E-1 Sheet Number

87M-671 15 of 17

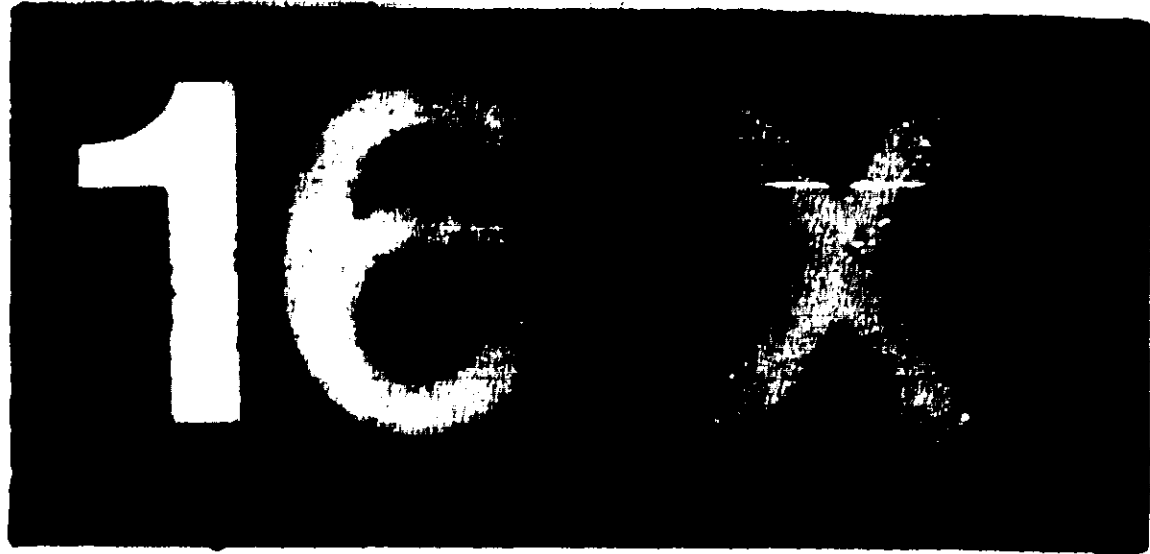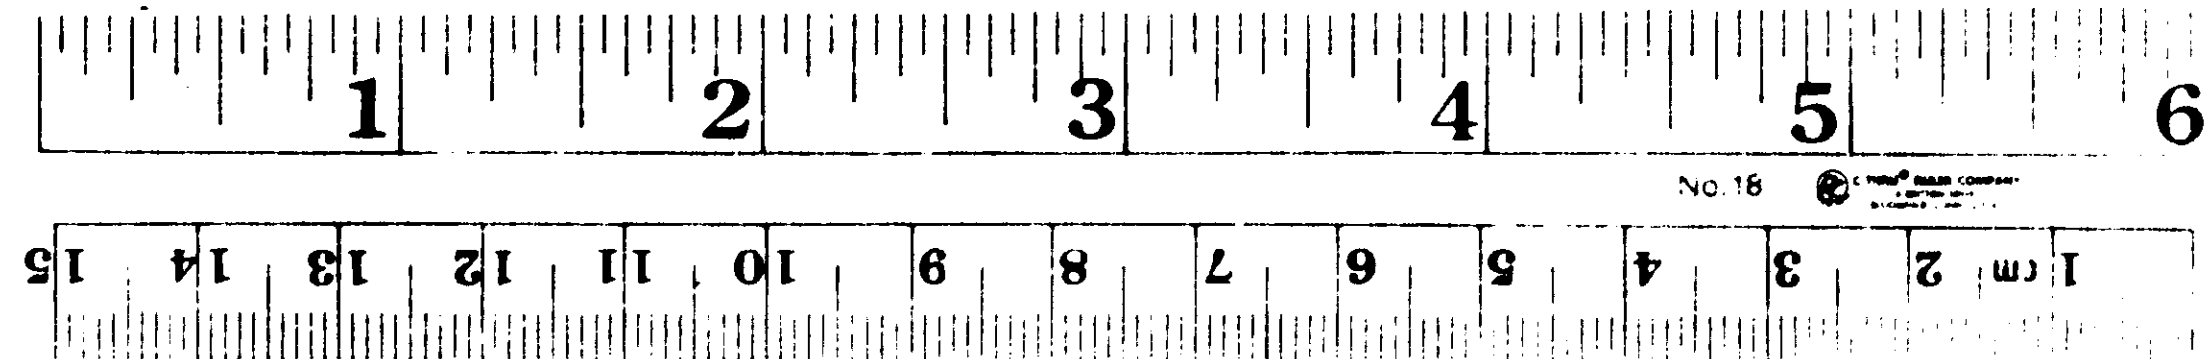


MAIN PANEL SCHEDULE

CIRCUIT #	BREAKER	COWTACTOR	WIRE	LOAD (KW)		TO
				A	B	
MAIN	2P100A		#2	10, 34	10, 34	74 A. MAX./#
1, 3	2P30A	2P30A	#6	3, 72	3, 72	AREA LIGHTS
2, 4	2P90A	2P90A	#6	3, 72	3, 72	AREA LIGHTS
5, 7	2P30A	2P30A	#6	1, 50	1, 51	AREA LIGHTS
6, 8	2P30A	2P30A	#6	1, 30	1, 30	AREA LIGHTS
9, 11	2P30A	TIME CLOCK TC-1	#10	1, 30	1, 00	SECURITY LIGHTS
10, 12	2P30A					SPARE
13	2P20A	--	#12	0, 20		LIGHT AND FAN
14	1P20A		#12	0, 40		RECEPTACLES
15	1P20A		#12		0, 75	WALL HEATER
16	1P20A		#12			HOT WATER HEATER
17	1P20A		#12	0, 20		IRR. CONTROL
18	1P20A					SPARE
19	1P20A		#12			SHELTER LIGHTING
20	2P20A		#12			TIME CLOCKS & CONTROL

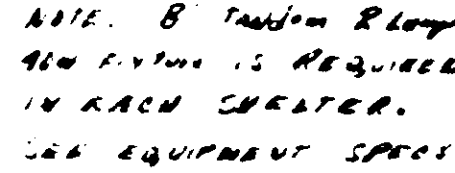

DRIVER'S TOILET ELECTRICAL PLAN

SCALE $\frac{1}{2}'' = 12'$

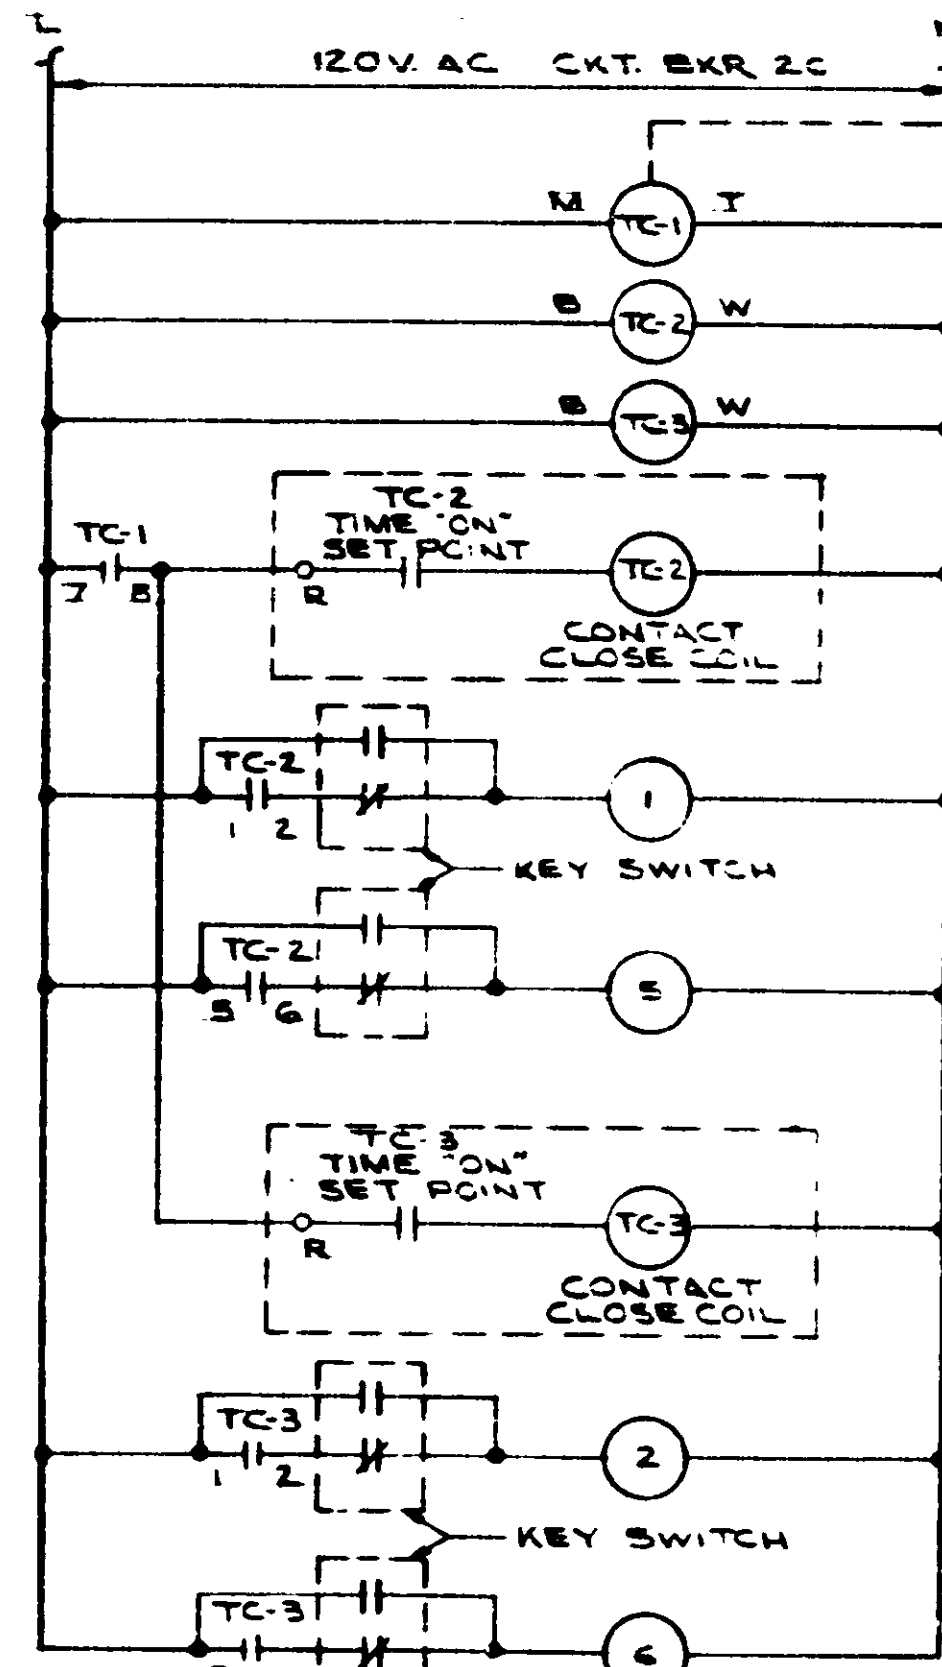

LIGHTING CONTROL

AS - BUILT
2-23-78

MUNICIPALITY OF METROPOLITAN SEATTLE — TRANSIT DIVISION
AUBURN PARK-AND-RIDE FACILITY
ELECTRICAL DETAILS

VICTOR O. GRAY & COMPANY, INC.	DATE 9/76
--------------------------------	-----------

CONSULTING ENGINEERS & PLANNERS
RICHARD HAAG & ASSOCIATES

JD 21 - LIGHTING ENGINEERS

J.D.A. Designed	8/76 Date	Municipality of Metropolitan Seattle	5
--------------------	--------------	---	---

J.D.A.
 8/76
 Date

DATE: 11/11/11 APPROVING: [Signature] SHEET NUMBER: 1

87M-671K

100

POST

THE



121

100

100

87M-671 16 of 17

16

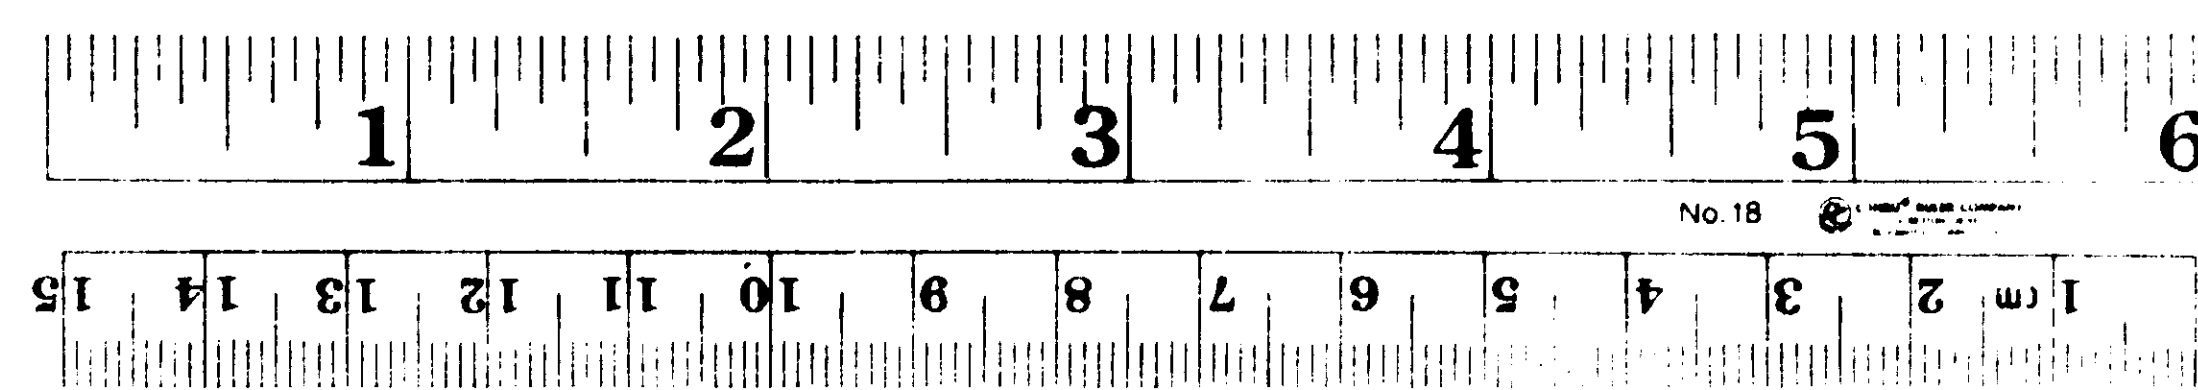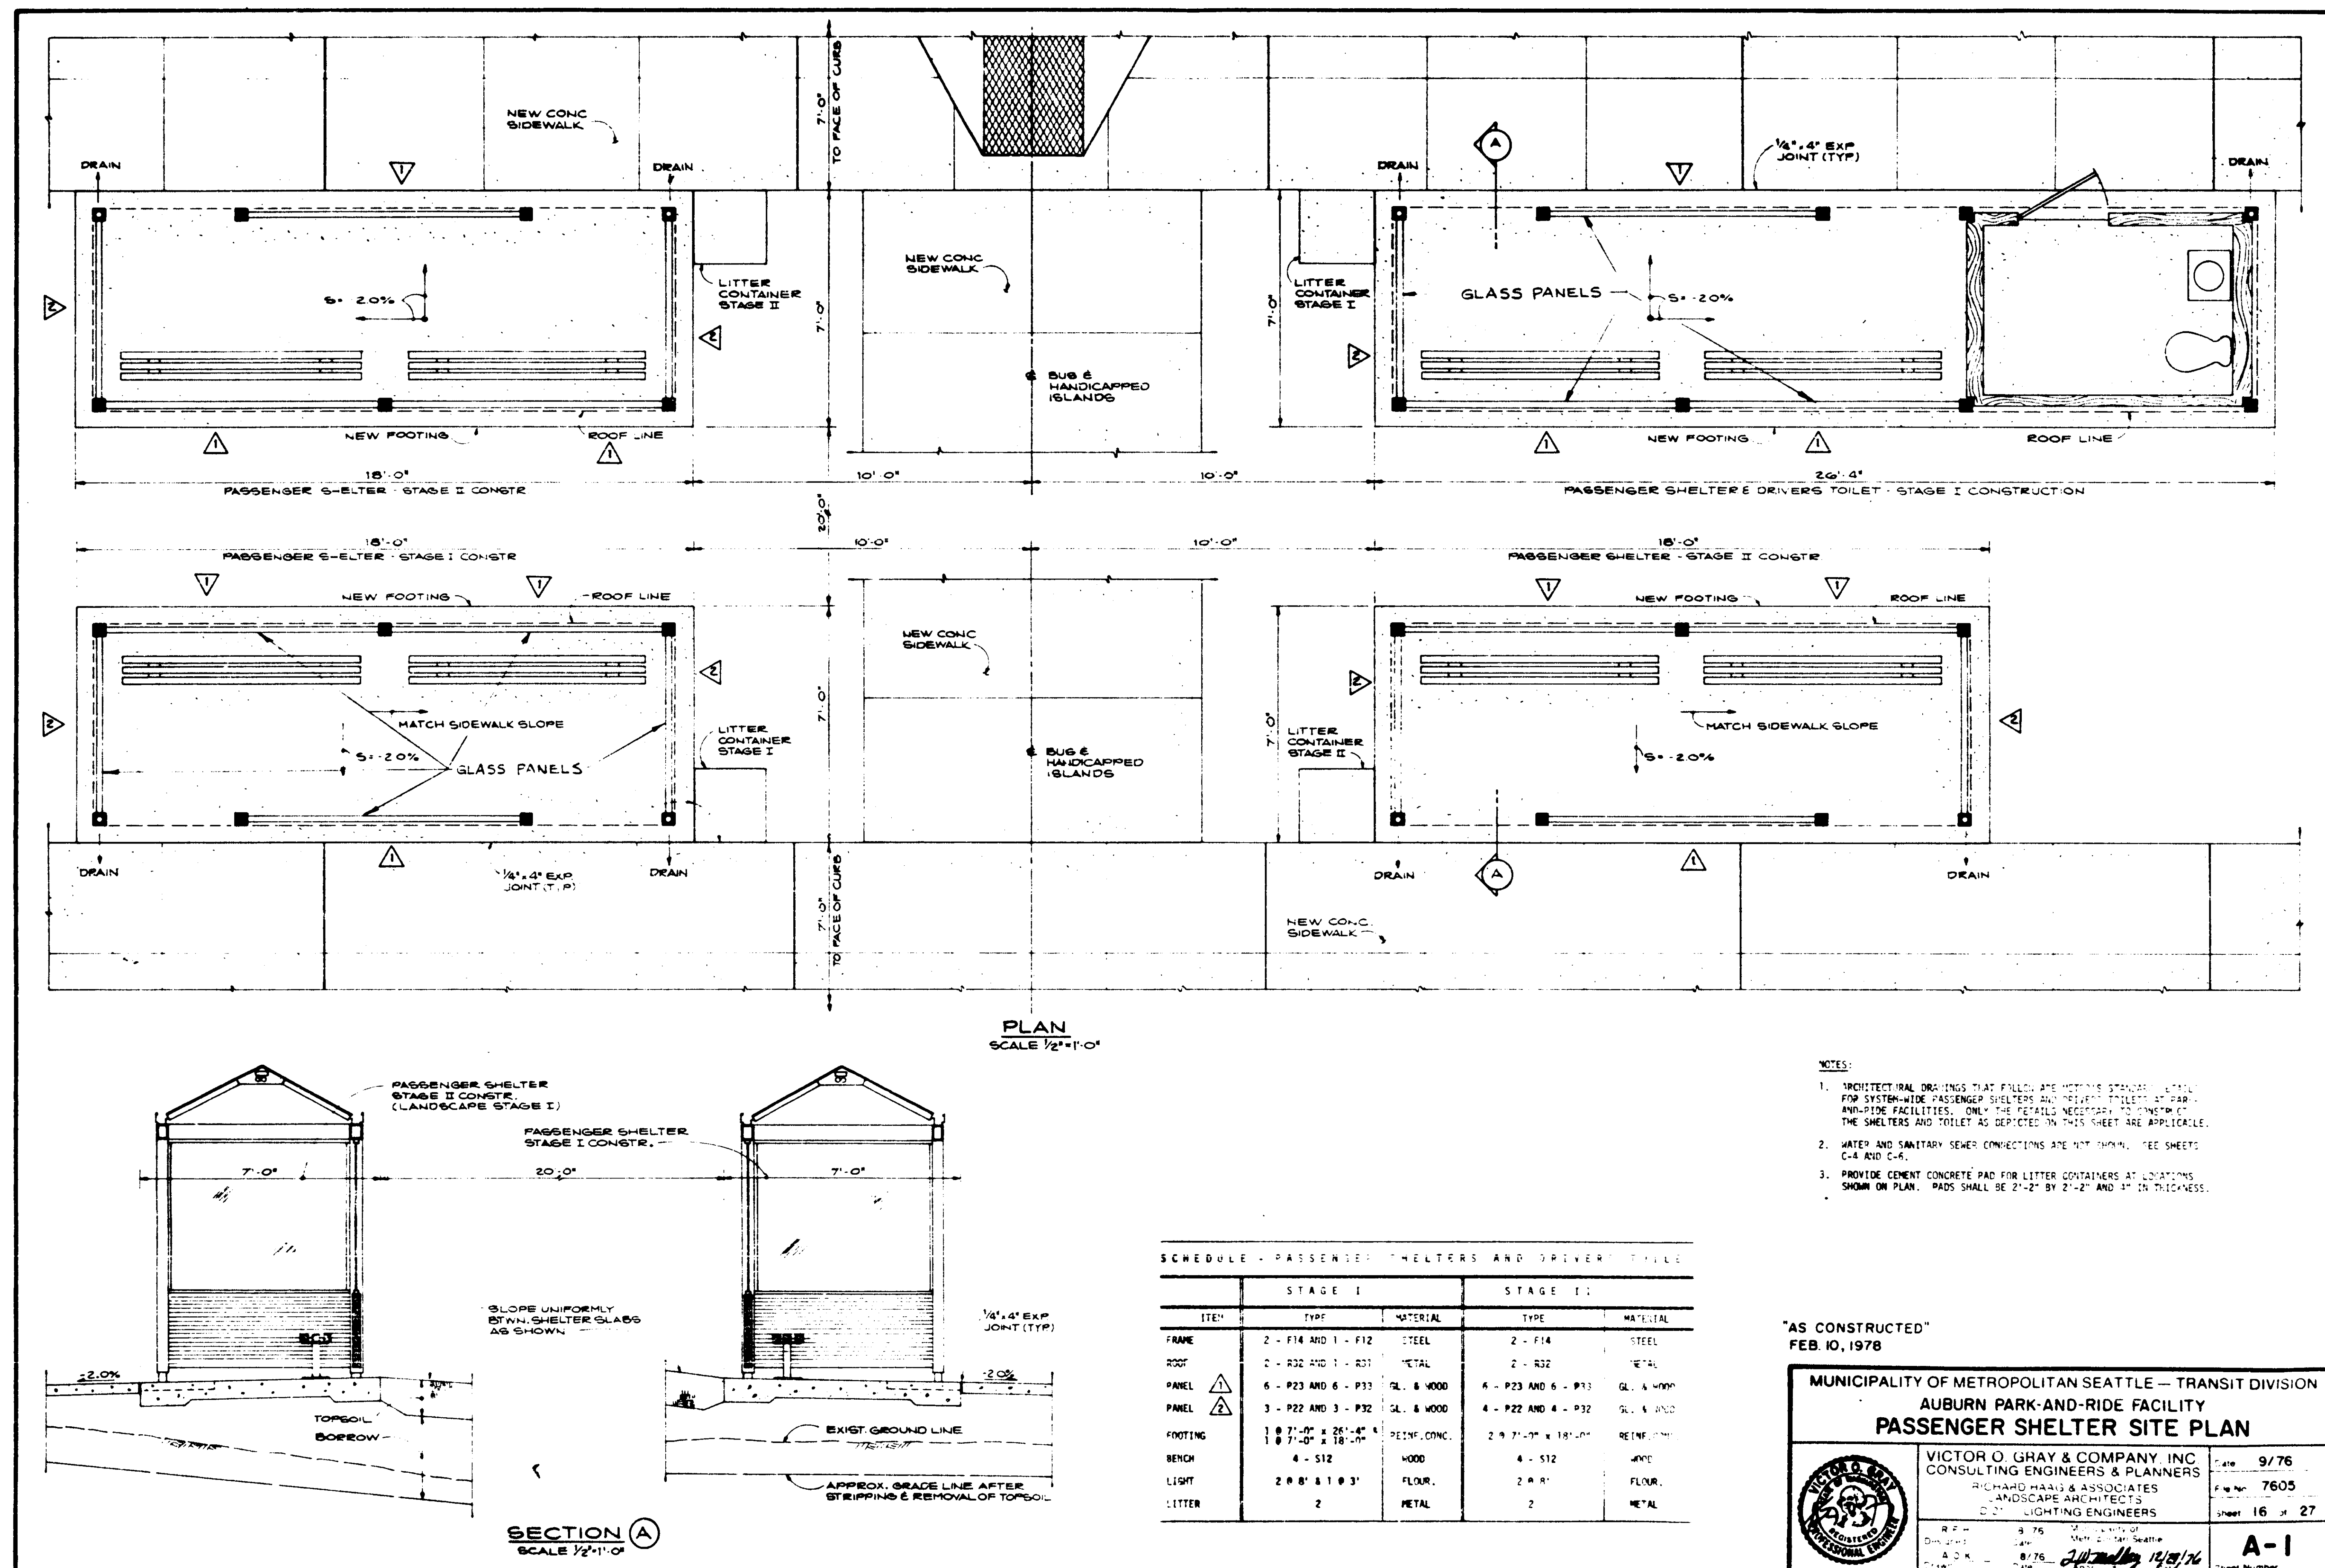

16 X