

MUNICIPALITY OF METROPOLITAN SEATTLE - KING COUNTY, WASHINGTON
METRO TRANSIT PROJECT CONTRACT NUMBER T6A-76

FOR

AUBURN PARK - AND - RIDE FACILITY

VICTOR O. GRAY & COMPANY CONSULTING ENGINEERS & PLANNERS

RICHARD HAAG & ASSOCIATES CONSULTING LANDSCAPE ARCHITECTS

JD-21 LIGHTING ENGINEERS CONSULTING ELECTRICAL ENGINEERS

INDEX TO DRAWINGS

CIVIL

C-1 EXISTING SITE DATA
C-2 SITE LAYOUT
C-3 GRADING PLAN
C-4 UTILITIES PLAN
C-5 SIGNING & STRIPING PLAN
C-6 BUS & HANDICAPPED ISLAND DETAILS
C-7 SITE PROFILES
C-8 DETENTION POND DETAILS
C-9 TYPICAL DETAILS
C-10 TYPICAL SECTIONS

LANDSCAPE & IRRIGATION

L-1 LANDSCAPE PLAN
L-2 LANDSCAPE DETAILS
L-3 IRRIGATION PLAN

LIGHTING & ELECTRICAL


E-1 LIGHTING & ELECTRICAL PLAN
E-2 ELECTRICAL DETAILS

PASSENGER SHELTER & DRIVERS TOILET


A-1 PASSENGER SHELTER SITE PLAN
A-2 GENERAL STRUCTURAL NOTES

A-3 CONCRETE FOOTINGS
A-4 FRAME PLAN & ELEVATIONS
A-5 FRAME DETAILS
A-6 DRIVERS TOILET-PLANS & ELEVATIONS
A-7 DRIVERS TOILET-WALL DETAILS
A-8 PANEL SERIES P20
A-9 PANEL SERIES P30
A-10 ROOF SERIES R30
A-11 ELECTRICAL DETAILS
A-12 BENCH SERIES S10

"AS CONSTRUCTED"
FEB. 10 1978

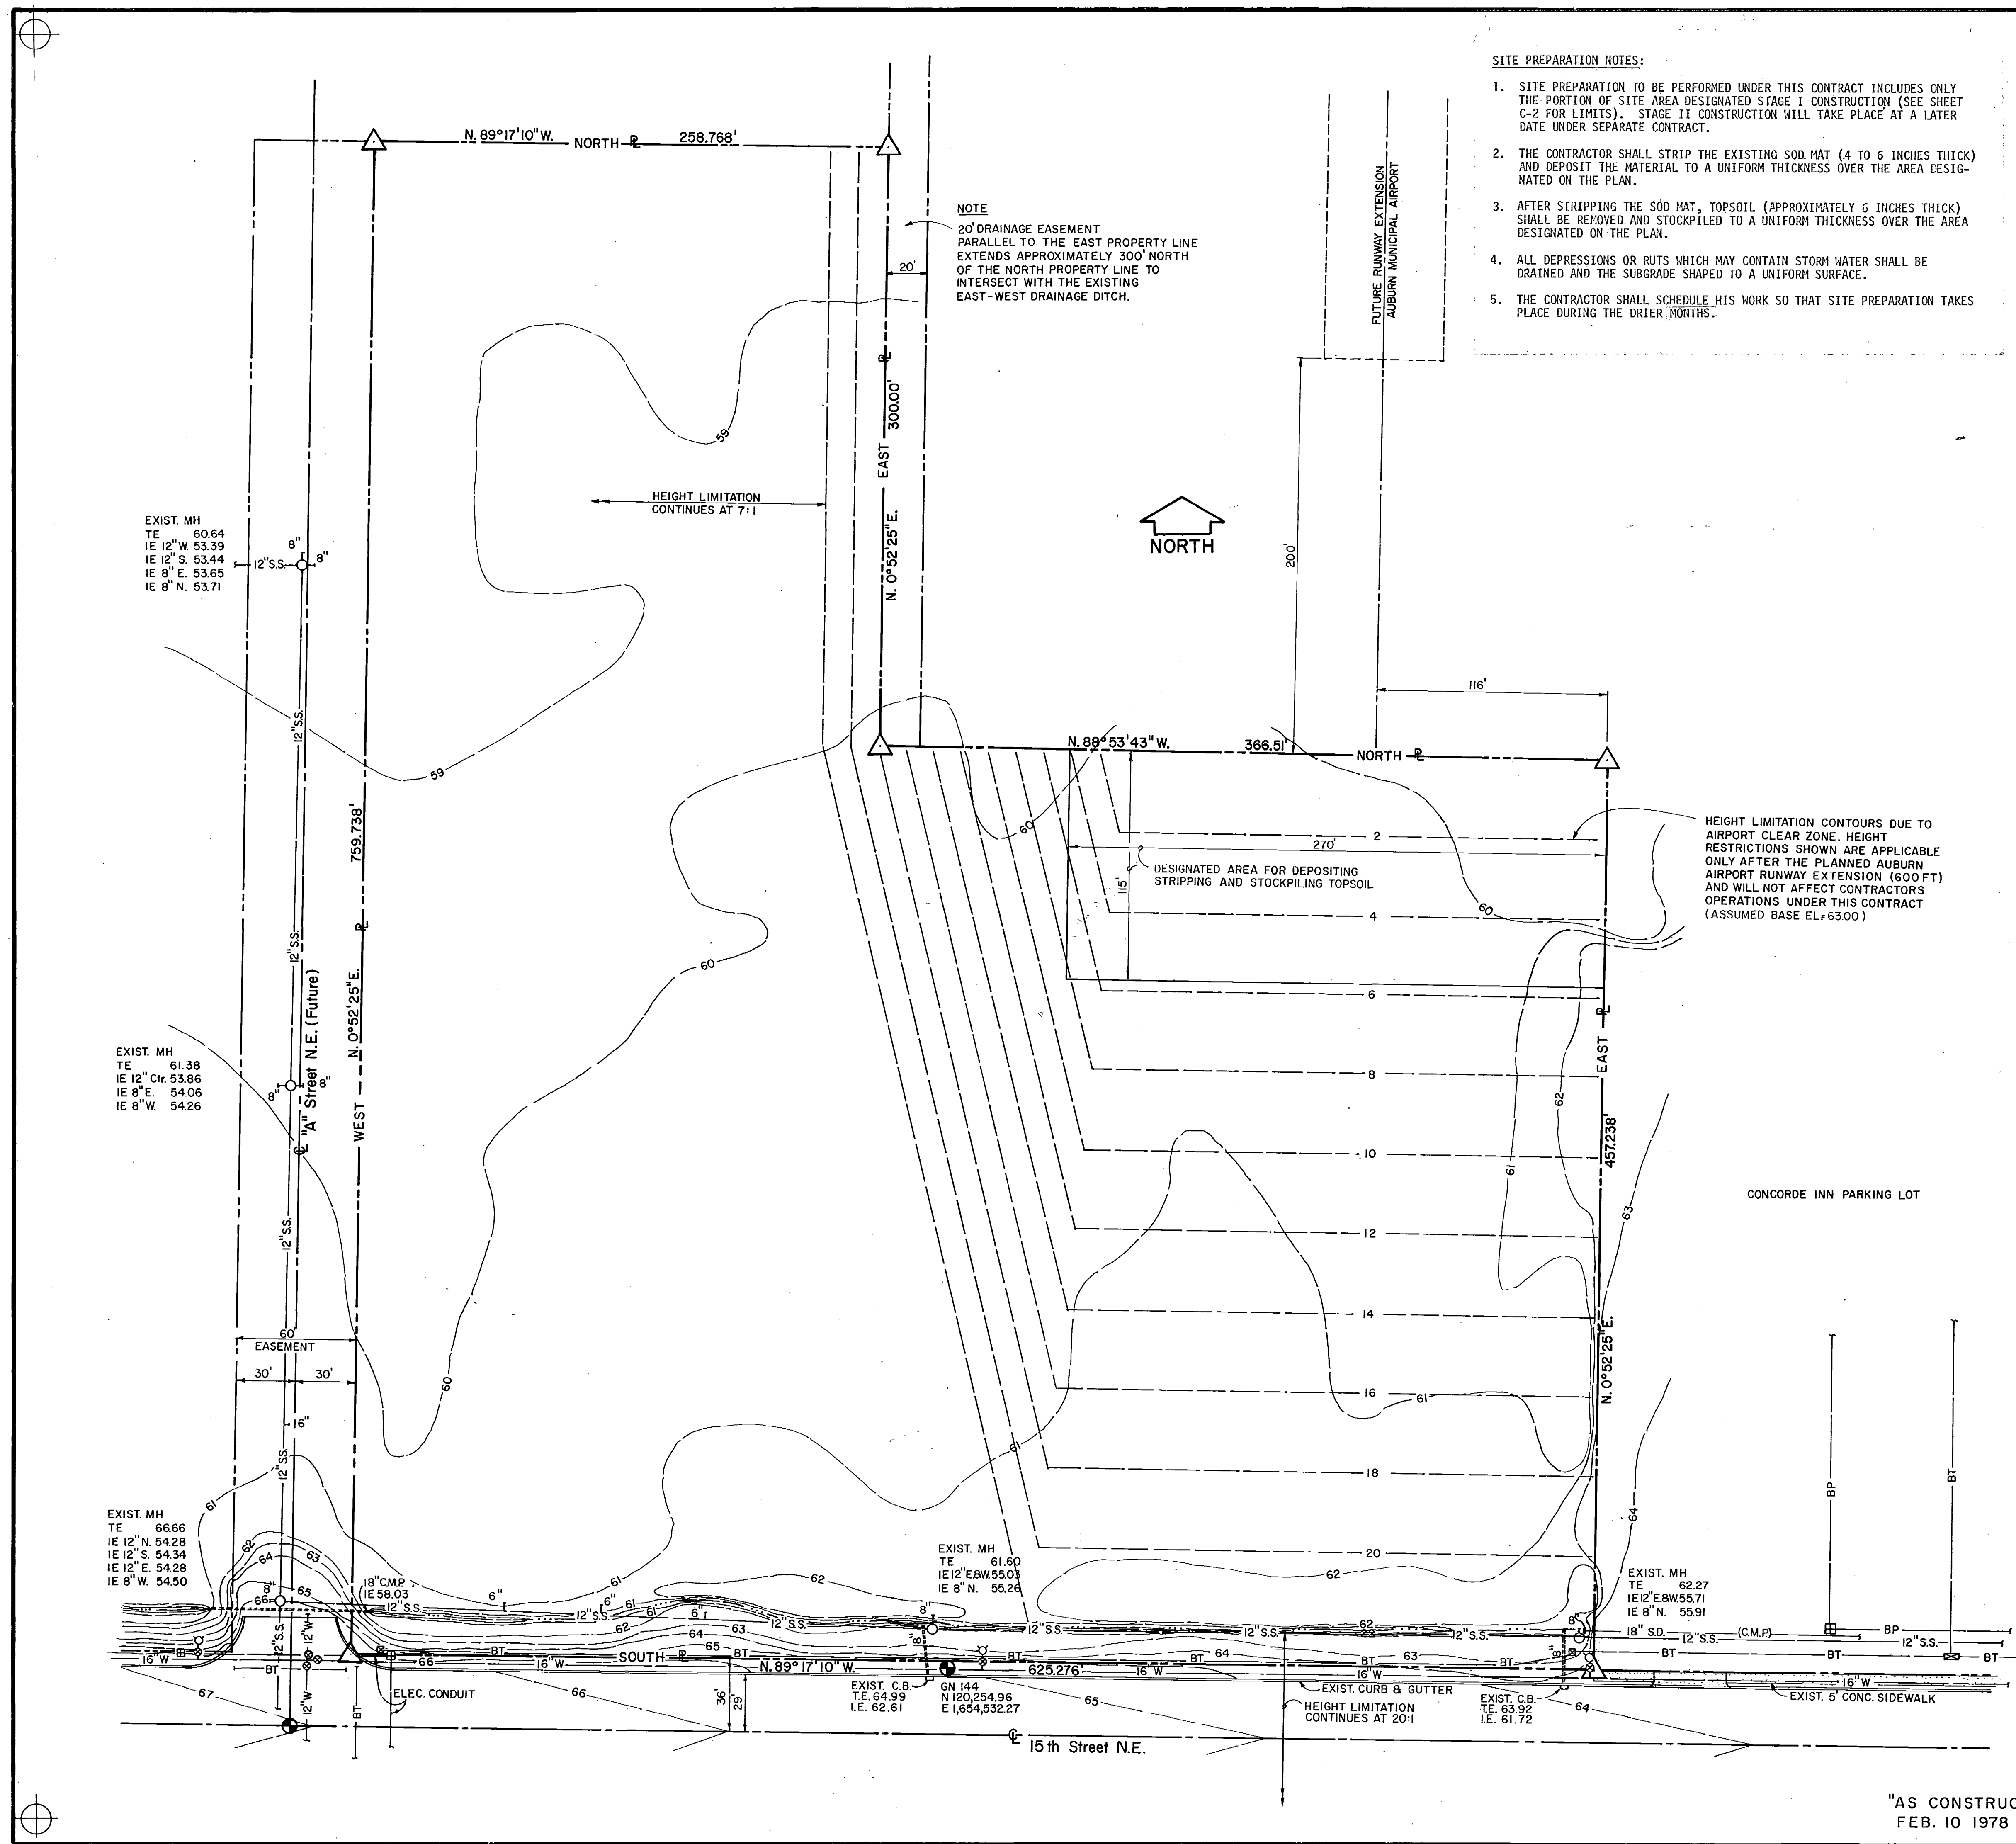


- SITE PREPARATION NOTES:**
1. SITE PREPARATION TO BE PERFORMED UNDER THIS CONTRACT INCLUDES ONLY THE PORTION OF SITE AREA DESIGNATED STAGE I CONSTRUCTION (SEE SHEET C-2 FOR LIMITS). STAGE II CONSTRUCTION WILL TAKE PLACE AT A LATER DATE UNDER SEPARATE CONTRACT.
 2. THE CONTRACTOR SHALL STRIP THE EXISTING SOD MAT (4 TO 6 INCHES THICK) AND DEPOSIT THE MATERIAL TO A UNIFORM THICKNESS OVER THE AREA DESIGNATED ON THE PLAN.
 3. AFTER STRIPPING THE SOD MAT, TOPSOIL (APPROXIMATELY 6 INCHES THICK) SHALL BE REMOVED AND STOCKPILED TO A UNIFORM THICKNESS OVER THE AREA DESIGNATED ON THE PLAN.
 4. ALL DEPRESSIONS OR RUTS WHICH MAY CONTAIN STORM WATER SHALL BE DRAINED AND THE SUBGRADE SHAPED TO A UNIFORM SURFACE.
 5. THE CONTRACTOR SHALL SCHEDULE HIS WORK SO THAT SITE PREPARATION TAKES PLACE DURING THE DRIER MONTHS.

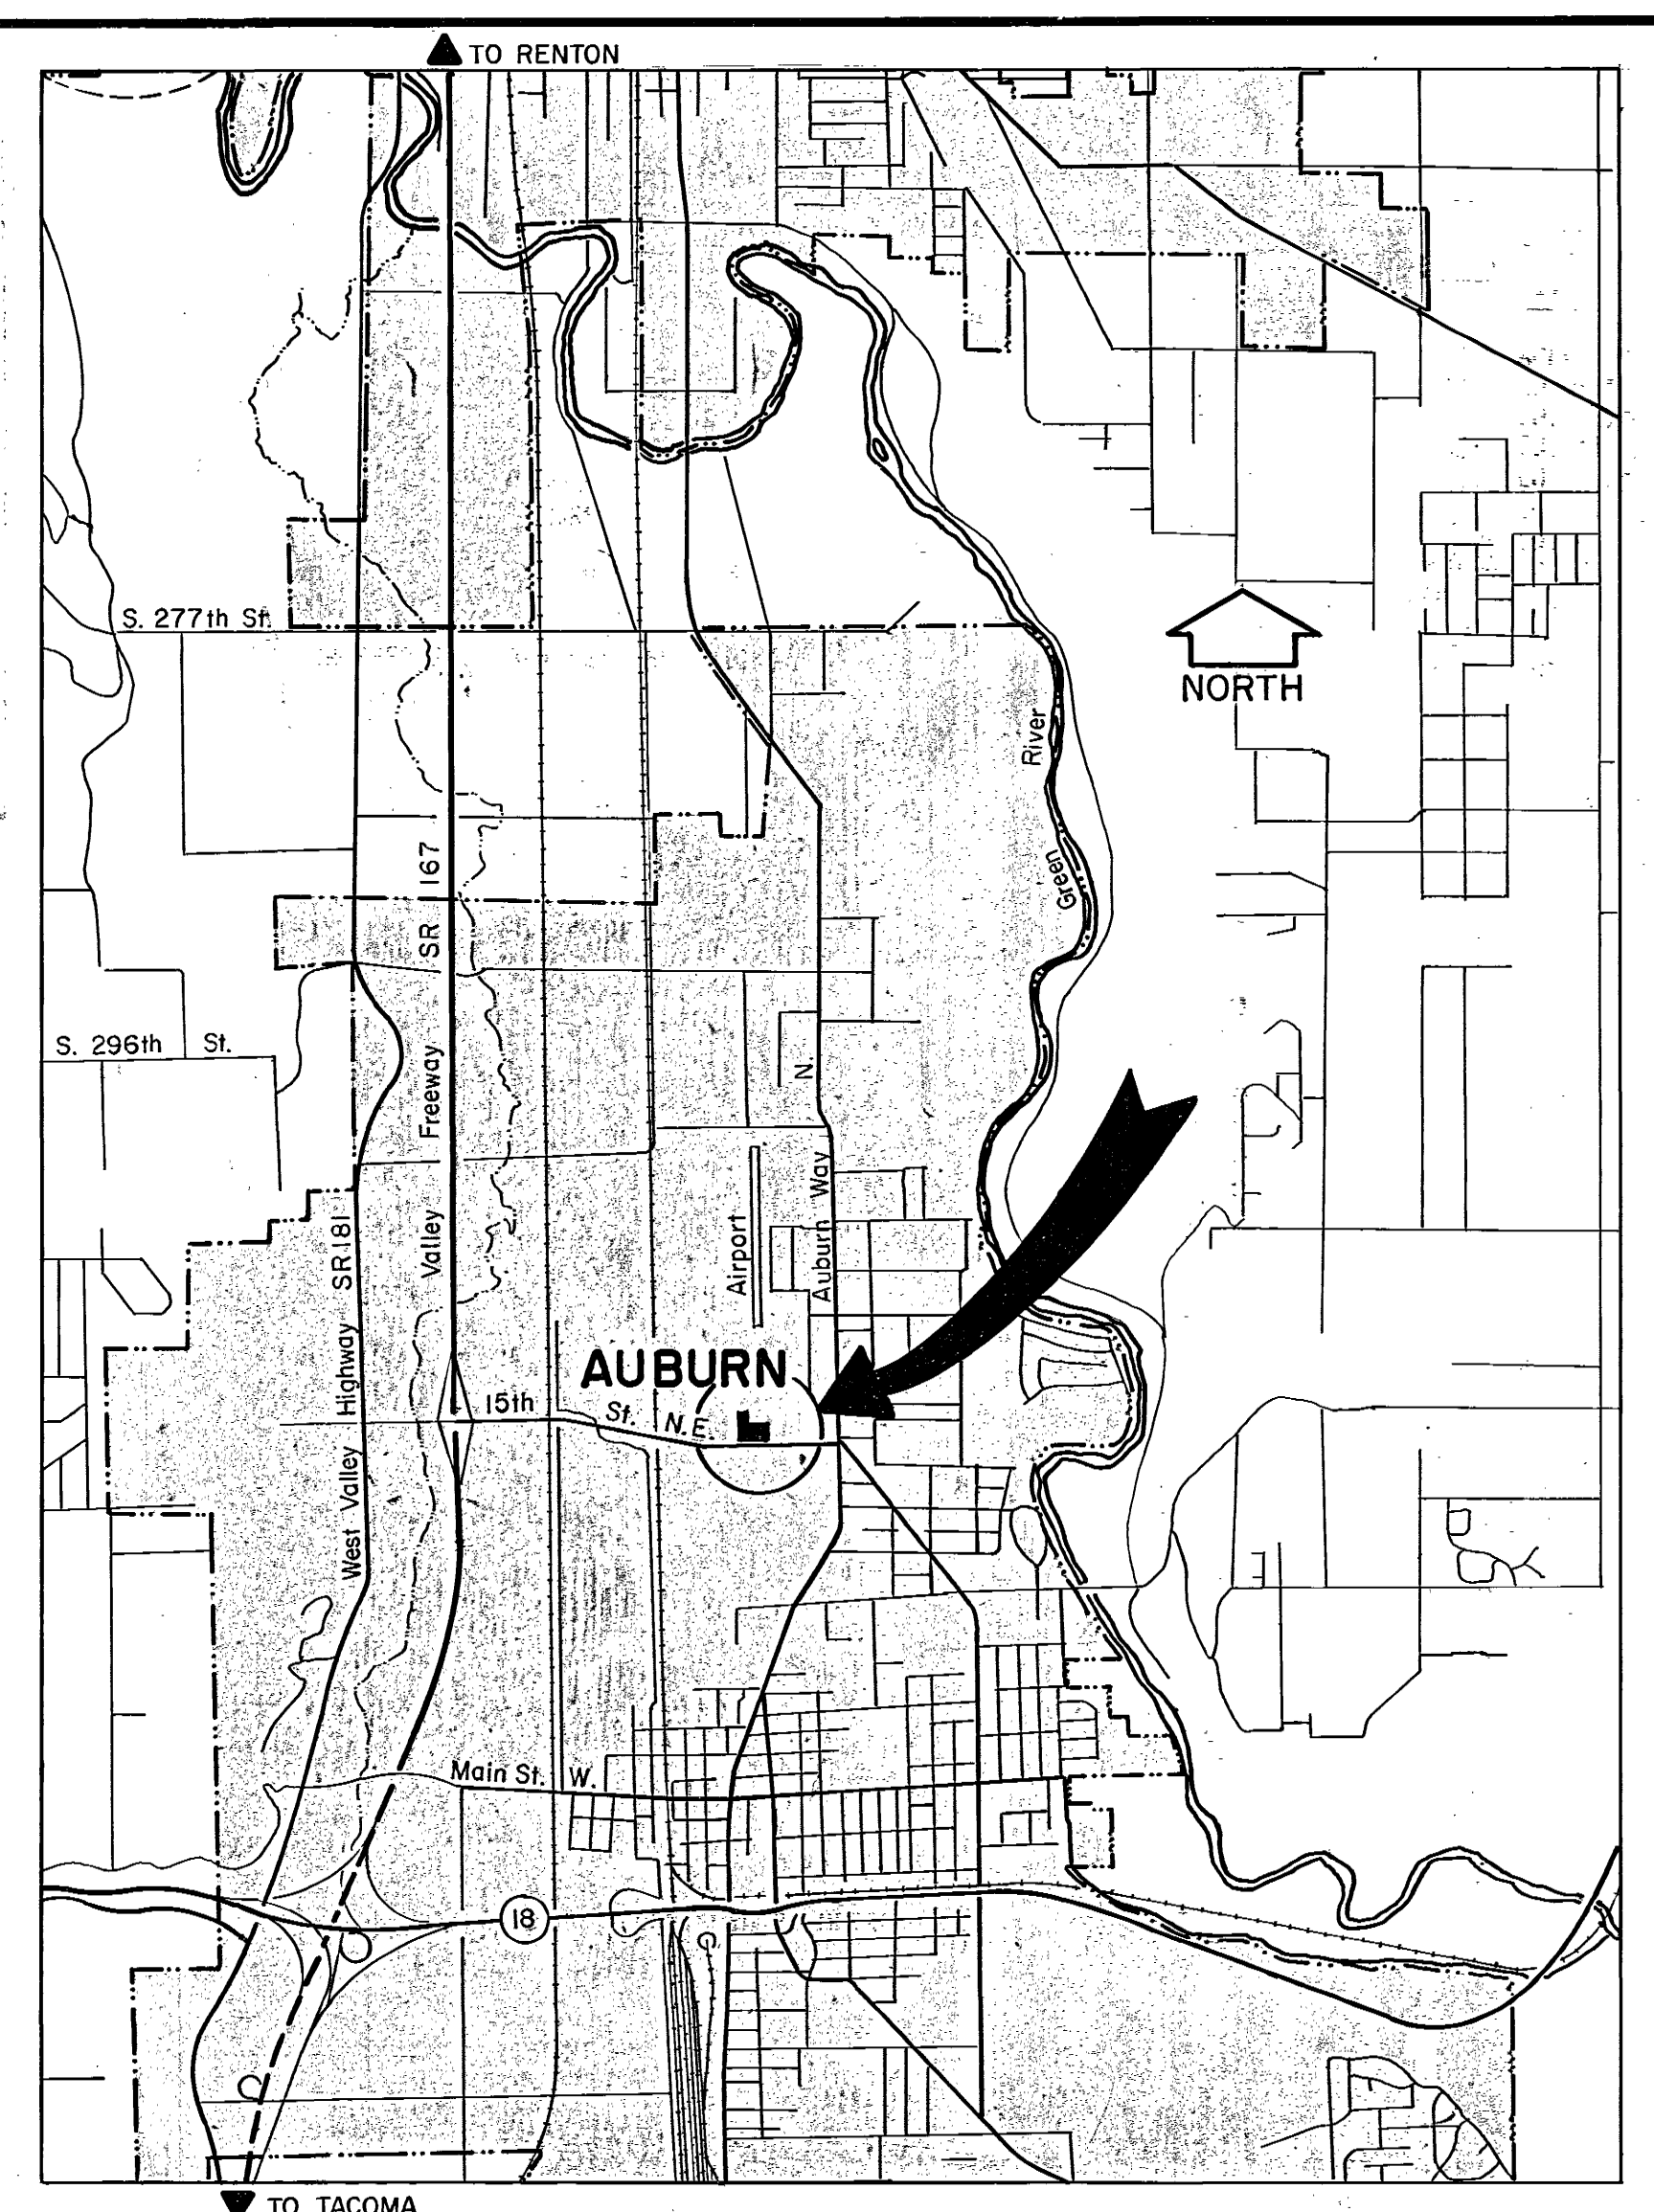

VICINITY MAP
SCALE: 1" = 2500'

LEGEND


- PROPERTY LINE
- CENTERLINE OF ROADWAY
- △ PROPERTY CORNER
- MONUMENT
- 12" S.S. SANITARY SEWER
- 12" S.D. STORM DRAIN
- 8" W. WATER LINE
- BT BURIED TELEPHONE
- BP BURIED POWER
- MANHOLE
- FIRE HYDRANT
- WATER VALVE
- CATCH BASIN
- POWER VAULT
- TELEPHONE VAULT
- CULVERT
- TE TOP ELEVATION
- IE INVERT ELEVATION
- 62 CONTOUR ELEVATION

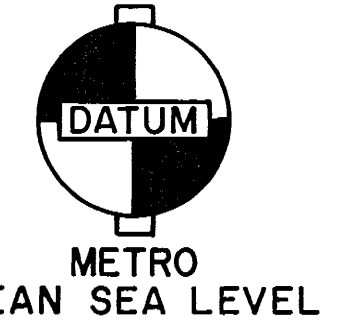

SCALE: 1" = 40'



MUNICIPALITY OF METROPOLITAN SEATTLE — TRANSIT DIVISION AUBURN PARK-AND-RIDE FACILITY EXISTING SITE DATA				111190
VICTOR O. GRAY & COMPANY, INC. CONSULTING ENGINEERS & PLANNERS RICHARD HAAG & ASSOCIATES LANDSCAPE ARCHITECTS JD 21 — LIGHTING ENGINEERS		Date 9/76 File No. 7605 Sheet 1 of 27	C-1 Sheet Number	
R. F. H. Designed A. O. K. Drawn	6/76 Date 6/76 Date	Municipality of Metropolitan Seattle Approved Date	Date 12/29/76	

"AS CONSTRUCTED"
FEB. 10 1978

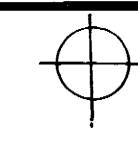

GRADING PLAN NOTES


1. EXISTING SITE DATA SHOWN HALF TONE.
2. SEE SHEET C-2 FOR DIMENSIONS NOT SHOWN.
3. ELEVATIONS AND CONTOURS SHOWN DESIGNATE FINISH GRADE (TOP OF PAVEMENT).
4. PAVING TO BE PERFORMED UNDER THIS CONTRACT INCLUDES ONLY THE PORTION DESIGNATED STAGE I CONSTRUCTION. STAGE II CONSTRUCTION WILL TAKE PLACE AT A LATER DATE UNDER SEPARATE CONTRACT.
5. SEE SHEETS NO. C-2, C-9, AND C-10 FOR GROUND LINE TREATMENT IN AREAS NOT PAVED.
6. CONTOUR INTERVAL = 0.20 FT.
7. SEE SHEET C-7 FOR SITE PROFILES.

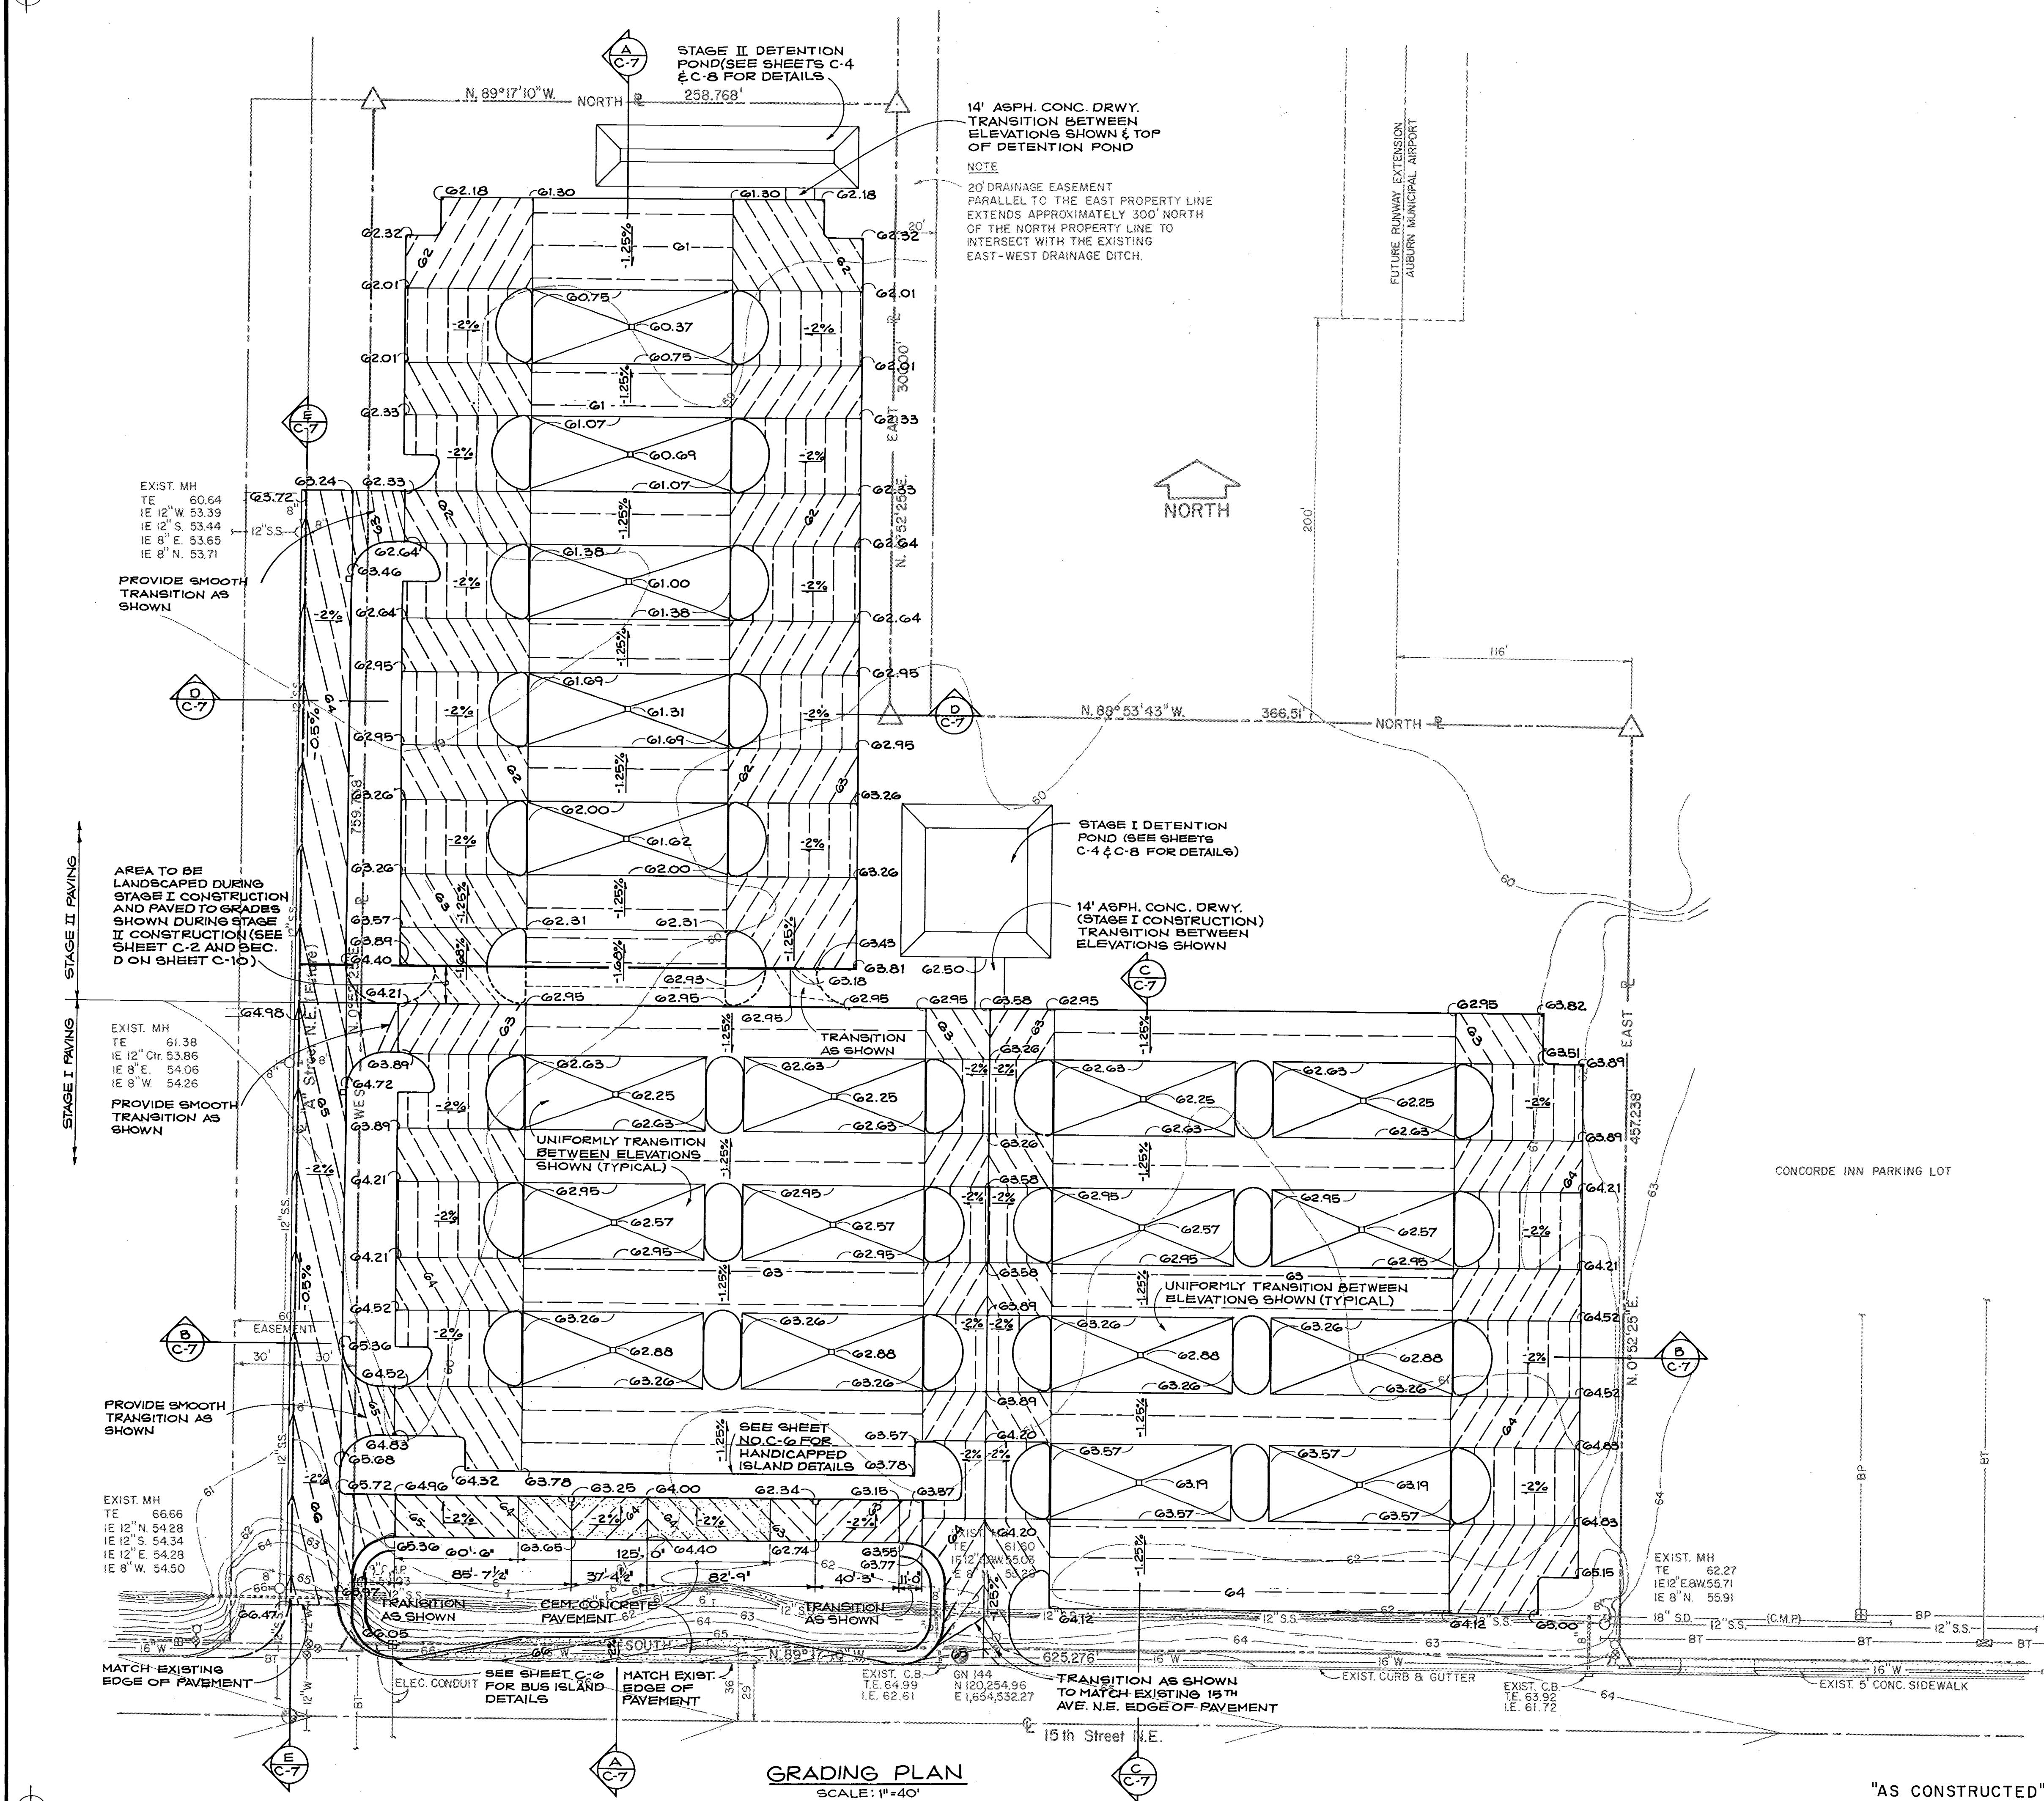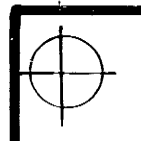

"AS CONSTRUCTED"
FEB. 10 1978

MUNICIPALITY OF METROPOLITAN SEATTLE — TRANSIT DIVISION	
AUBURN PARK-AND-RIDE FACILITY	
GRADING PLAN	
111192	
VICTOR O. GRAY & COMPANY, INC.	
CONSULTING ENGINEERS & PLANNERS	
RICHARD HAAG & ASSOCIATES	
LANDSCAPE ARCHITECTS	
JD 21 — LIGHTING ENGINEERS	
Date	9/76
File No.	7605
Sheet	3 of 27
C-3	
Sheet Number	

R. F. H.	6/76	Municipality of
Designed	Date	Metropolitan Seattle
A. O. K.	6/76	Approved
Drawn	Date	10/19/76

 


UTILITIES NOTES

- EXISTING SITE DATA SHOWN HALF TONE.
- DIMENSIONS SHOWN ARE PARALLEL OR PERPENDICULAR TO THE SITE'S SOUTHERN BOUNDARY AND THE CENTERLINE SOUTH ACCESS.
- UTILITIES WORK TO BE PERFORMED BY THE CONTRACTOR UNDER THIS CONTRACT INCLUDES ONLY THE PORTION DESIGNATED "STAGE I UTILITIES" ON THE "UTILITIES PLAN." STAGE II CONSTRUCTION WILL TAKE PLACE AT A LATER DATE UNDER SEPARATE CONTRACT.
- SEE SHEET NO. C-6 FOR SANITARY SEWER AND WATER CONNECTIONS. SEE "LANDSCAPING PLANS" FOR IRRIGATION SYSTEM.
- ALL STORM DRAIN PIPES (S.D.) AND SANITARY SEWER PIPES (S.S.) SHALL BE CONCRETE. ALL CONCRETE PIPES 12 INCHES DIAMETER OR LARGER SHALL BE ASTM C 76-73 CLASS II. ALL CONCRETE PIPES LESS THAN 12 INCHES DIAMETER SHALL BE ASTM C 14-73 CLASS 2.
- PIPE BEDDING SHALL BE CLASS B AND CONFORM TO STANDARD PLAN NO. 62 OF THE "STANDARD SPECIFICATIONS FOR MUNICIPAL PUBLIC WORKS CONSTRUCTION" DATED 1975.
- CATCH BASINS NO. 8, 12, AND 22 SHALL BE TYPE II-A (STD. PLAN NO. 53), TYPE II-B (STD. PLAN NO. 54) OR TYPE II-C (STD. PLAN NO. 55) AS DETAILED IN THE STANDARD SPECIFICATIONS FOR PUBLIC WORKS CONSTRUCTION. ALL OTHER CATCH BASINS SHALL BE TYPE I-A (STANDARD PLAN NO. 50) TYPE I-B (STANDARD PLAN NO. 51) OR TYPE I-C (STANDARD PLAN NO. 52).
- OUTLET TRAPS TO BE PROVIDED AT CATCH BASINS NO. 8, 12 & 22 IN ACCORDANCE WITH STANDARD PLAN NO. 60 AS DETAILED IN STANDARD SPECIFICATIONS FOR PUBLIC WORKS CONSTRUCTION.
- THE CONTRACTOR SHALL FURNISH AND INSTALL 3M BRAND (OR APPROVED EQUAL) TYPE 240 OIL SORBENT PILLOWS IN CATCH BASINS NO. 8, 12, AND 22.
- ALL CATCH BASINS SHALL BE PROVIDED WITH METAL FRAMES AND GRATES IN ACCORDANCE WITH STANDARD PLAN NO. 49 AS DETAILED IN THE STANDARD SPECIFICATIONS FOR PUBLIC WORKS CONSTRUCTION.
- MANHOLE NO. 6 SHALL BE TYPE III-54 IN ACCORDANCE WITH STANDARD PLAN NO. 37 AS DETAILED IN THE STANDARD SPECIFICATIONS FOR PUBLIC WORKS CONSTRUCTION. ALL OTHER MANHOLES SHALL BE TYPE III-48 IN ACCORDANCE WITH STANDARD PLAN NO. 37.

THE FOLLOWING MODIFICATIONS ARE REQUIRED FOR MANHOLES NO. 5 AND 7 (OVERFLOW MANHOLES):


- SUBSTITUTE THE UNIT P PRECAST COVER SHOWN ON STANDARD PLAN NO. 56 FOR THE FLAT SLAB COVER SPECIFIED ON STANDARD PLAN NO. 37.
 - CONSTRUCTION ABOVE THE PRECAST COVER SHALL BE AS DETAILED ON SHEET C-8.
- MANHOLES NO. 5 AND 7 SHALL BE PROVIDED WITH METAL FRAMES AND GRATES IN ACCORDANCE WITH STANDARD PLAN NO. 49 AS DETAILED IN THE STANDARD SPECIFICATIONS FOR PUBLIC WORKS CONSTRUCTION. ALL OTHER MANHOLES SHALL BE PROVIDED WITH FRAMES AND COVERS IN ACCORDANCE WITH STANDARD PLAN NO. 42.
 - MONUMENT FRAME AND COVER SHALL BE IN ACCORDANCE WITH STANDARD PLAN NO. 19 AS DETAILED IN THE STANDARD SPECIFICATIONS FOR PUBLIC WORKS CONSTRUCTION. THE CONTRACTOR SHALL SCHEDULE FRAME AND COVER INSTALLATION WITH THE CITY OF AUBURN TO ALLOW CITY INSPECTION OF WORK.

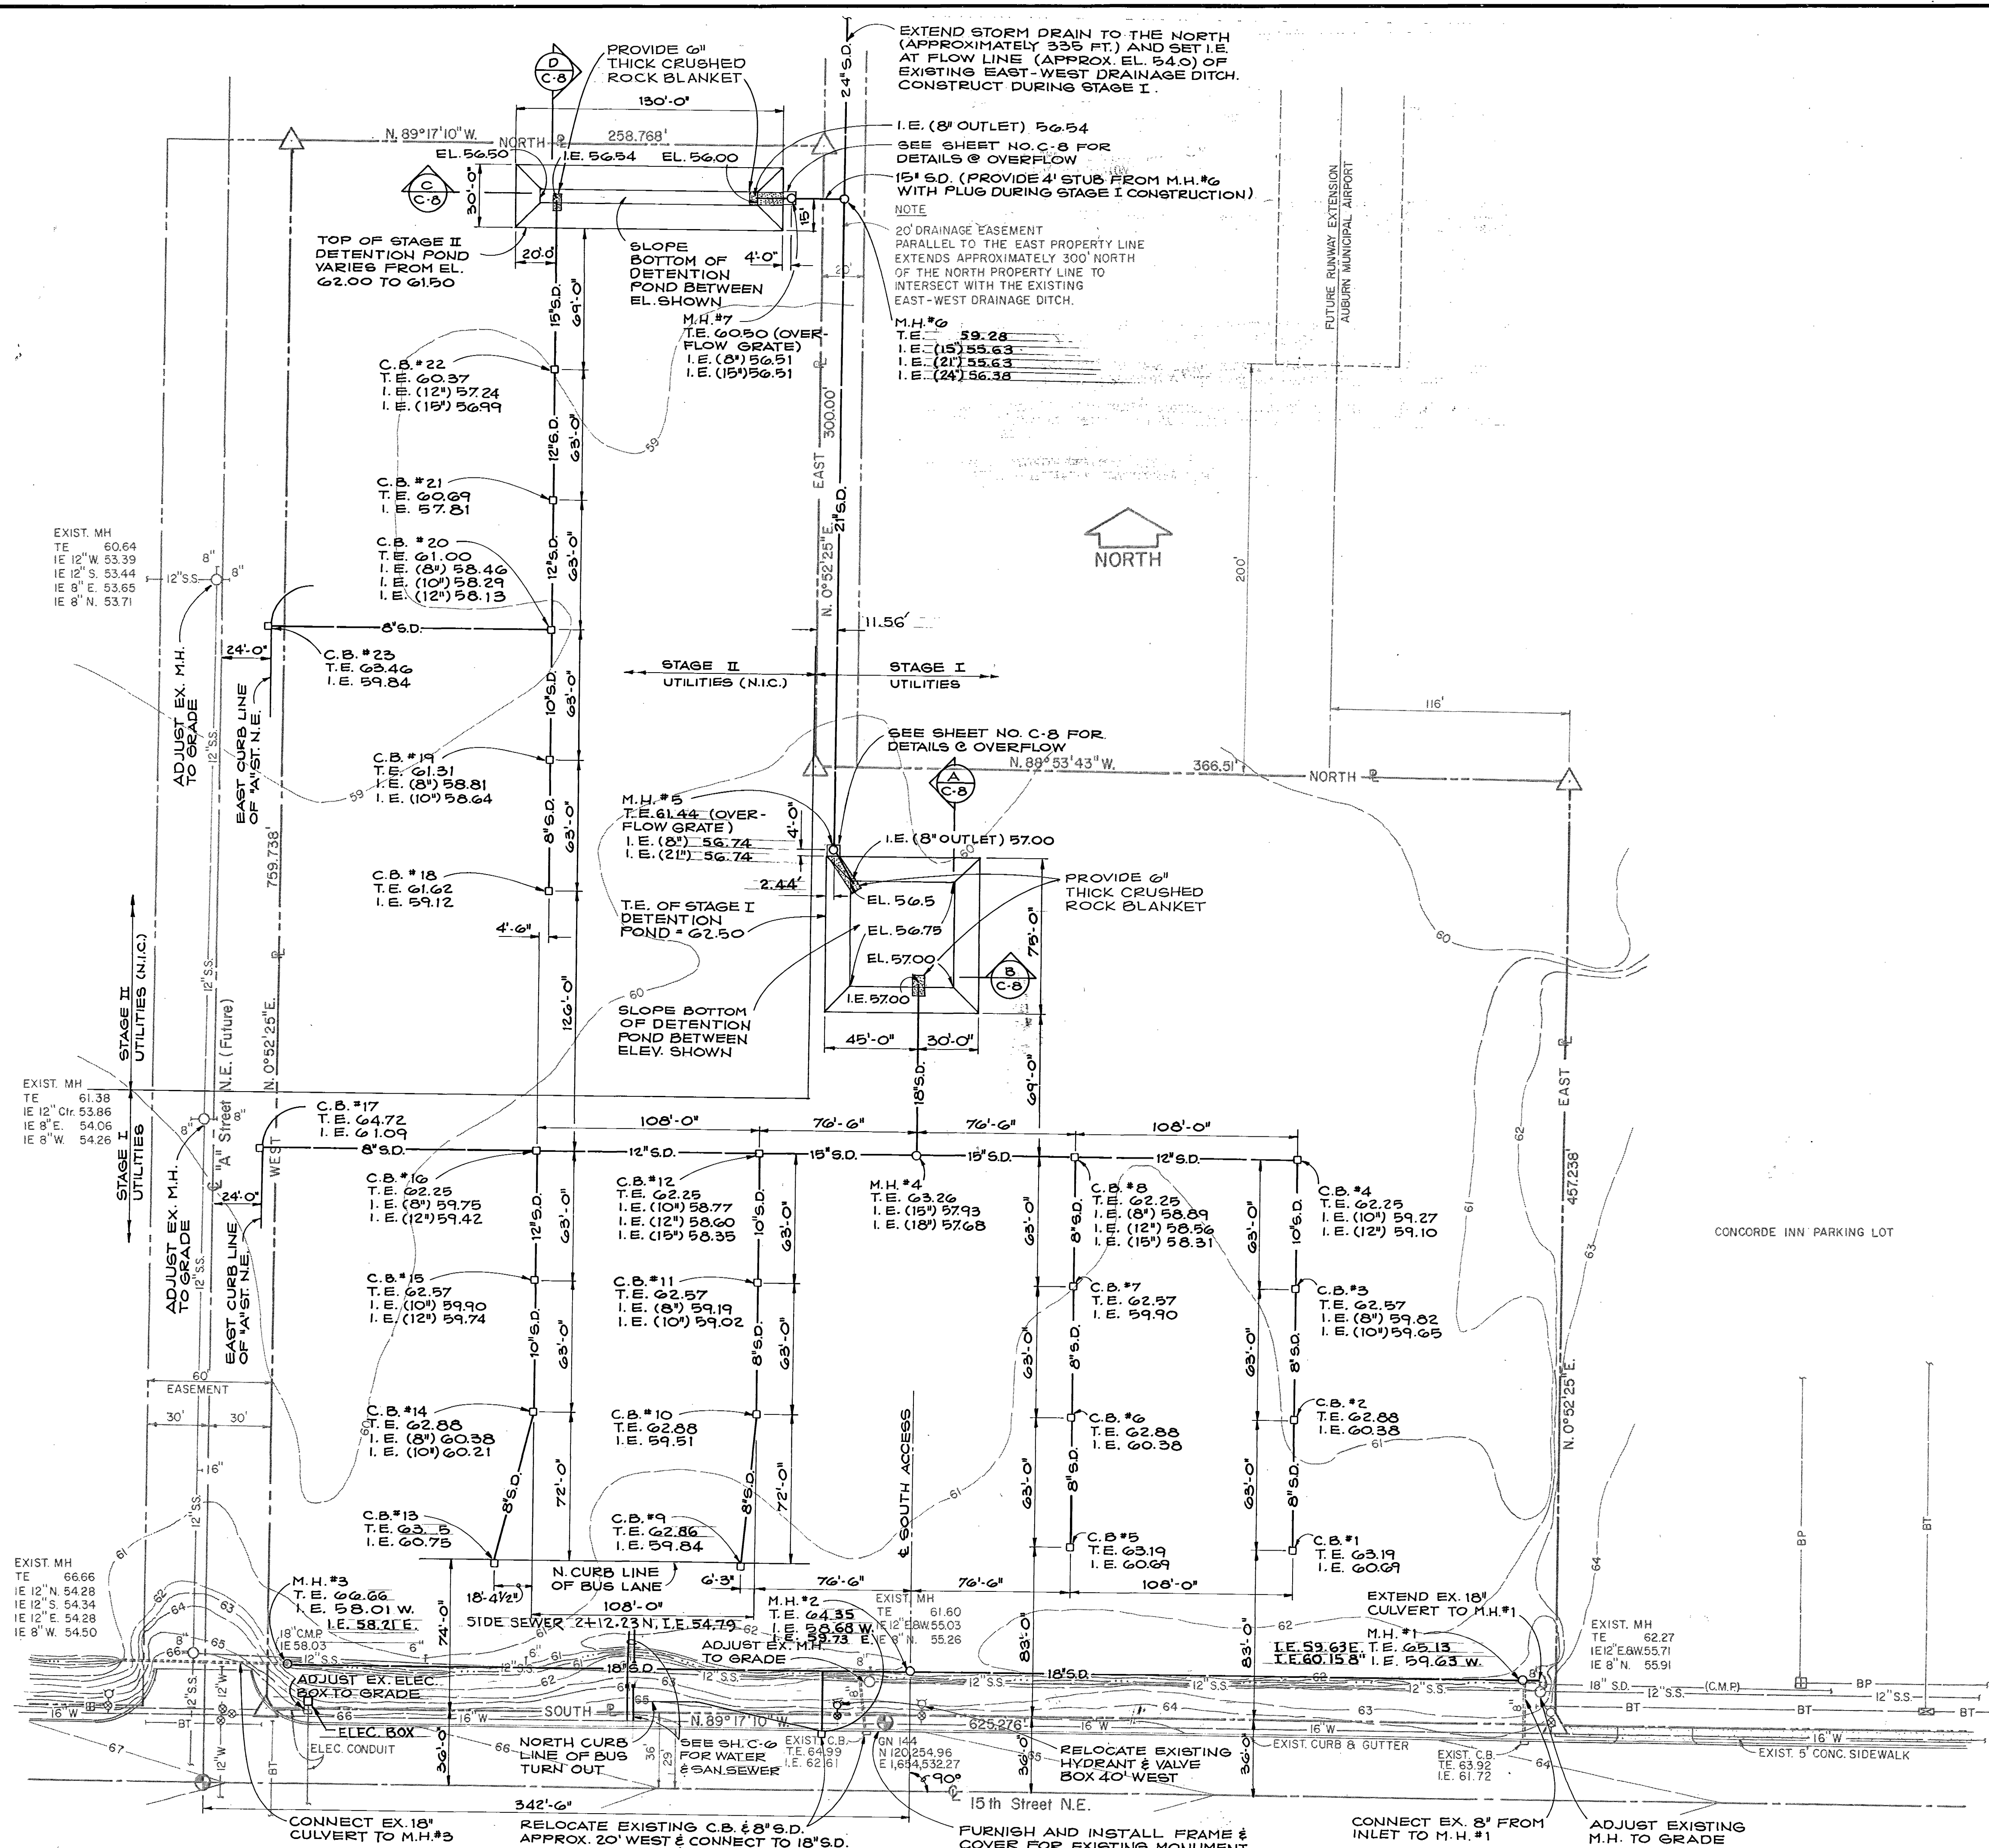

UTILITIES PLAN
SCALE: 1" = 40'

"AS CONSTRUCTED"
FEB. 16, 1978

MUNICIPALITY OF METROPOLITAN SEATTLE — TRANSIT DIVISION AUBURN PARK-AND-RIDE FACILITY UTILITIES PLAN 111193

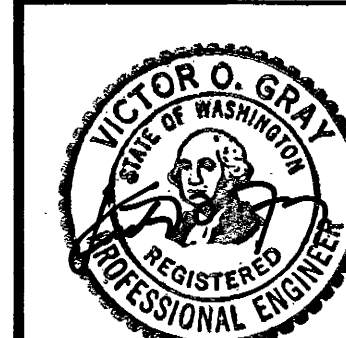

VICTOR O. GRAY & COMPANY, INC.
CONSULTING ENGINEERS & PLANNERS
RICHARD HAAG & ASSOCIATES
LANDSCAPE ARCHITECTS
JD 21 — LIGHTING ENGINEERS


R.F.H. 6/76
Designed Date
A.O.K. 6/76
Drawn Date

Municipality of
Metropolitan Seattle
Approved Date
J.M. Malley 12/29/76


Date 9/76
File No. 7605
Sheet 4 of 27
C-4
Sheet Number

SIGNING AND STRIPING NOTES


1. SITE LAYOUT SHOWN HALF TONE.
2. SIGNING AND STRIPING TO BE PERFORMED UNDER THIS CONTRACT INCLUDES ONLY THE PORTION DESIGNATED "STAGE I SIGNING AND STRIPING" ON THE PLAN. STAGE II CONSTRUCTION WILL TAKE PLACE AT A LATER DATE UNDER SEPARATE CONTRACT.
3. ALL PAVEMENT MARKINGS AND STRIPING SHALL BE PAINTED TO THE DIMENSIONS SHOWN WITH REFLECTORIZED WHITE TRAFFIC PAINT.
4. STOP SIGNS SHALL BE IN ACCORDANCE WITH STANDARD R-1 AS SHOWN IN THE WASHINGTON STATE HIGHWAY COMMISSION MANUAL FOR SIGNING. INSTALLATION SHALL BE IN ACCORDANCE WITH STANDARD PLAN G-13b AS DETAILED IN THE STATE OF WASHINGTON STANDARD PLANS FOR ROAD AND BRIDGE CONSTRUCTION (1974).
5. IDENTIFICATION SIGNS SHALL BE FURNISHED AND INSTALLED BY THE CONTRACTOR AT THE LOCATIONS SHOWN ON THE PLAN OR AS DIRECTED BY THE ENGINEER (SEE SHEET C-7 FOR DETAILS).
6. WELCOME SIGNS WILL BE FURNISHED BY METRO AND SHALL BE INSTALLED BY THE CONTRACTOR IN THE PASSENGER SHELTERS AS DIRECTED BY THE ENGINEER.
7. INFORMATION SIGNS WILL BE FURNISHED BY METRO AND SHALL BE INSTALLED BY THE CONTRACTOR AT THE LOCATIONS SHOWN ON THE PLAN OR AS DIRECTED BY THE ENGINEER.
8. IN ADDITION TO THE PERMANENT SIGNING CALLED FOR ON THIS SHEET, THE CONTRACTOR MUST FURNISH AND INSTALL TWO CONSTRUCTION SIGNS (SEE SECTION C1.07 OF THE SPECIFICATIONS).
9. STAGE I PARKING CAPACITY = 366
STAGE I PLUS STAGE II PARKING CAPACITY = 592

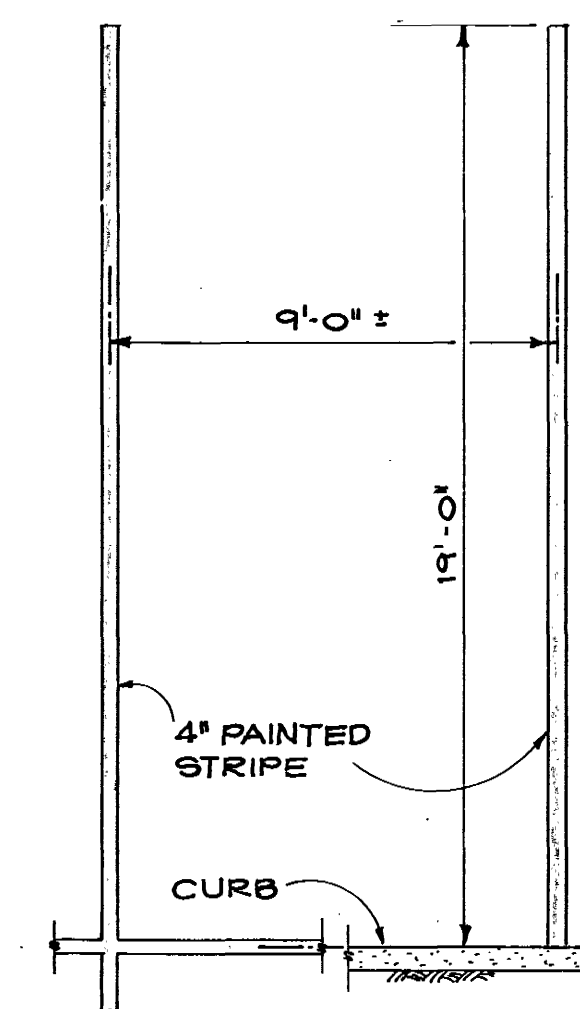


TYPICAL STALL STRIPING

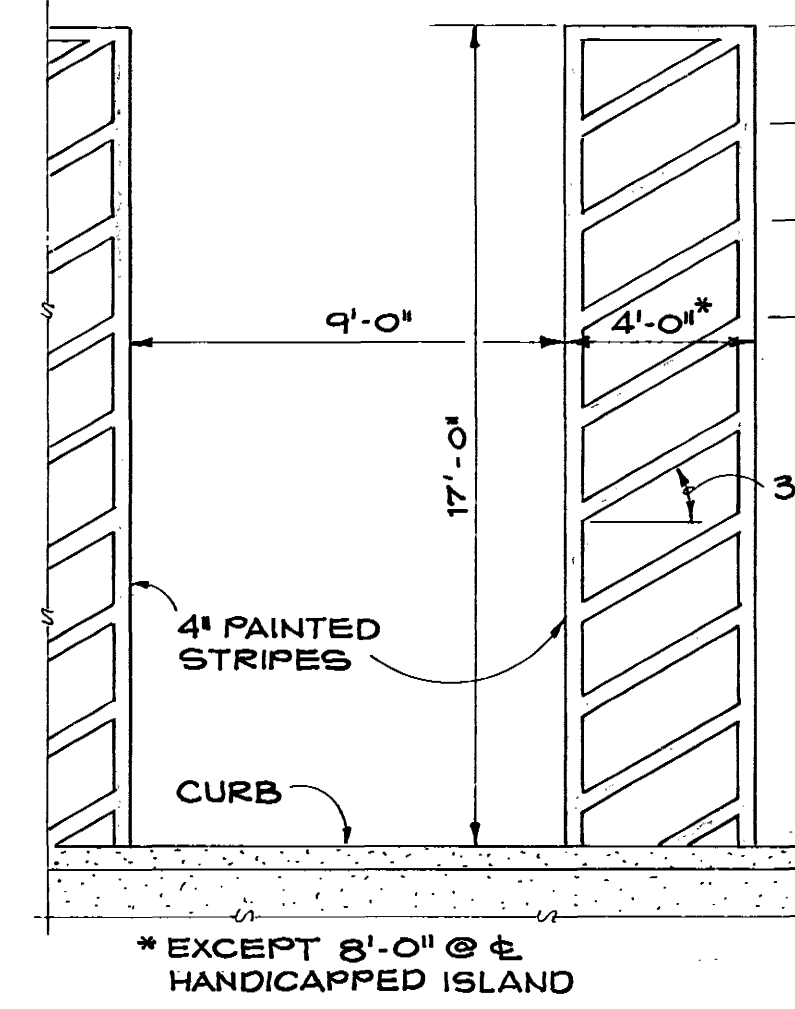DETAIL (A)
1/4" = 1'-0"


HANDICAPPED ISLAND STALL STRIPING

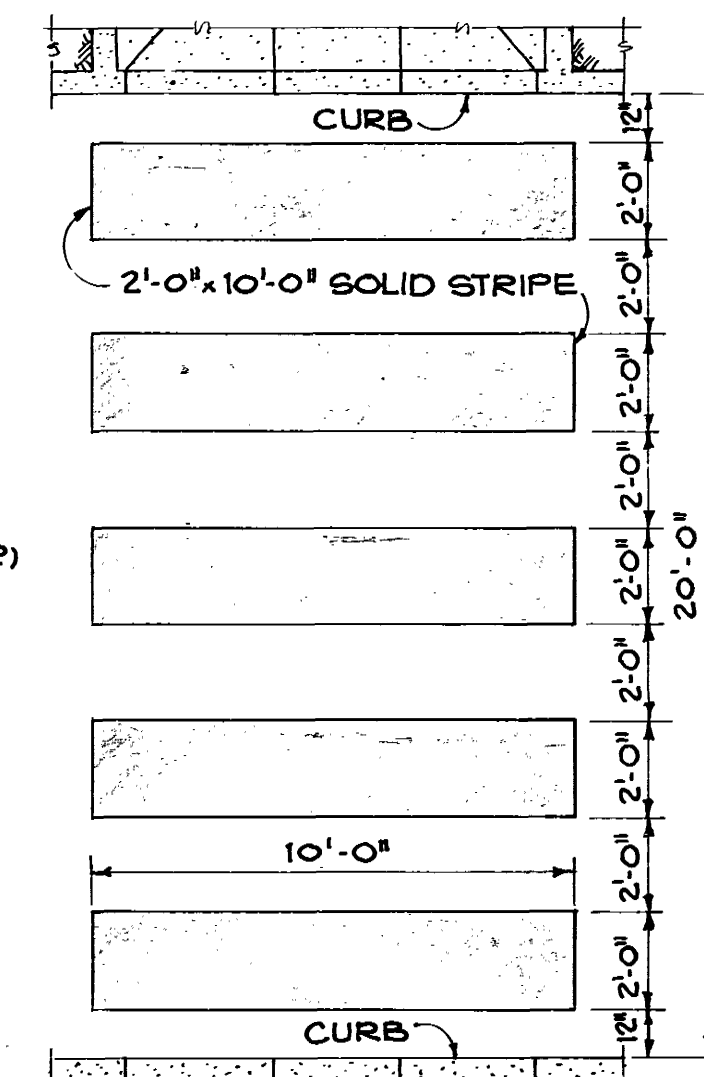DETAIL (B)
1/4" = 1'-0"


CROSSWALK STRIPING

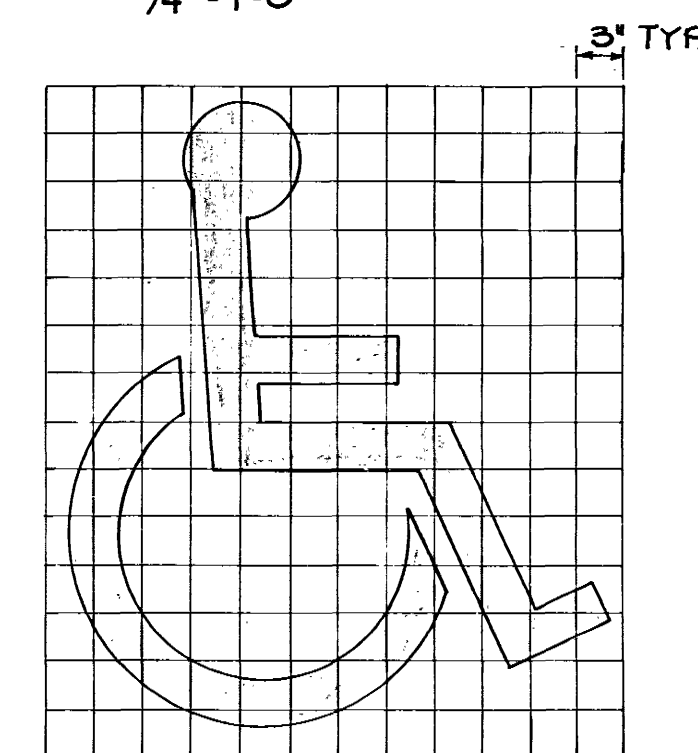DETAIL (C)
1/4" = 1'-0"

HANDICAPPED STALL MARKING

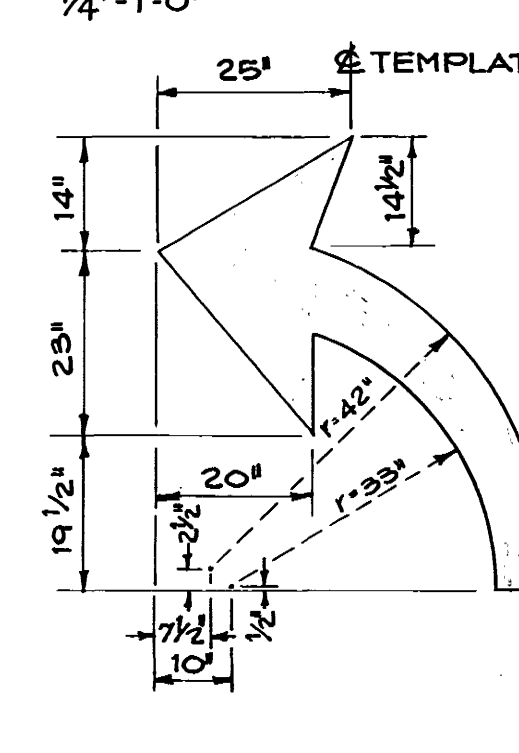DETAIL (D)
1" = 1'-0"

TRAFFIC ARROWS

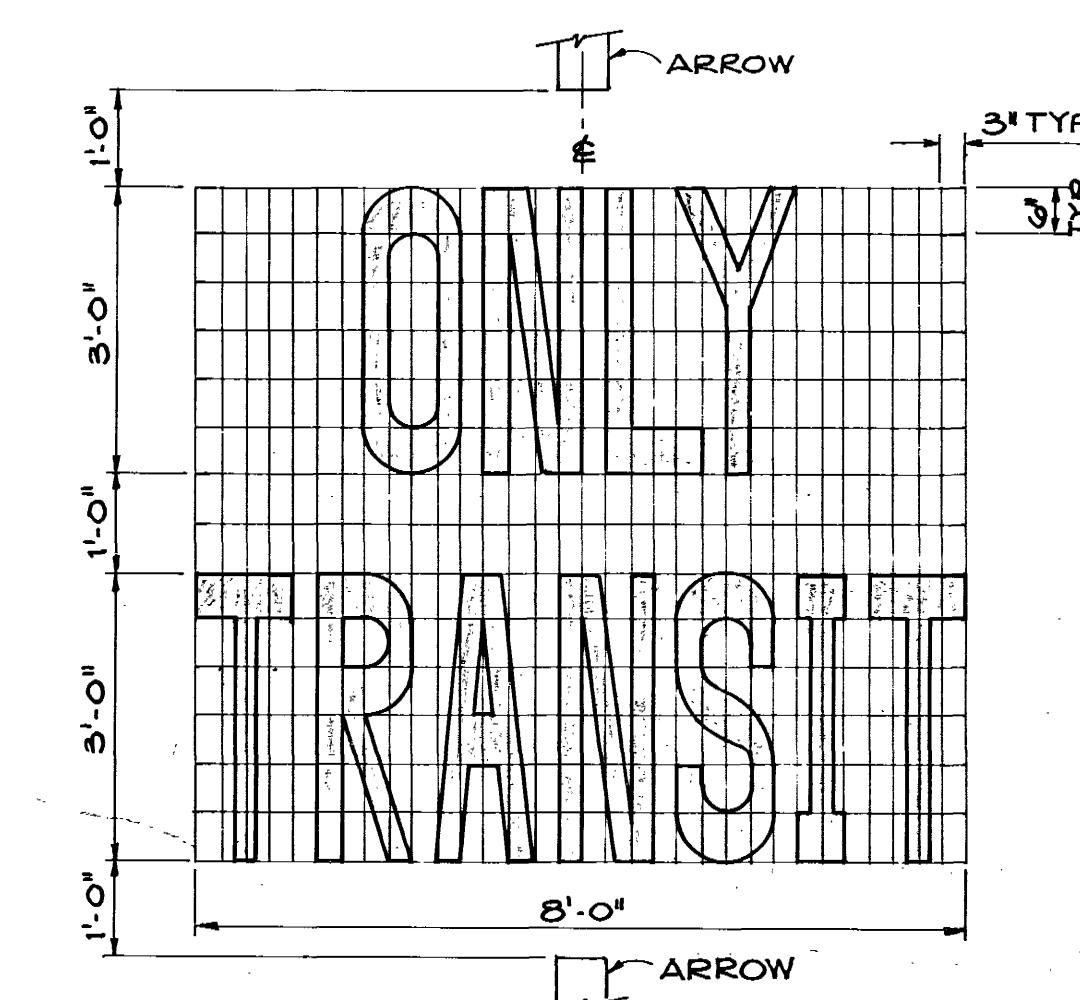DETAIL (E)
3/4" = 1'-0"

BUS LANE SIGN


DETAIL (F)
1/2" = 1'-0"

SIGNING & STRIPING PLAN

SCALE: 1" = 40'

"AS CONSTRUCTED"
FEB. 10 1978

111194

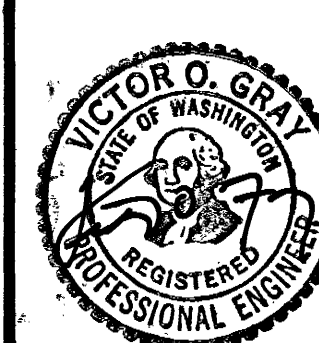MUNICIPALITY OF METROPOLITAN SEATTLE — TRANSIT DIVISION
AUBURN PARK-AND-RIDE FACILITY
SIGNING & STRIPING PLANVICTOR O. GRAY & COMPANY, INC.
CONSULTING ENGINEERS & PLANNERSRICHARD HAAG & ASSOCIATES
LANDSCAPE ARCHITECTS
JD 21 — LIGHTING ENGINEERS



R.F.H.	6/76	Municipality of Metropolitan Seattle
Designed	Date	
A.O.K.	6/76	
Drawn	Date	

Date 9/76

File No. 7605

Sheet 5 of 27

C-5
Sheet Number

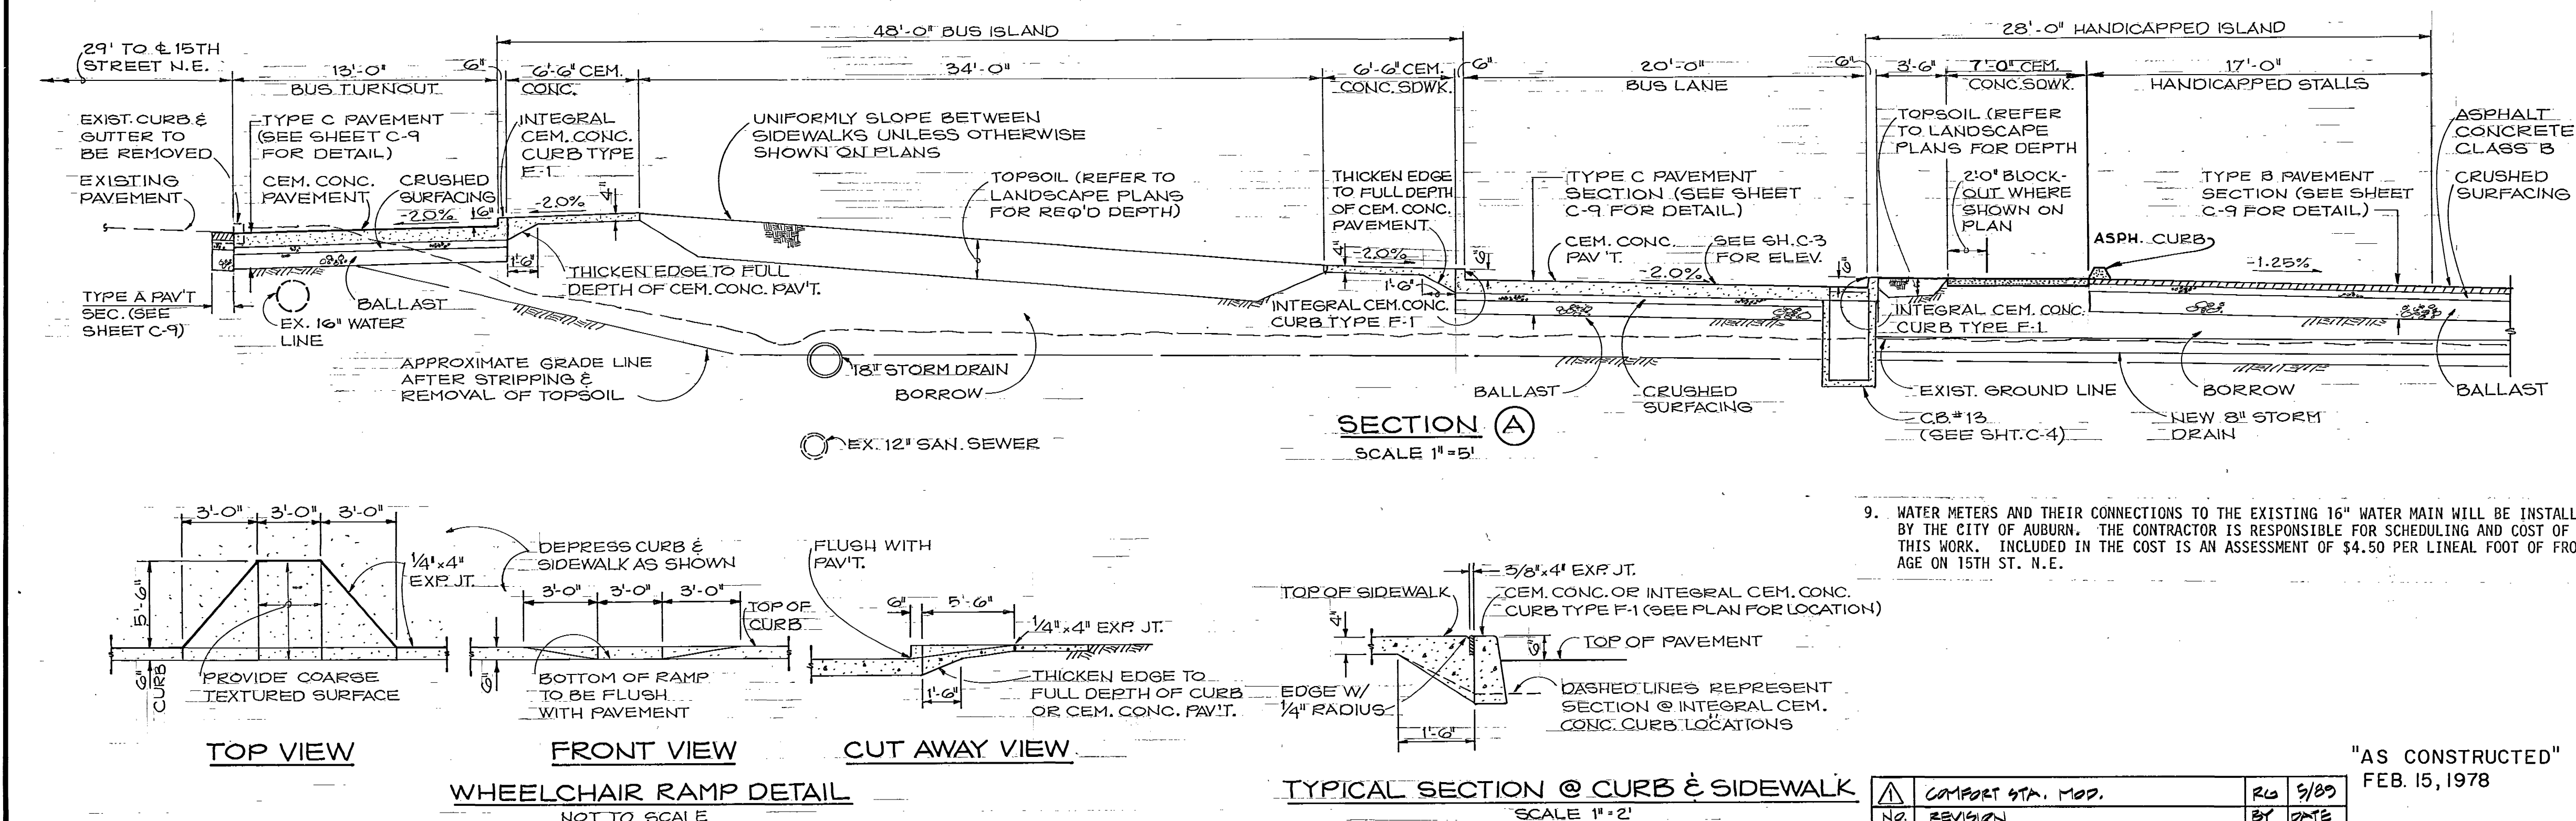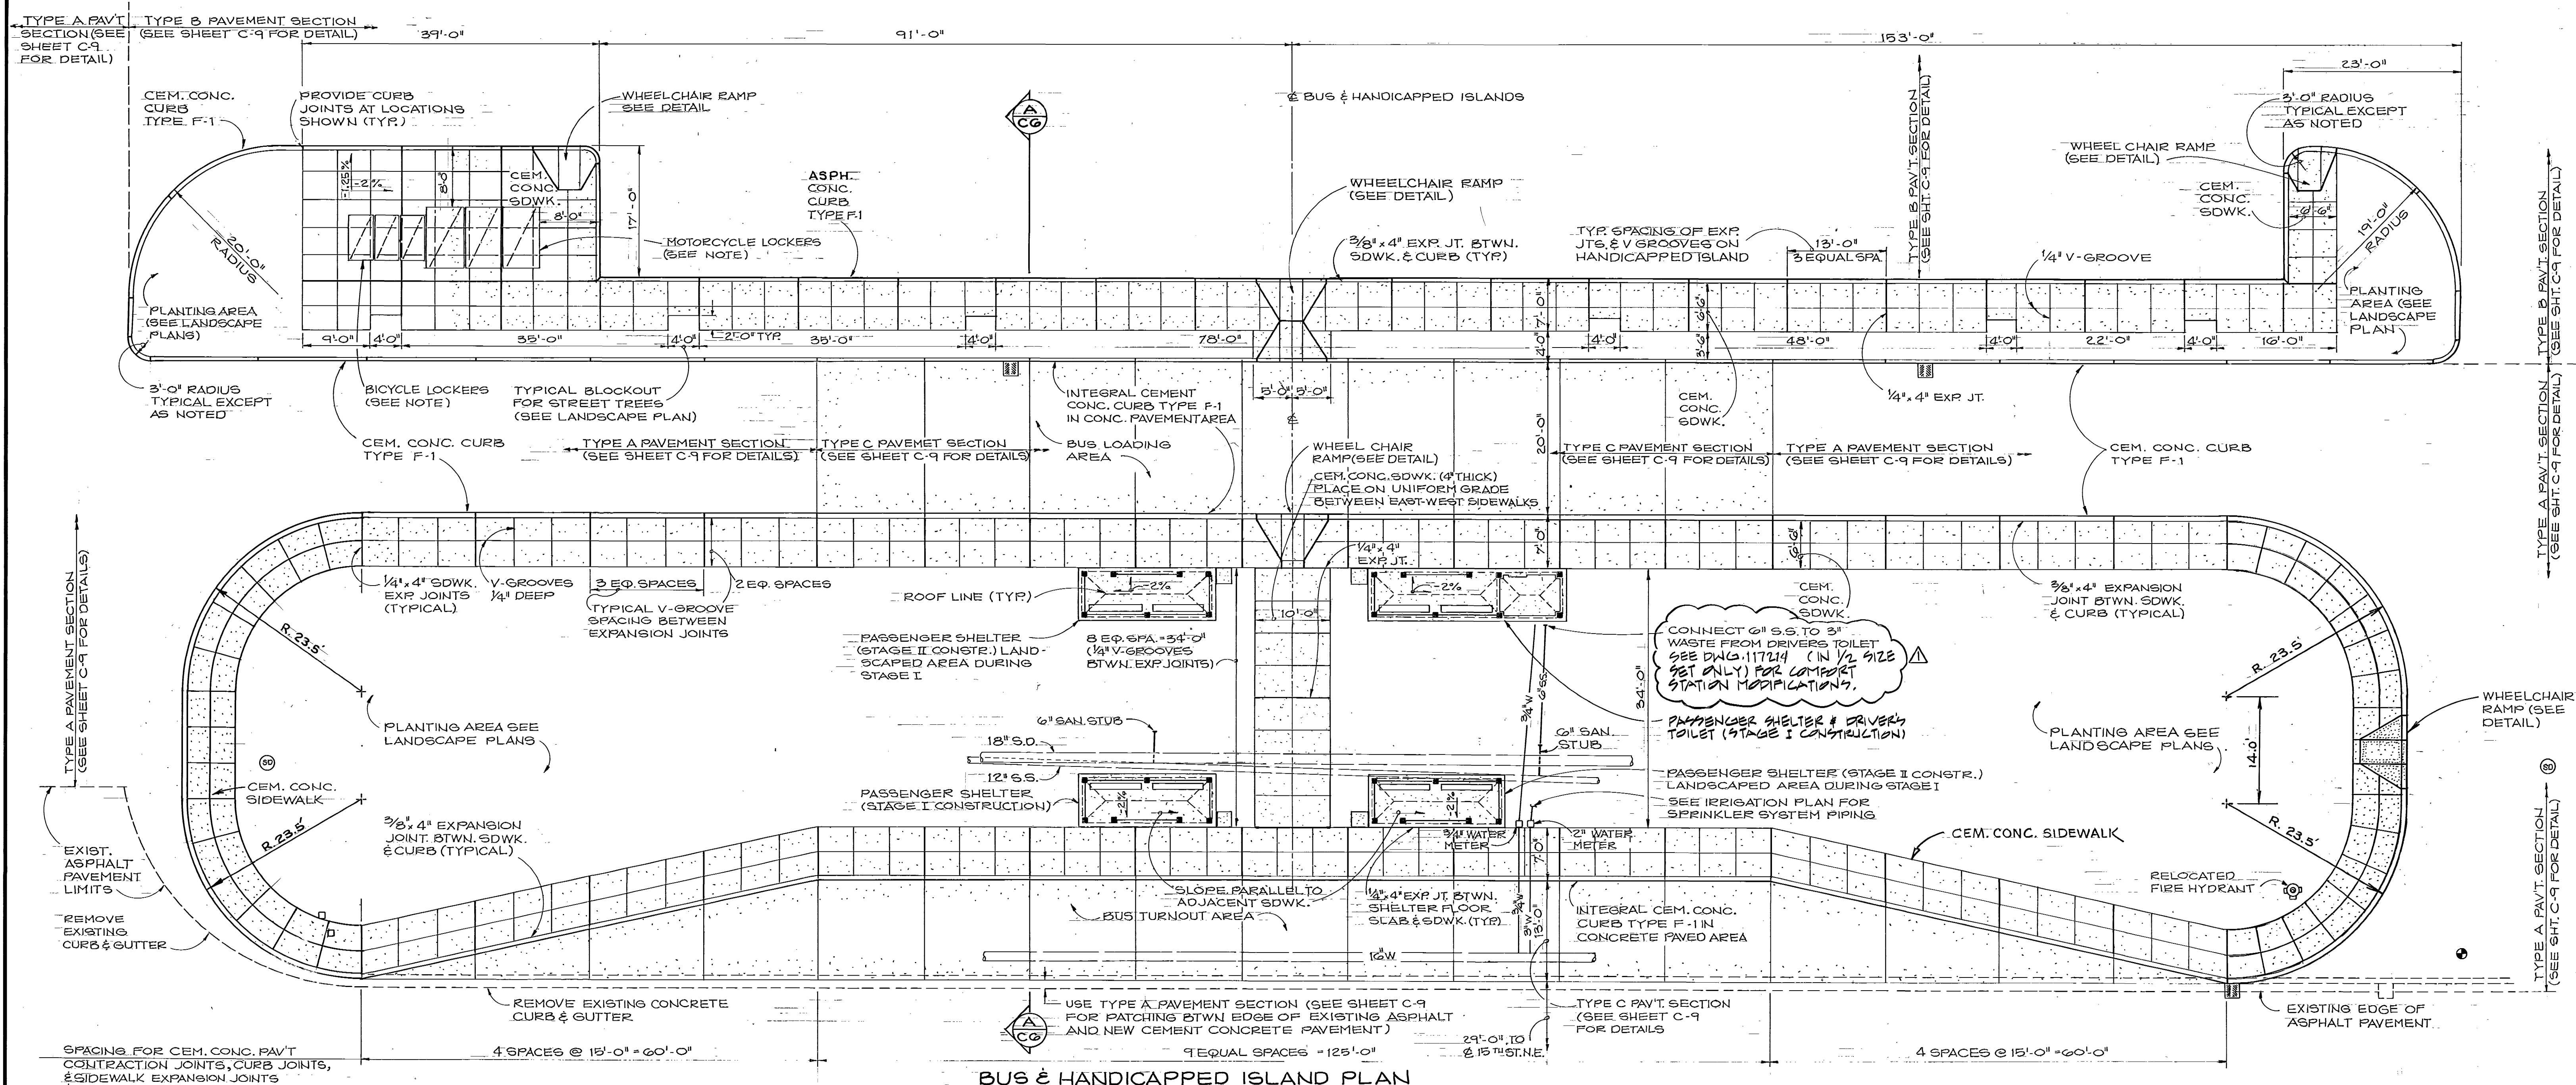

- BUS AND HANDICAPPED ISLAND NOTES**
- SEE SHEET C-3 FOR DETAILS AND DIMENSIONS NOT SHOWN.
 - CEMENT CONCRETE CURBS AND INTEGRAL CEMENT CONCRETE CURBS SHALL BE IN ACCORDANCE WITH STANDARD PLAN F-1 AS DETAILED IN THE STATE OF WASHINGTON STANDARD PLANS FOR ROAD AND BRIDGE CONSTRUCTION (1974).
 - TRANSVERSE CONTRACTION JOINTS SHALL BE IN ACCORDANCE WITH STANDARD PLAN A-2.1 AS DETAILED IN THE STATE OF WASHINGTON STANDARD PLANS FOR ROAD AND BRIDGE CONSTRUCTION (1974).
 - CURB JOINTS SHALL BE LOCATED AS SHOWN ON THE PLAN. THEY SHALL BE 1/8 INCH MINIMUM THICKNESS AND ONE INCH MINIMUM DEPTH AND SHALL BE CONSTRUCTED BY SAWING OR SCORING WITH A TOOL WHICH WILL LEAVE THE CORNERS ROUNDED.
 - ALL CONSTRUCTION ON THIS SHEET IS TO BE PROVIDED DURING STAGE I EXCEPT AS SHOWN OR NOTED.
 - SEE ARCHITECTURAL PLANS FOR PASSENGER SHELTER AND DRIVER'S TOILET DETAILS.
 - BICYCLE LOCKERS (3 UNITS, 6 SPACES) SHALL BE MODEL M-2 AS MANUFACTURED BY BIKE LOCKERS, LTD. OR APPROVED EQUAL. LOCKERS SHALL BE LEVELED AND ANCHORED TO THE SIDEWALK AS DIRECTED BY THE ENGINEER.
 - MOTORCYCLE LOCKERS (3 UNITS, 6 SPACES) SHALL BE MODEL M-2M AS MANUFACTURED BY BIKE LOCKERS, LTD. OR APPROVED EQUAL. LOCKERS SHALL BE LEVELED AND ANCHORED TO THE SIDEWALK AS DIRECTED BY THE ENGINEER.

111195

MUNICIPALITY OF METROPOLITAN SEATTLE — TRANSIT DIVISION
AUBURN PARK-AND-RIDE FACILITY
BUS & HANDICAPPED ISLAND DETAILS







VICTOR O. GRAY & COMPANY, INC.
CONSULTING ENGINEERS & PLANNERS
RICHARD HAAG & ASSOCIATES
LANDSCAPE ARCHITECTS
JD 21 — LIGHTING ENGINEERS

Date 9/76
File No. 7605
Sheet 6 of 27

R.F.H. 6/76
Designed Date
A.O.K. 7/76
Drawn Date

Municipality of Metropolitan Seattle
Approved Date 12/29/76

C-6
Sheet Number

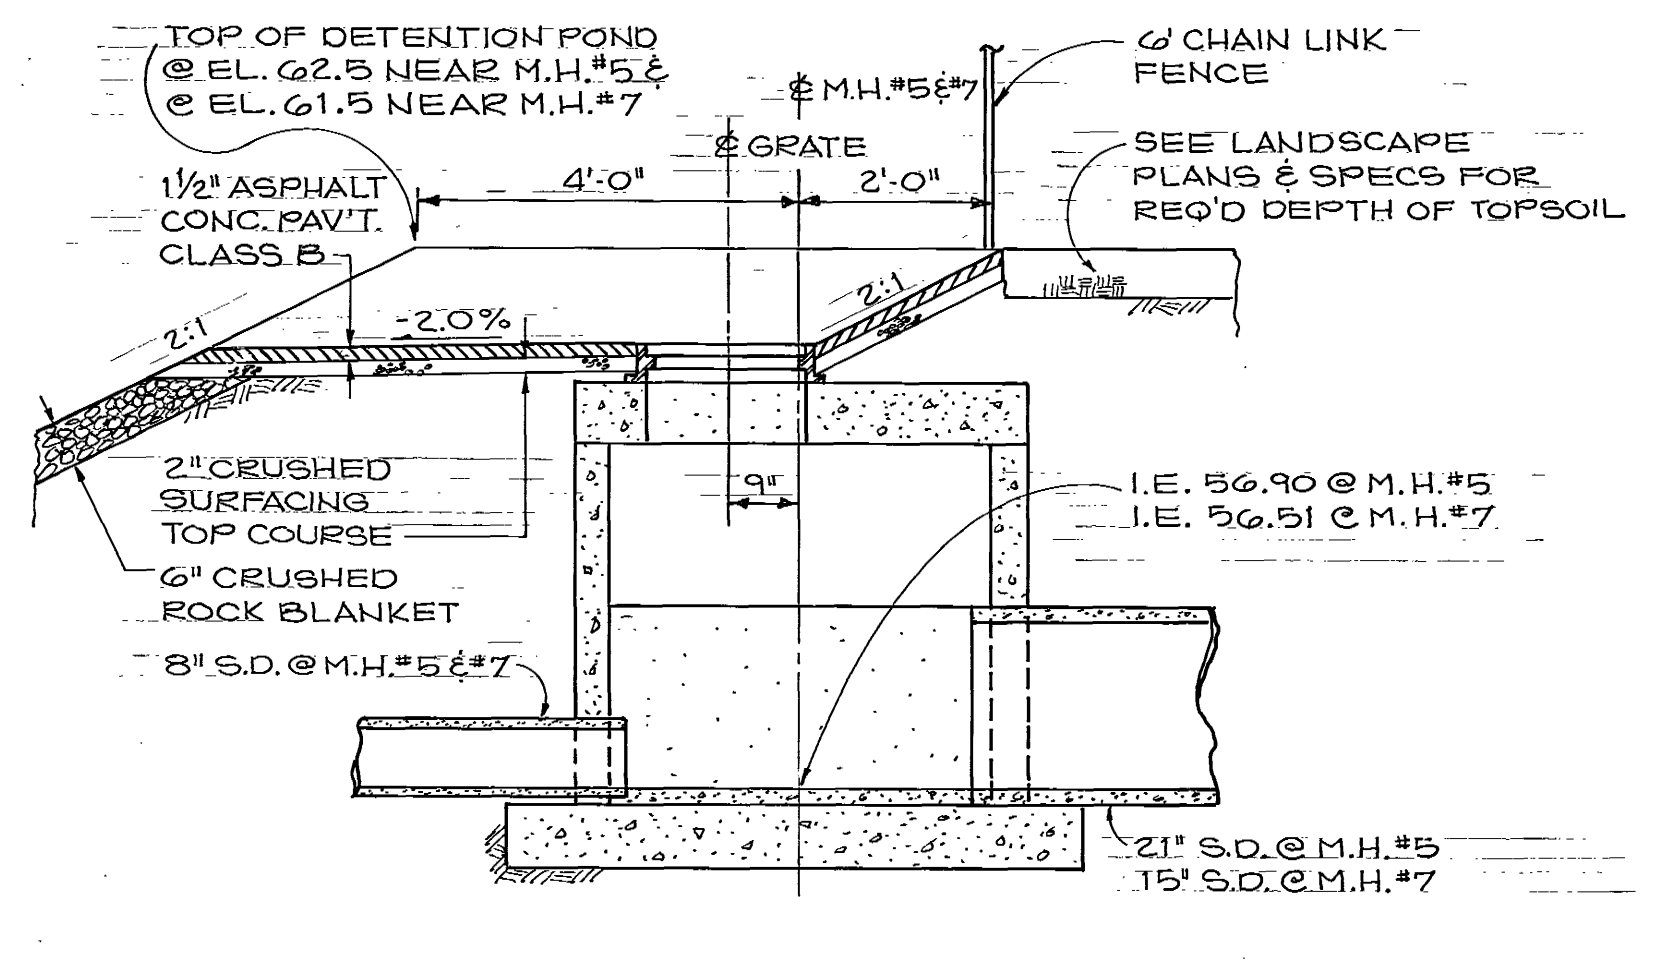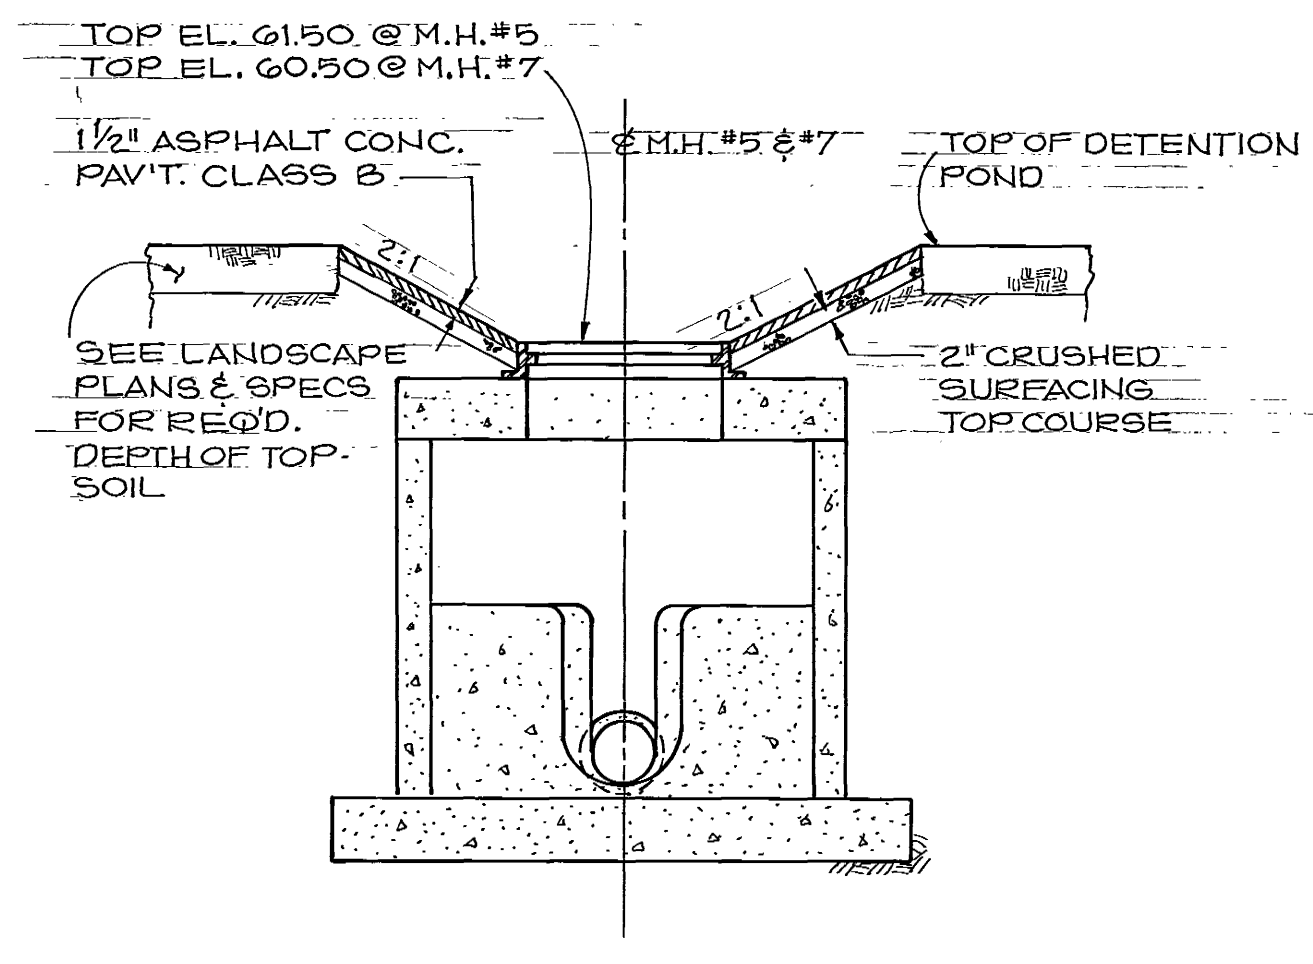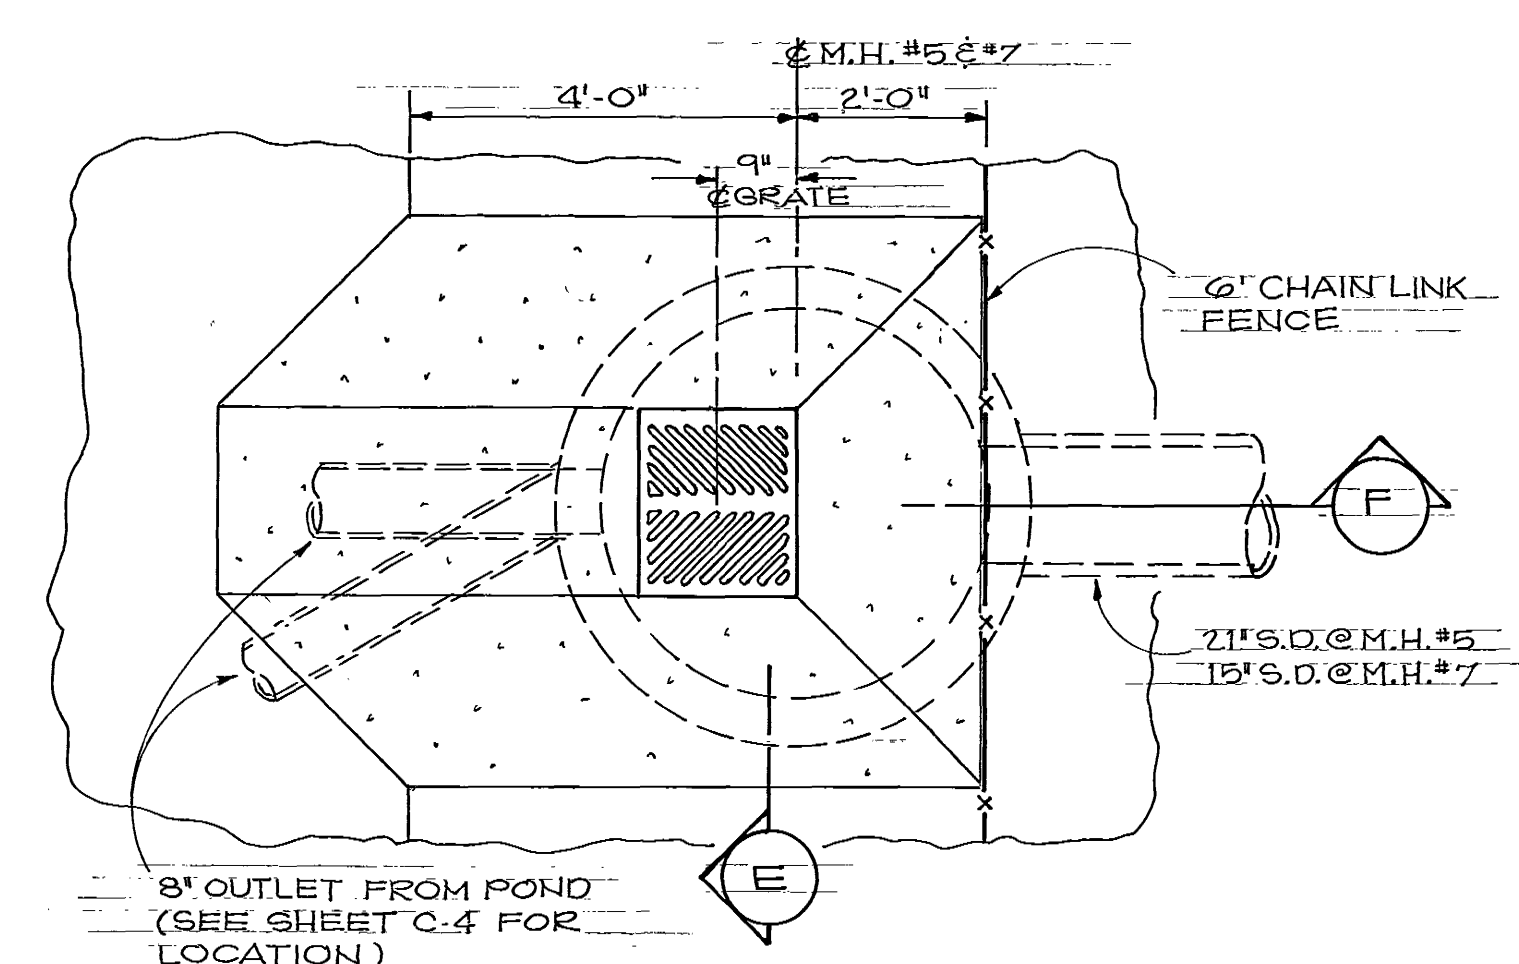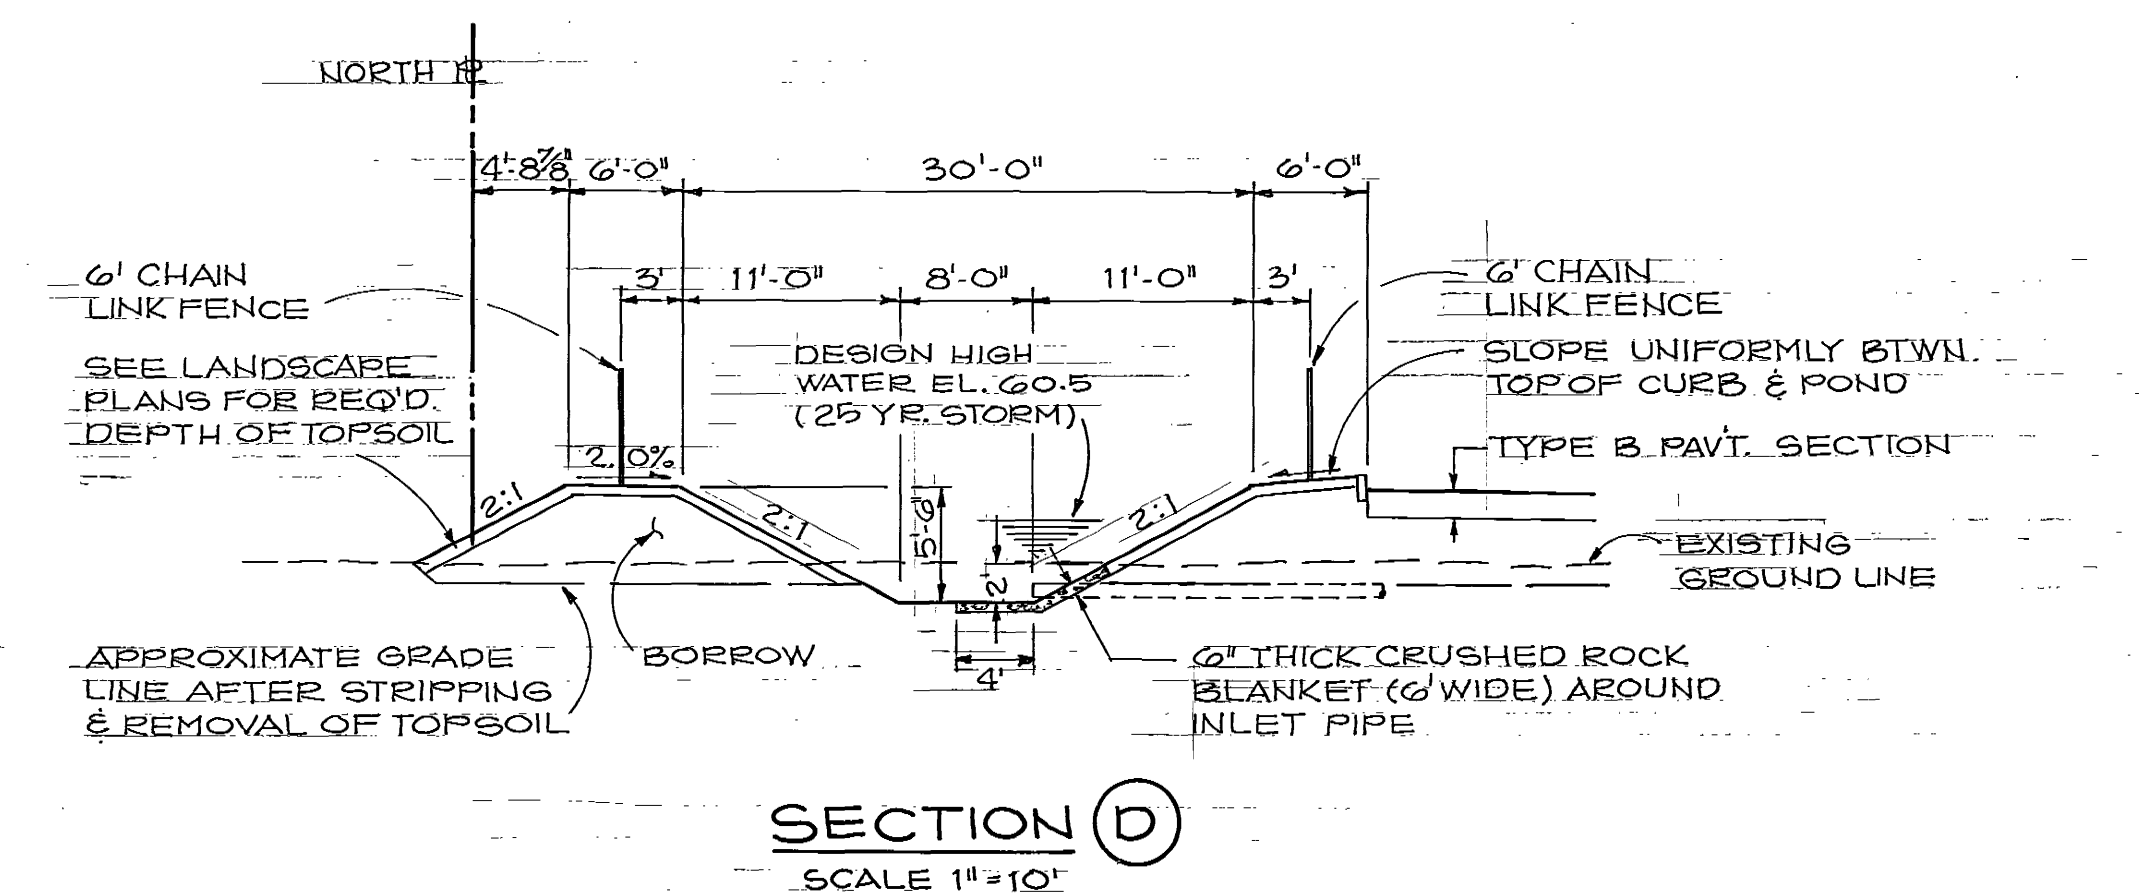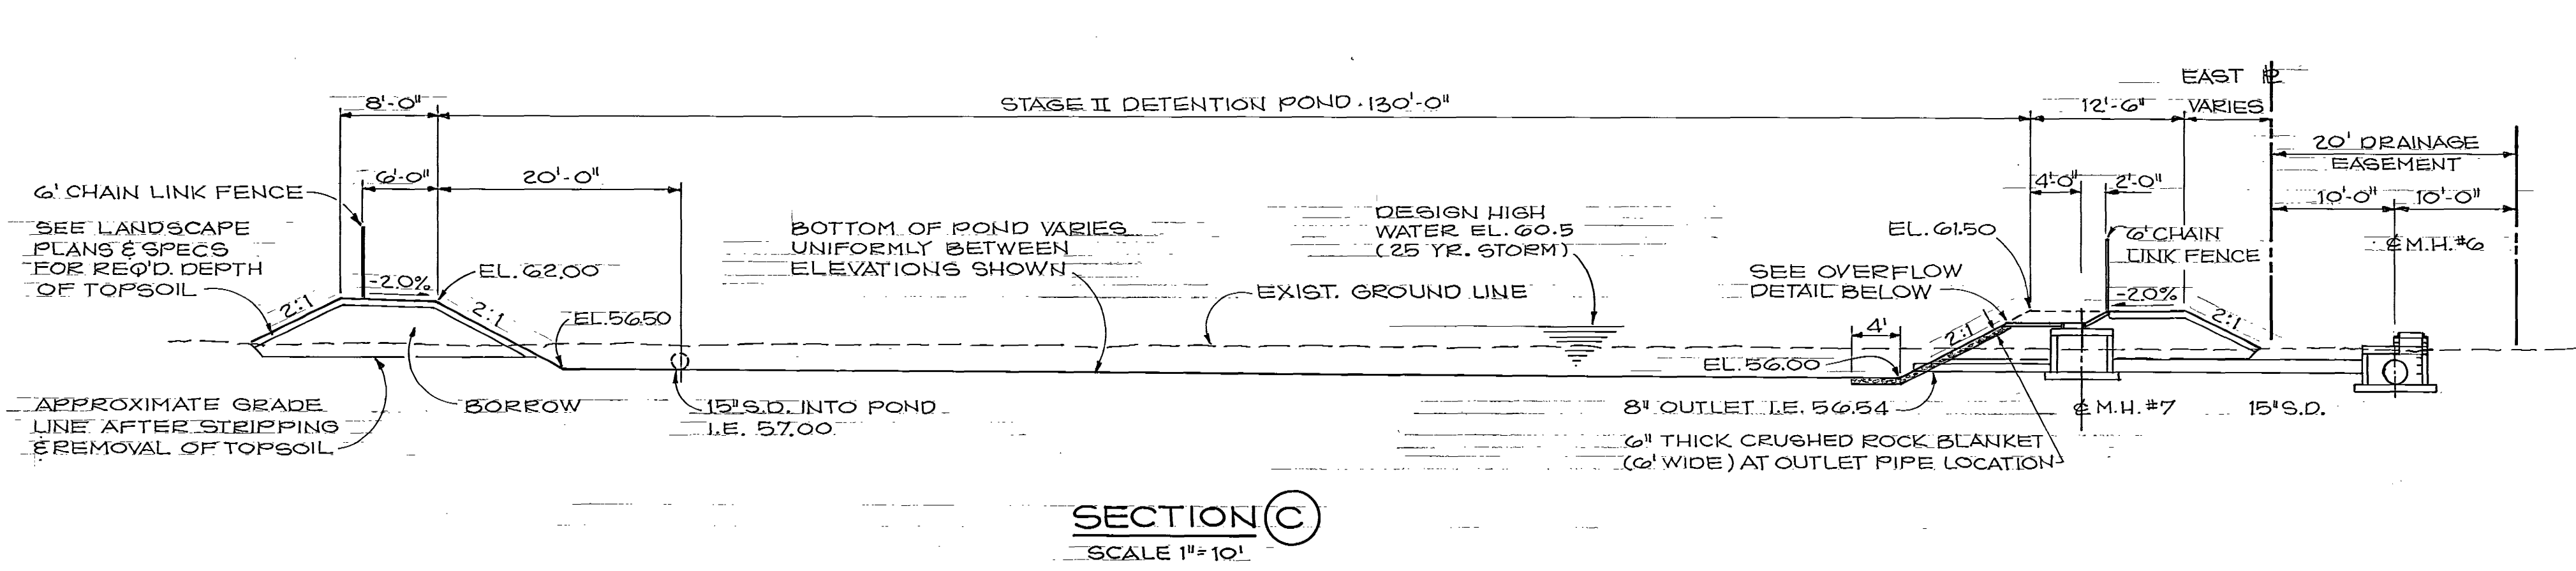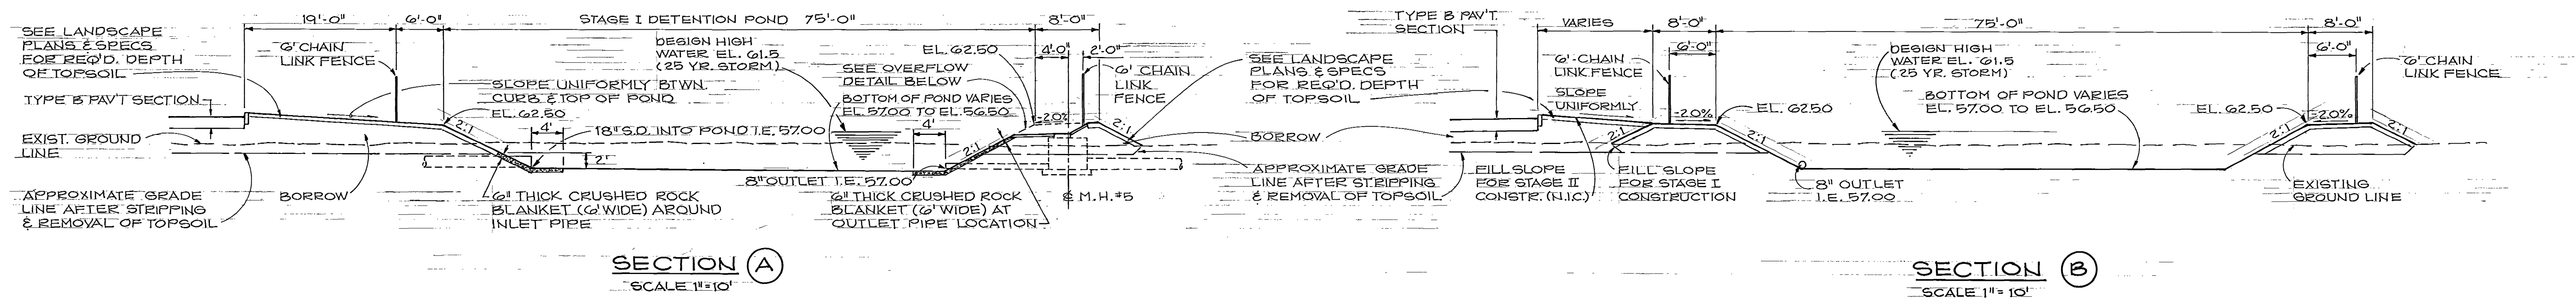


DETENTION POND DETAILS

SCALE AS SHOWN
SEE SHEET NO. C-4 FOR DETAILS & DIMENSIONS NOT SHOWN


111197

MUNICIPALITY OF METROPOLITAN SEATTLE — TRANSIT DIVISION AUBURN PARK-AND-RIDE FACILITY DETENTION POND DETAILS			
	VICTOR O. GRAY & COMPANY, INC. CONSULTING ENGINEERS & PLANNERS		Date 9/76
	RICHARD HAAG & ASSOCIATES LANDSCAPE ARCHITECTS		File No. 7605
	JD 21 — LIGHTING ENGINEERS		Sheet 8 of 27
R. F. H. Designed	6/76 Date	Municipality of Metropolitan Seattle	C-8 Sheet Number
A. O. K. Drawn	7/76 Date	Approved <i>J.W. Malley</i> 12/29/76	


"AS CONSTRUCTED"
FEB. 10 1978

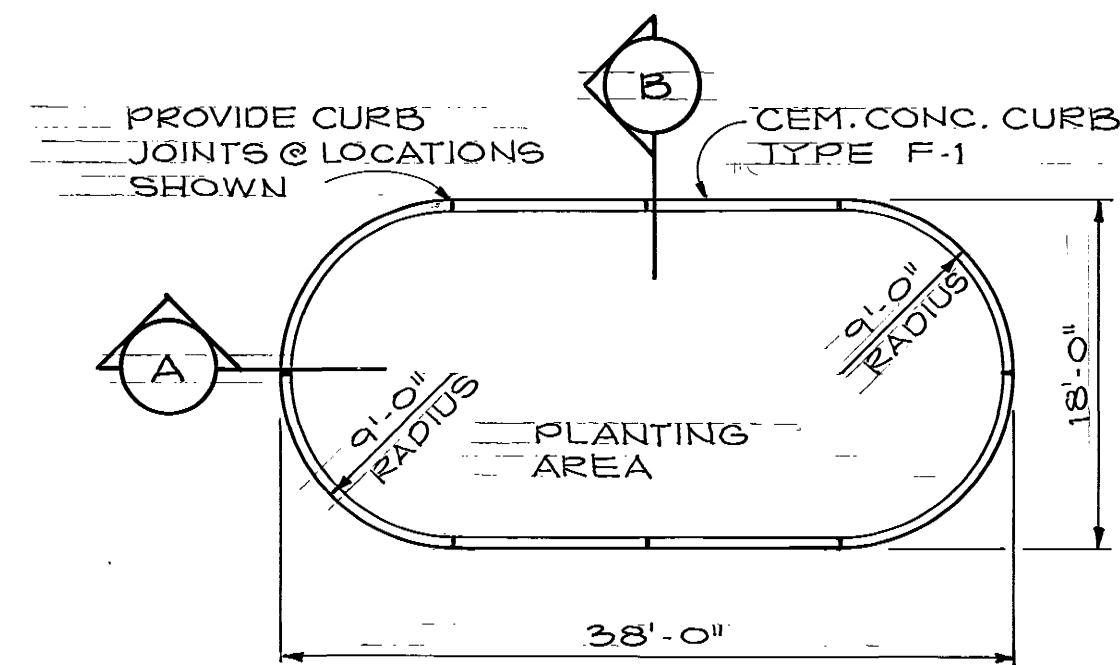


TYPICAL CENTER ISLAND PLAN
SCALE 1" = 10'

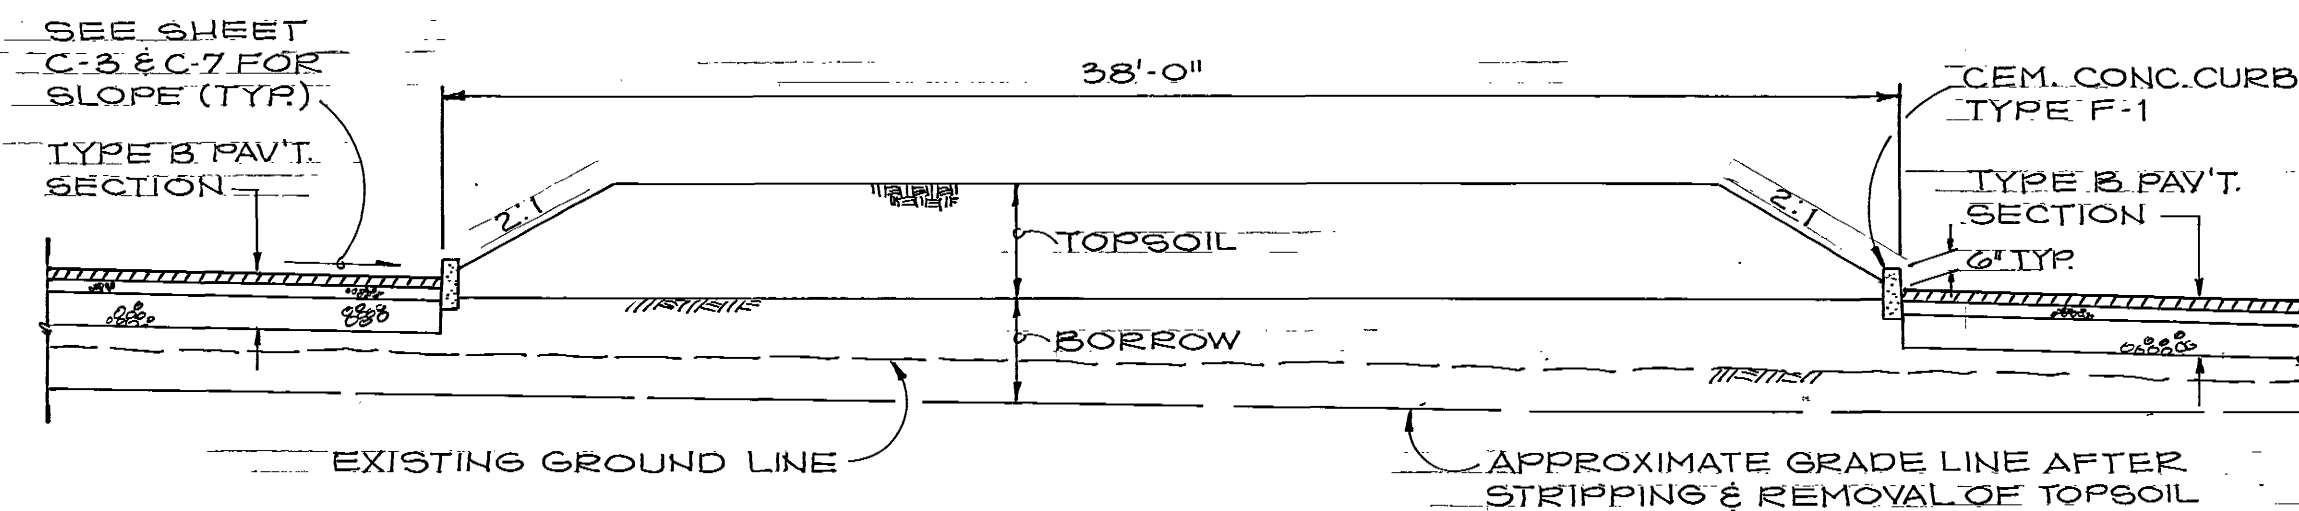


SECTION A
SCALE 1" = 5'

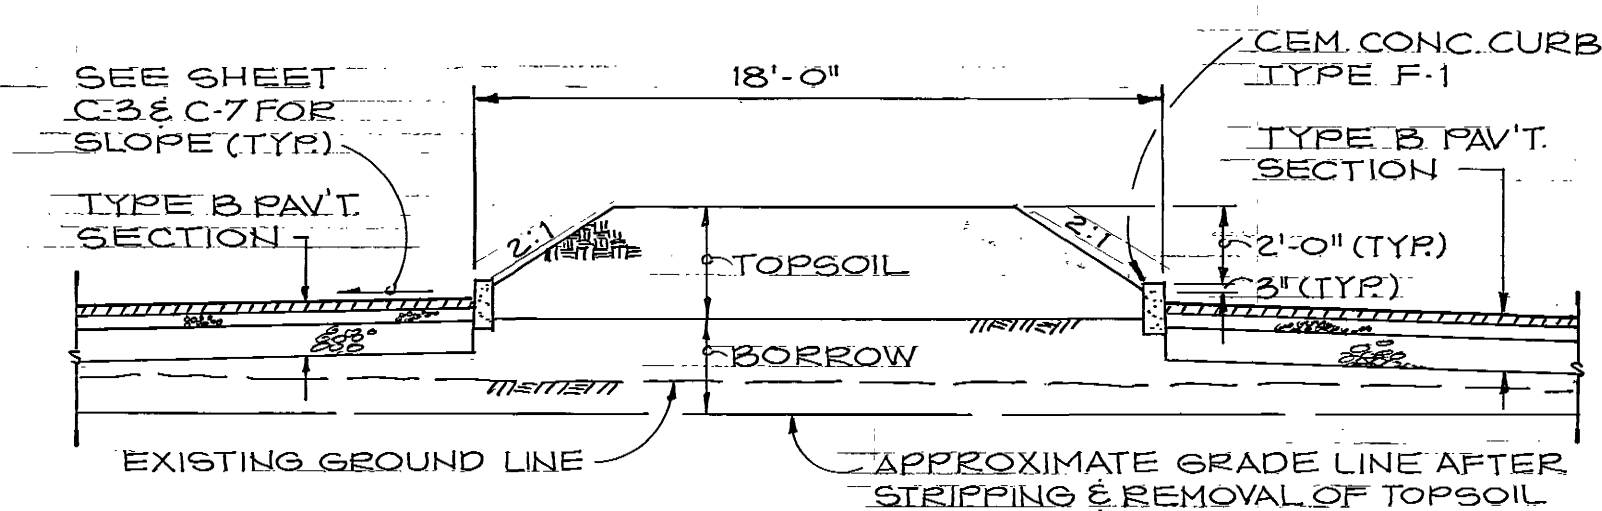


SECTION B
SCALE 1" = 5'

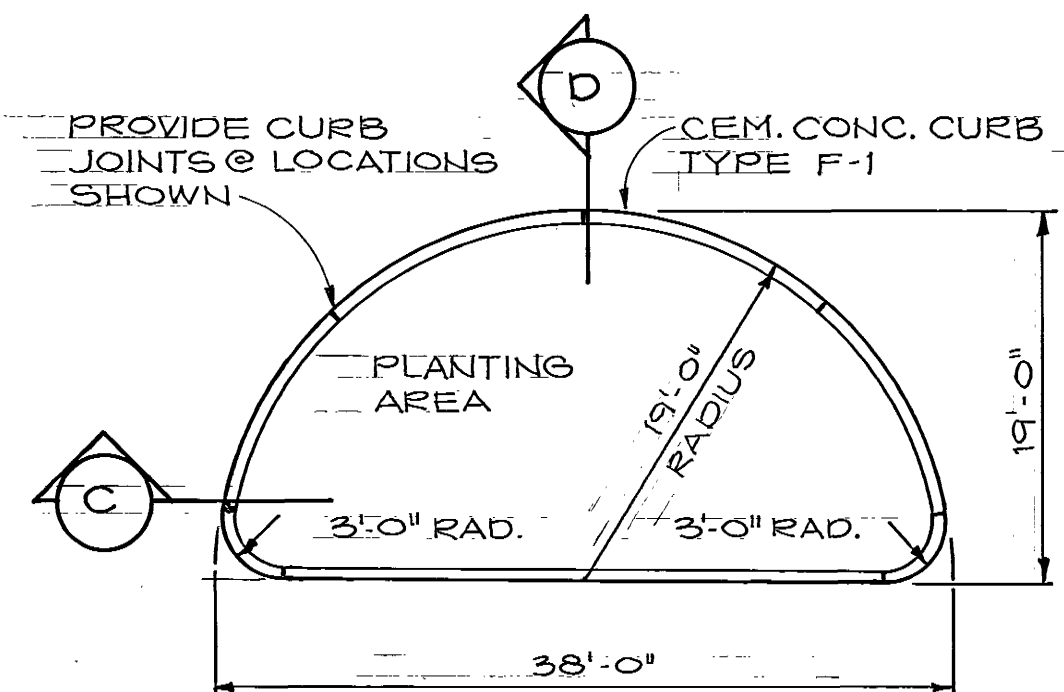


TYPICAL END ISLAND PLAN
SCALE 1" = 10'

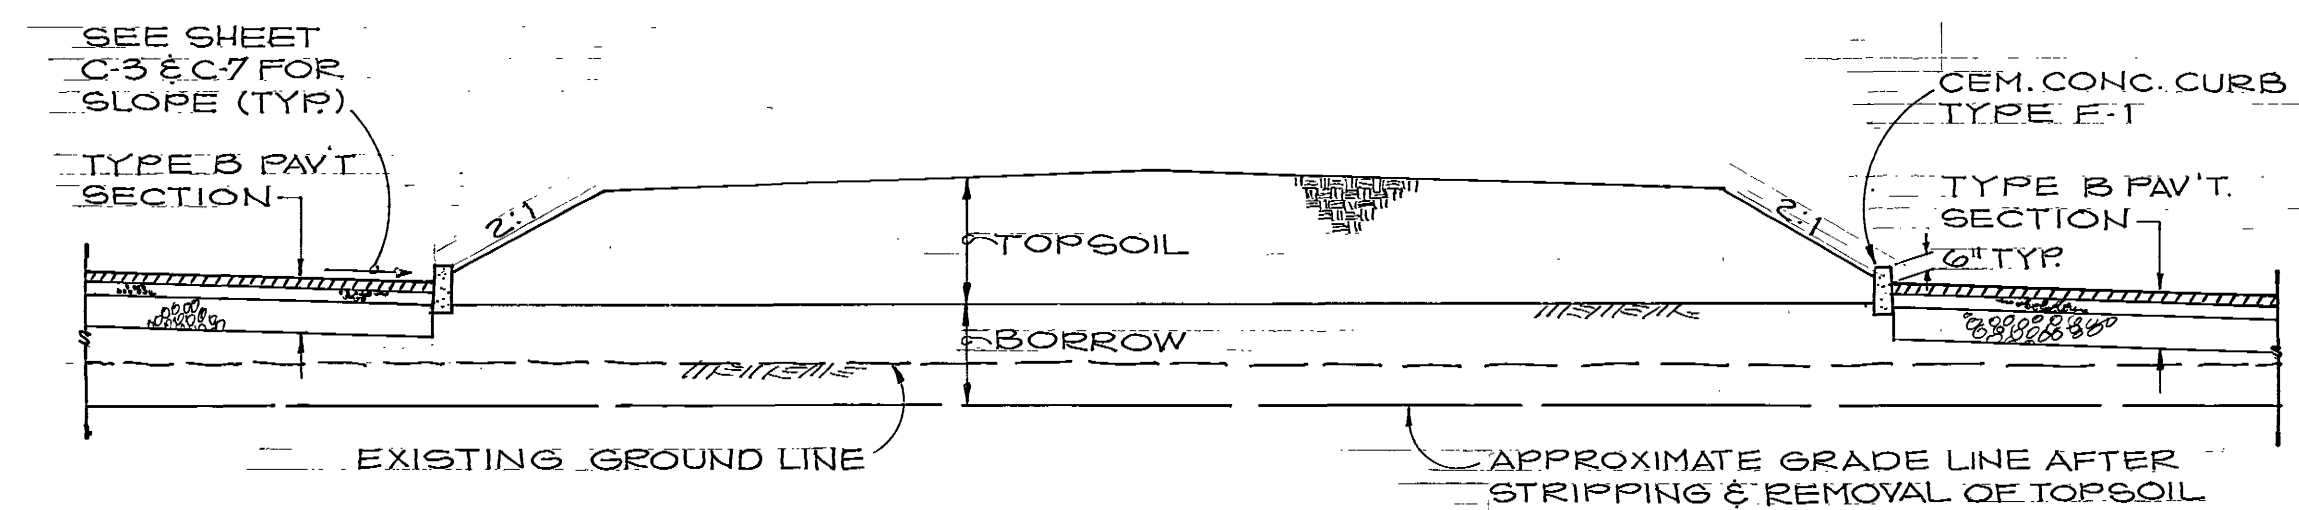


SECTION C
SCALE 1" = 5'

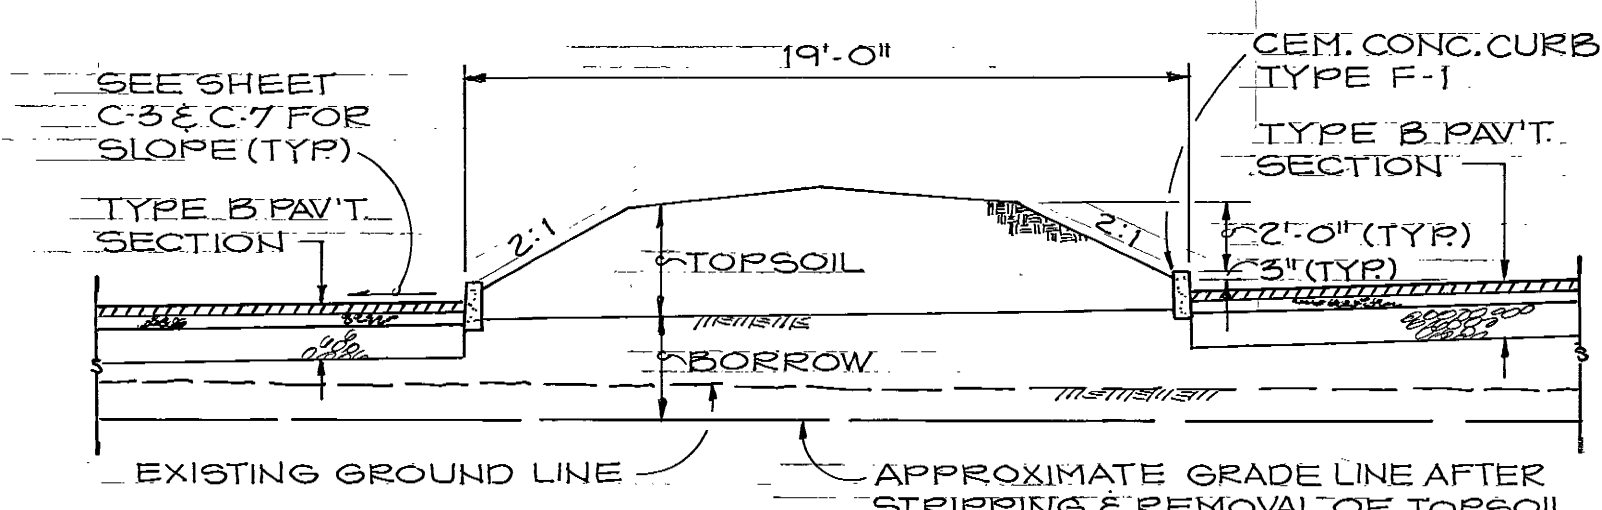


SECTION D
SCALE 1" = 5'

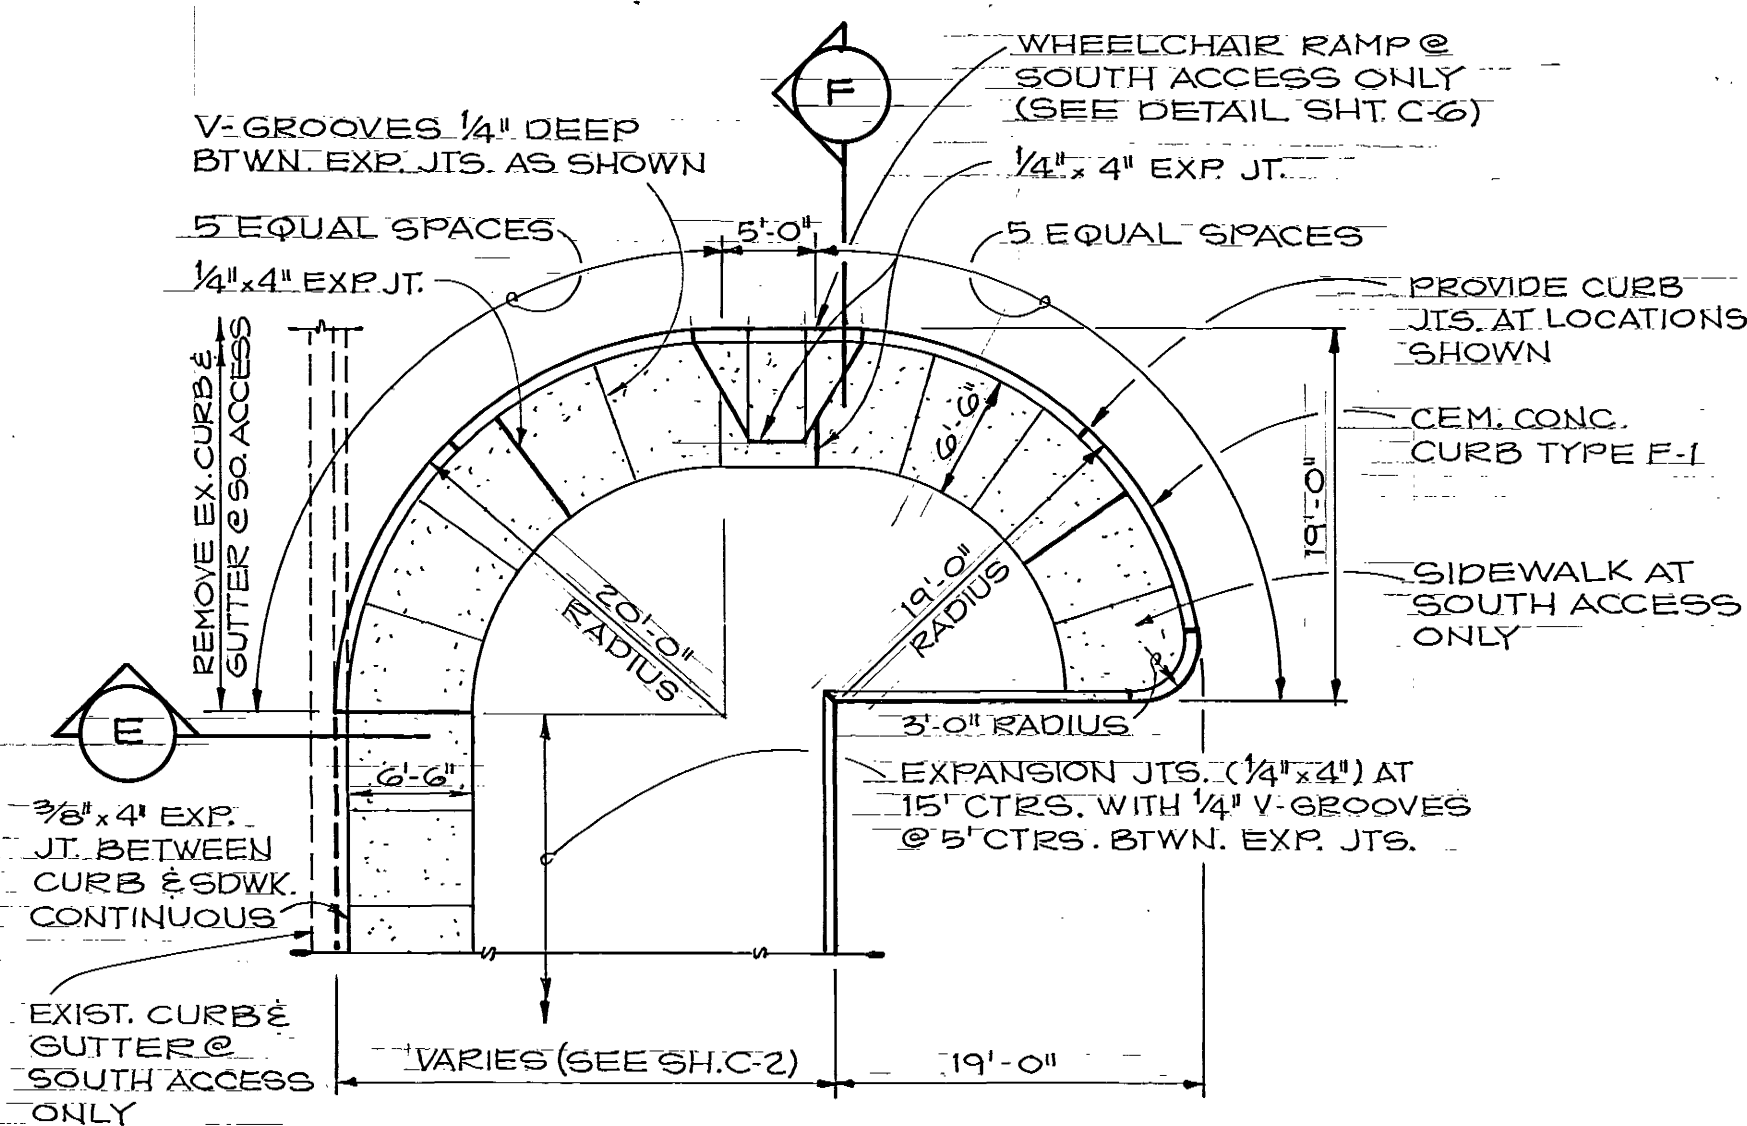

TYPICAL ACCESS PLAN
SCALE 1" = 10'

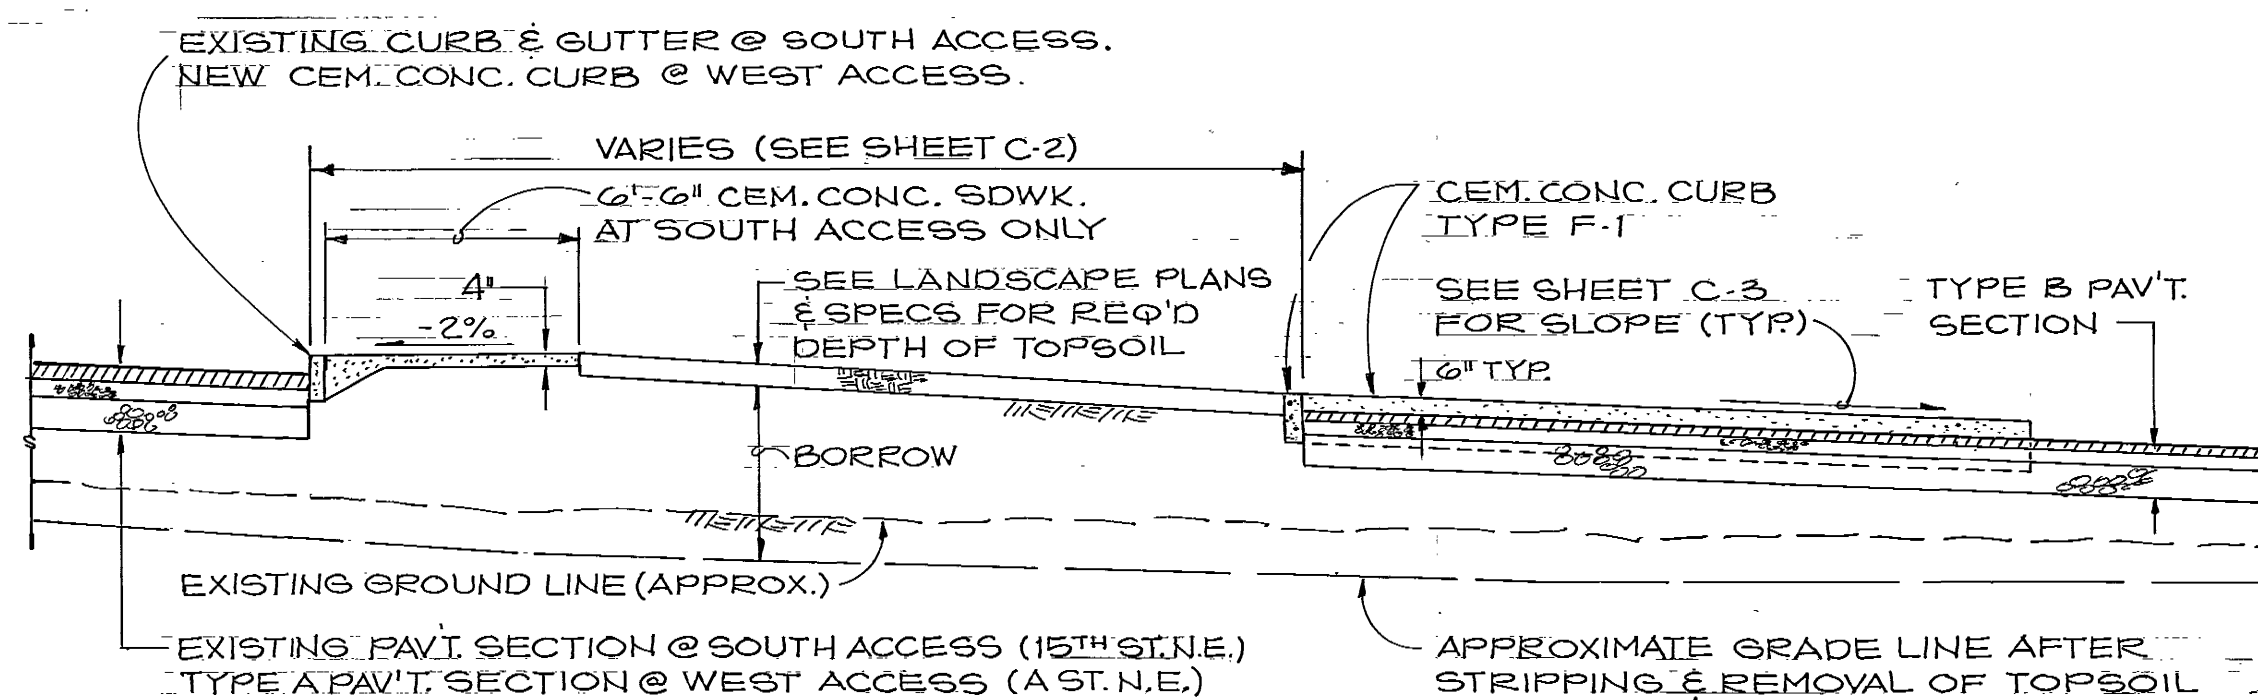

SECTION E
SCALE 1" = 5'

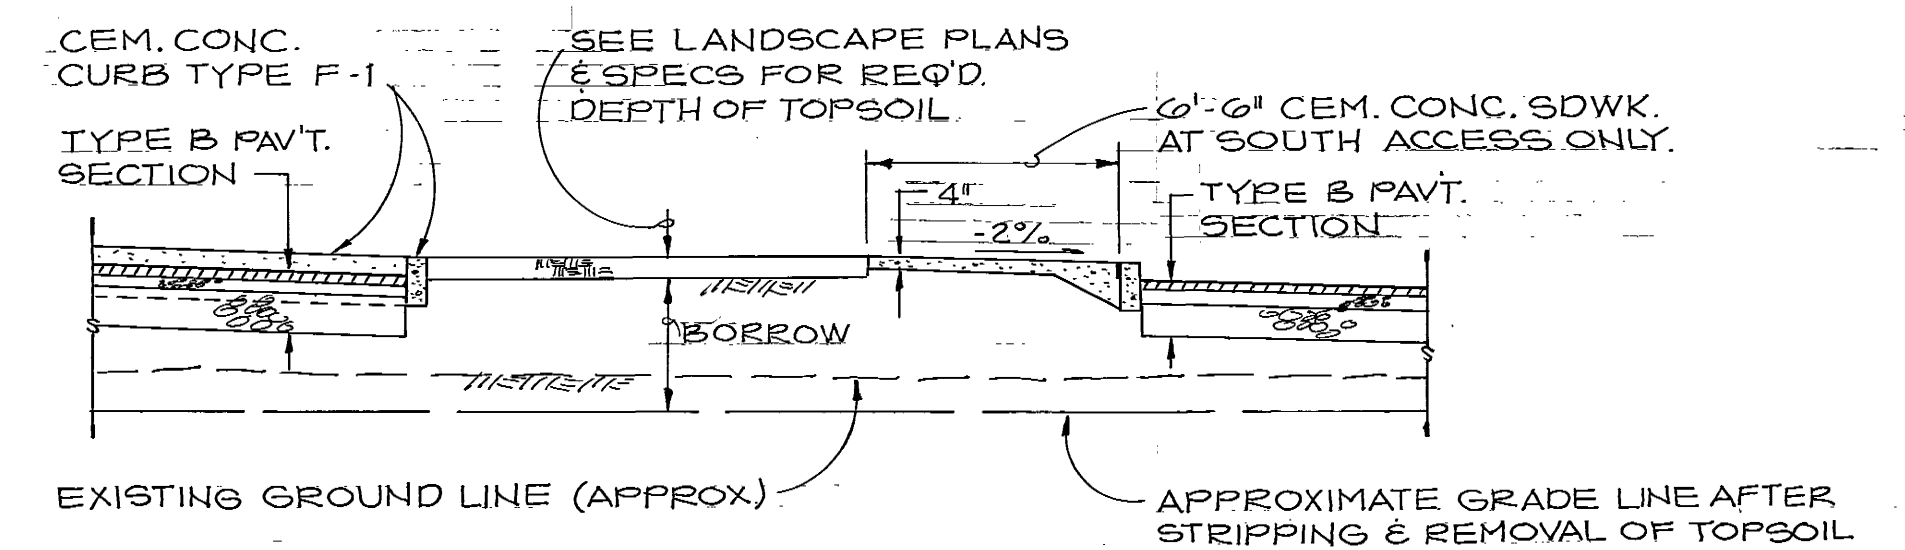


SECTION F
SCALE 1" = 5'

SITE DETAIL NOTES

1. SEE SHEET C-2 FOR CENTER ISLAND, END ISLAND, AND ACCESS ISLAND LOCATIONS.
2. SEE SHEETS C-2 AND C-6 FOR LOCATION OF TYPE A, B, AND C PAVEMENT SECTIONS.
3. SEE LANDSCAPE AND ELECTRICAL DRAWINGS FOR ADDITIONAL WORK IN THE PLANTING AREAS.
4. TOP OF CEMENT CONCRETE CURBS TO BE SET 6 INCHES ABOVE TOP OF PAVEMENT ELEVATION AT THE CURB LINE. SEE SHEET C-3 FOR TOP OF PAVEMENT ELEVATIONS.
5. CURB JOINTS SHALL BE AS LOCATED ON THE PLAN, OR AT 15 FEET MAXIMUM C/C SPACING. THEY SHALL BE 1/8 INCH MINIMUM THICKNESS AND ONE INCH MINIMUM DEPTH AND SHALL BE CONSTRUCTED BY SAWING OR SCORING WITH A TOOL WHICH WILL LEAVE THE CORNERS ROUNDED.

111198

MUNICIPALITY OF METROPOLITAN SEATTLE — TRANSIT DIVISION
AUBURN PARK-AND-RIDE FACILITY
TYPICAL DETAILS

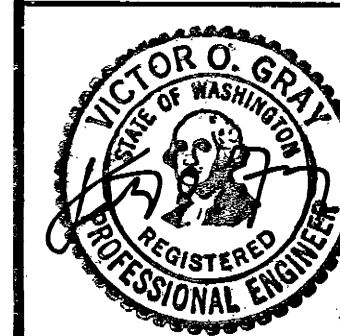

VICTOR O. GRAY & COMPANY, INC.
CONSULTING ENGINEERS & PLANNERS

RICHARD HAAG & ASSOCIATES
LANDSCAPE ARCHITECTS
JD 21 — LIGHTING ENGINEERS

R. F. H. Designed 6/76
A. O. K. Drawn 7/76
Municipality of Metropolitan Seattle Approved Date 12/19/76


Date 9/76
File No. 7605

Sheet 9 of 27

C-9


Sheet Number

"AS CONSTRUCTED
FEB. 10 1978

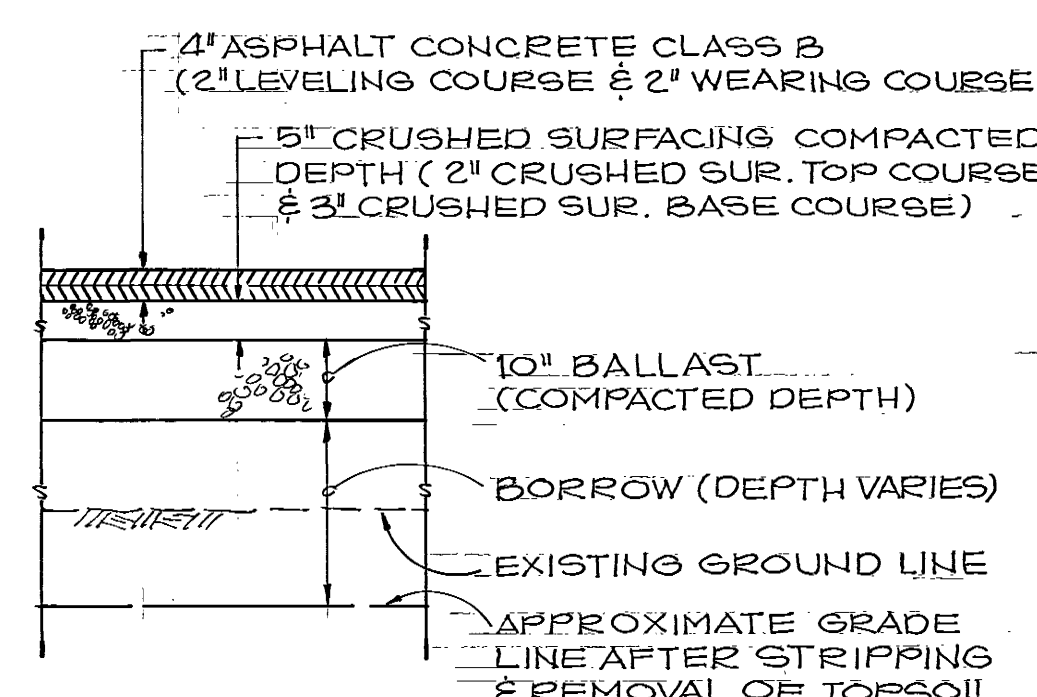


TYPE A PAVEMENT SECTION
SCALE 1" = 2'

TYPE A PAV'T. SECTION TO BE USED
IN AREAS SUBJECT TO TRUCK &
BUS TRAFFIC (SEE SHEETS C-2 & C-6)

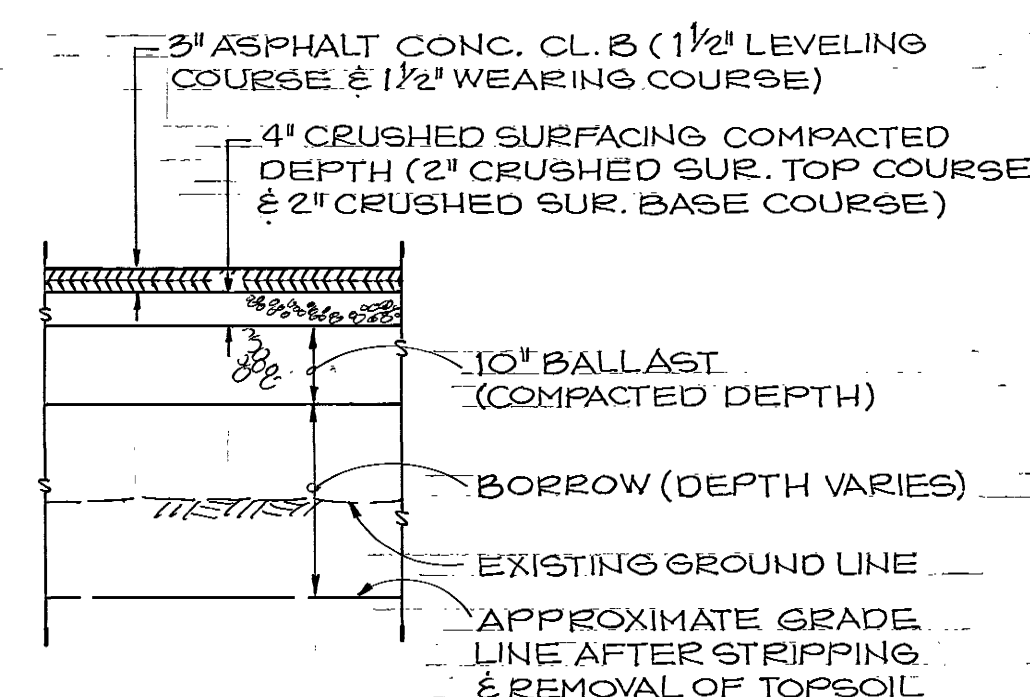


TYPE B PAVEMENT SECTION
SCALE 1" = 2'

TYPE B PAV'T. SECTION TO BE USED
IN AREAS SUBJECT TO AUTO
TRAFFIC ONLY (SEE SHEETS C-2 & C-6)

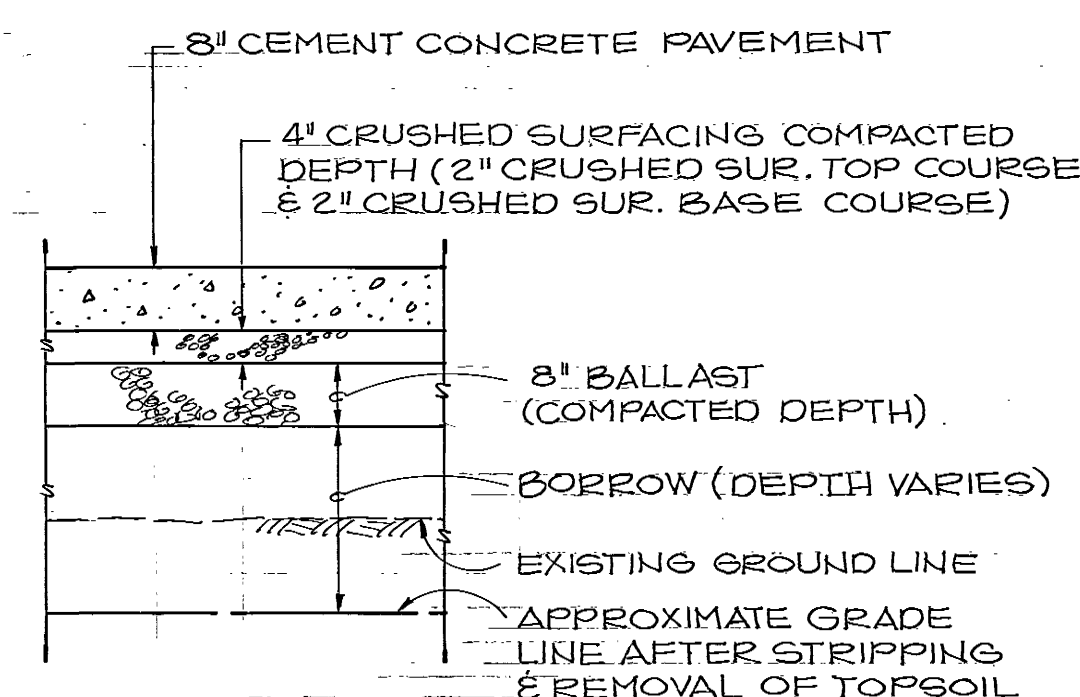


TYPE C PAVEMENT SECTION
SCALE 1" = 2'


TYPE C PAV'T. SECTION TO BE USED
IN BUS LOADING AREAS (SEE SHEETS
C-2 & C-6)

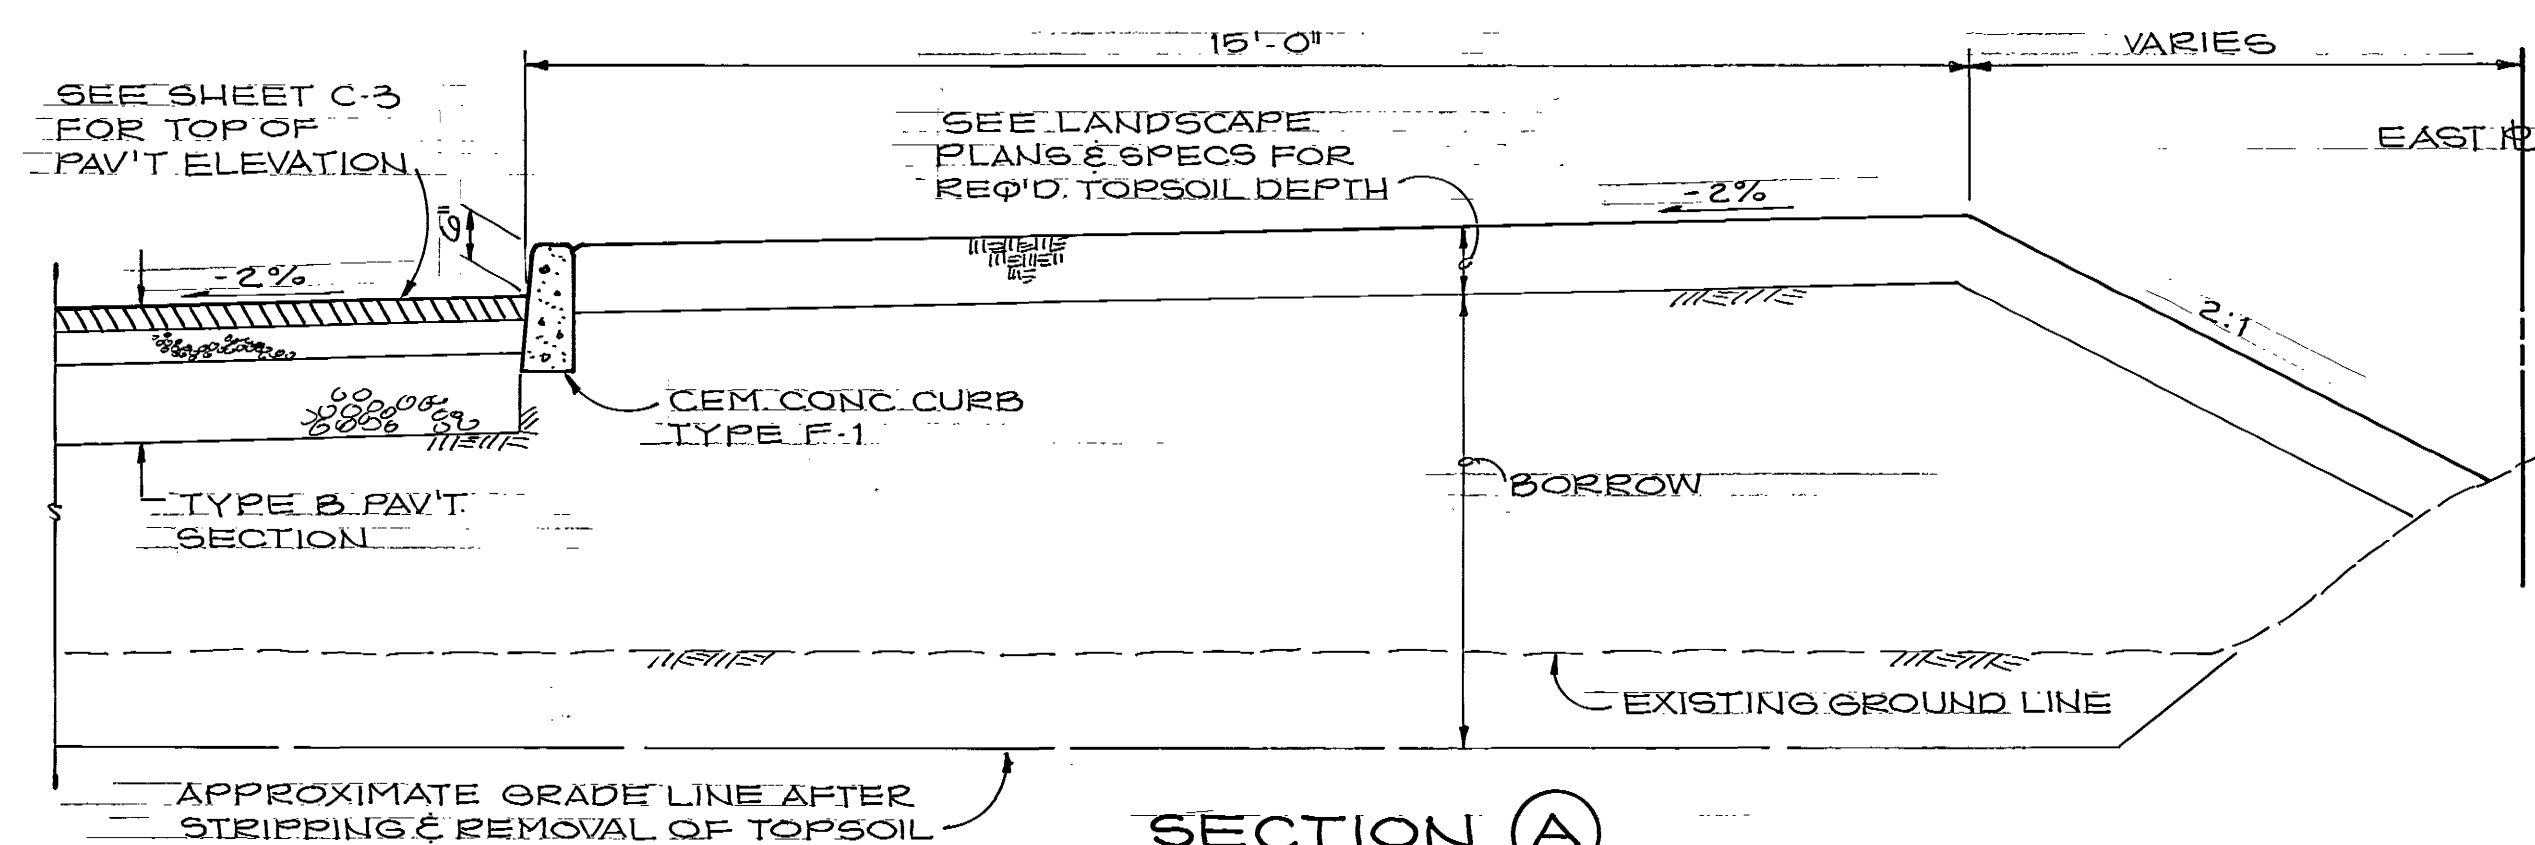


SECTION A
SCALE 1"=2'

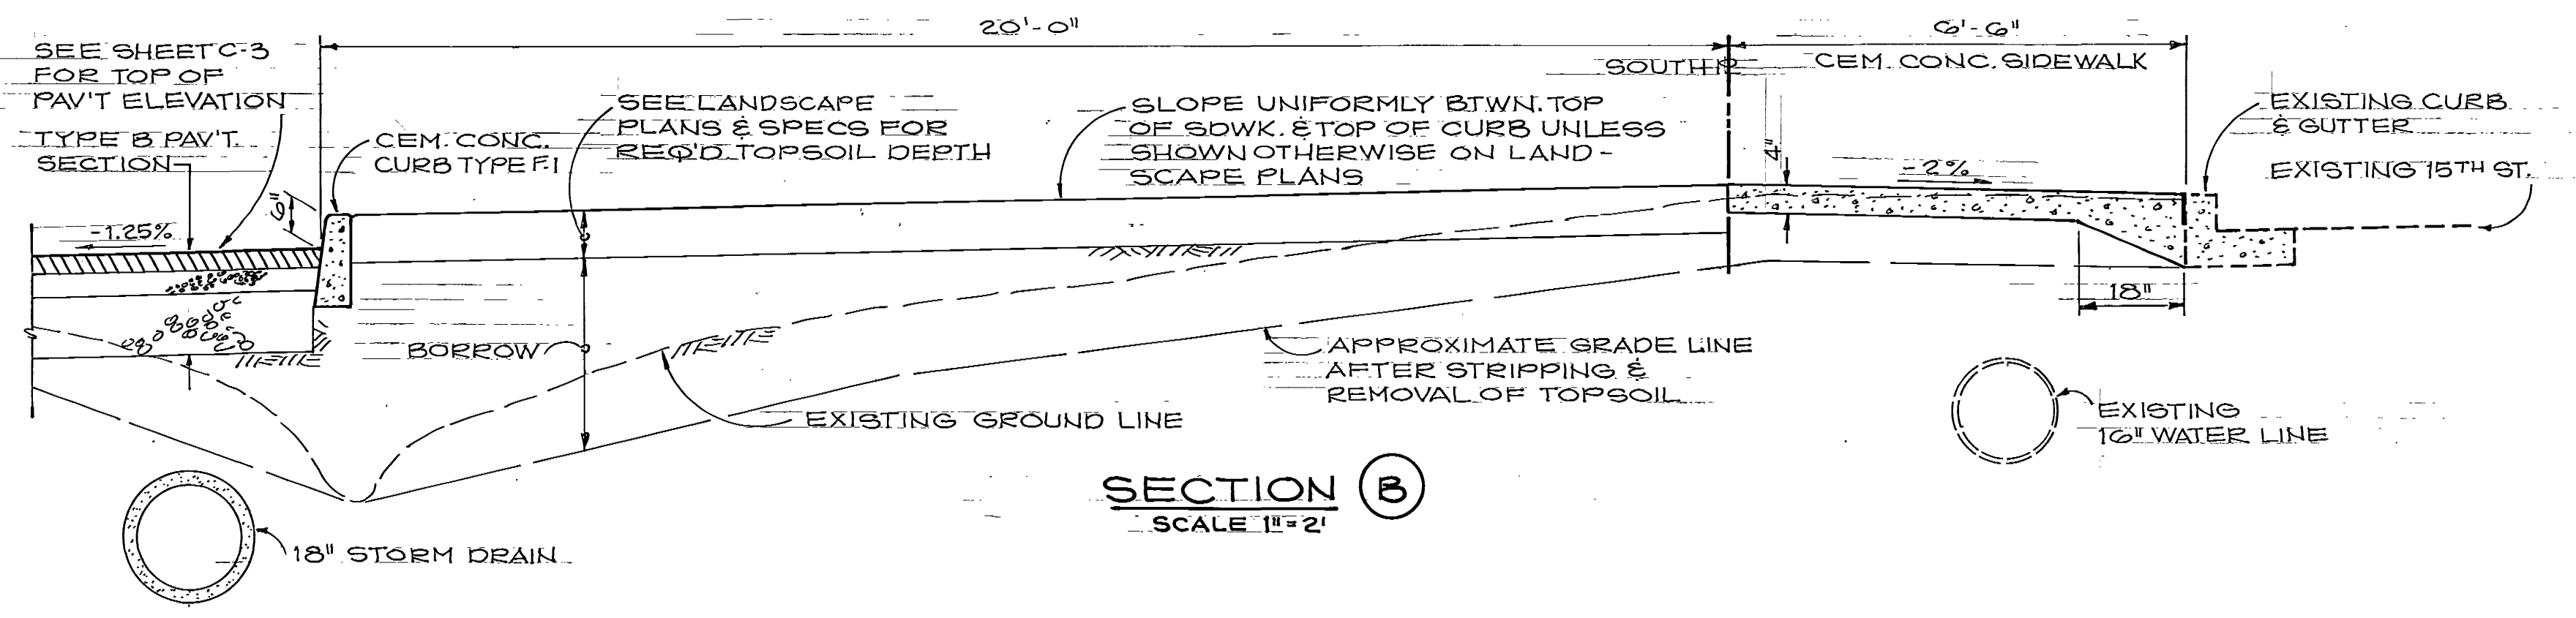


SECTION B
SCALE 1"=2'

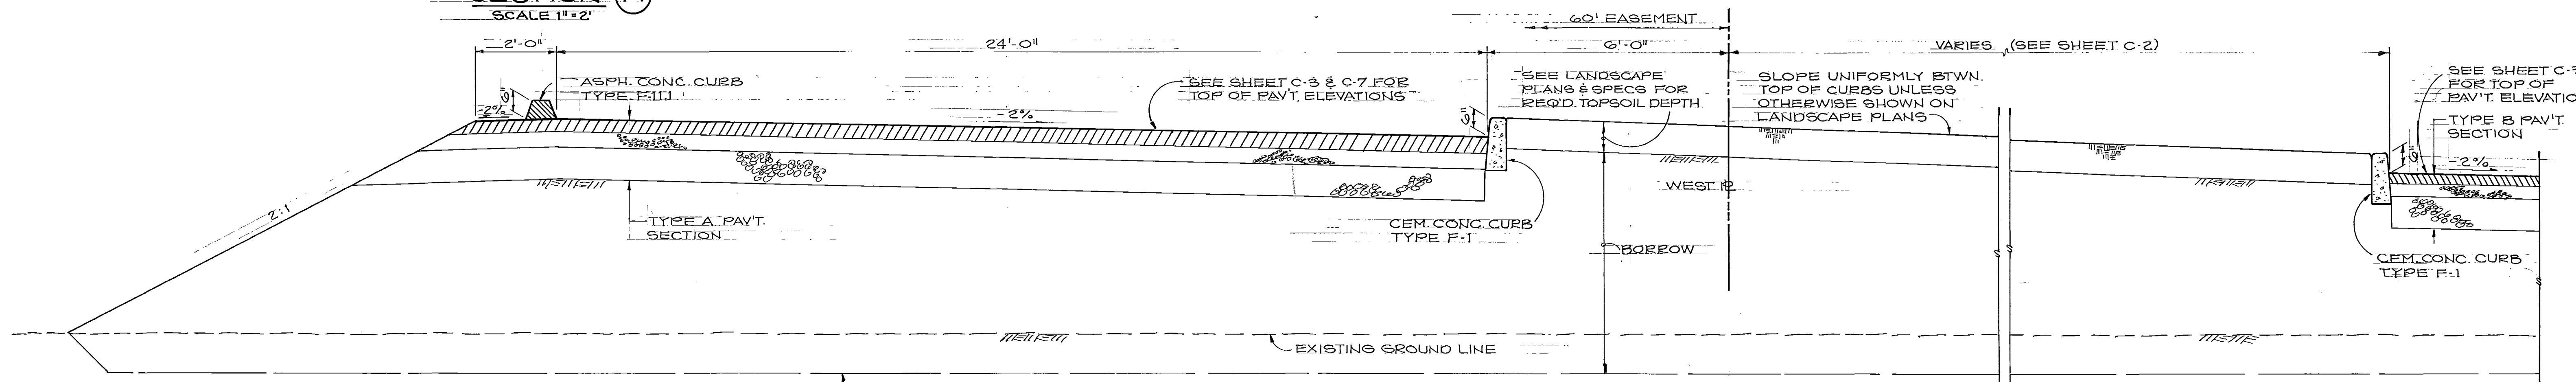


SECTION C
SCALE 1"=2'

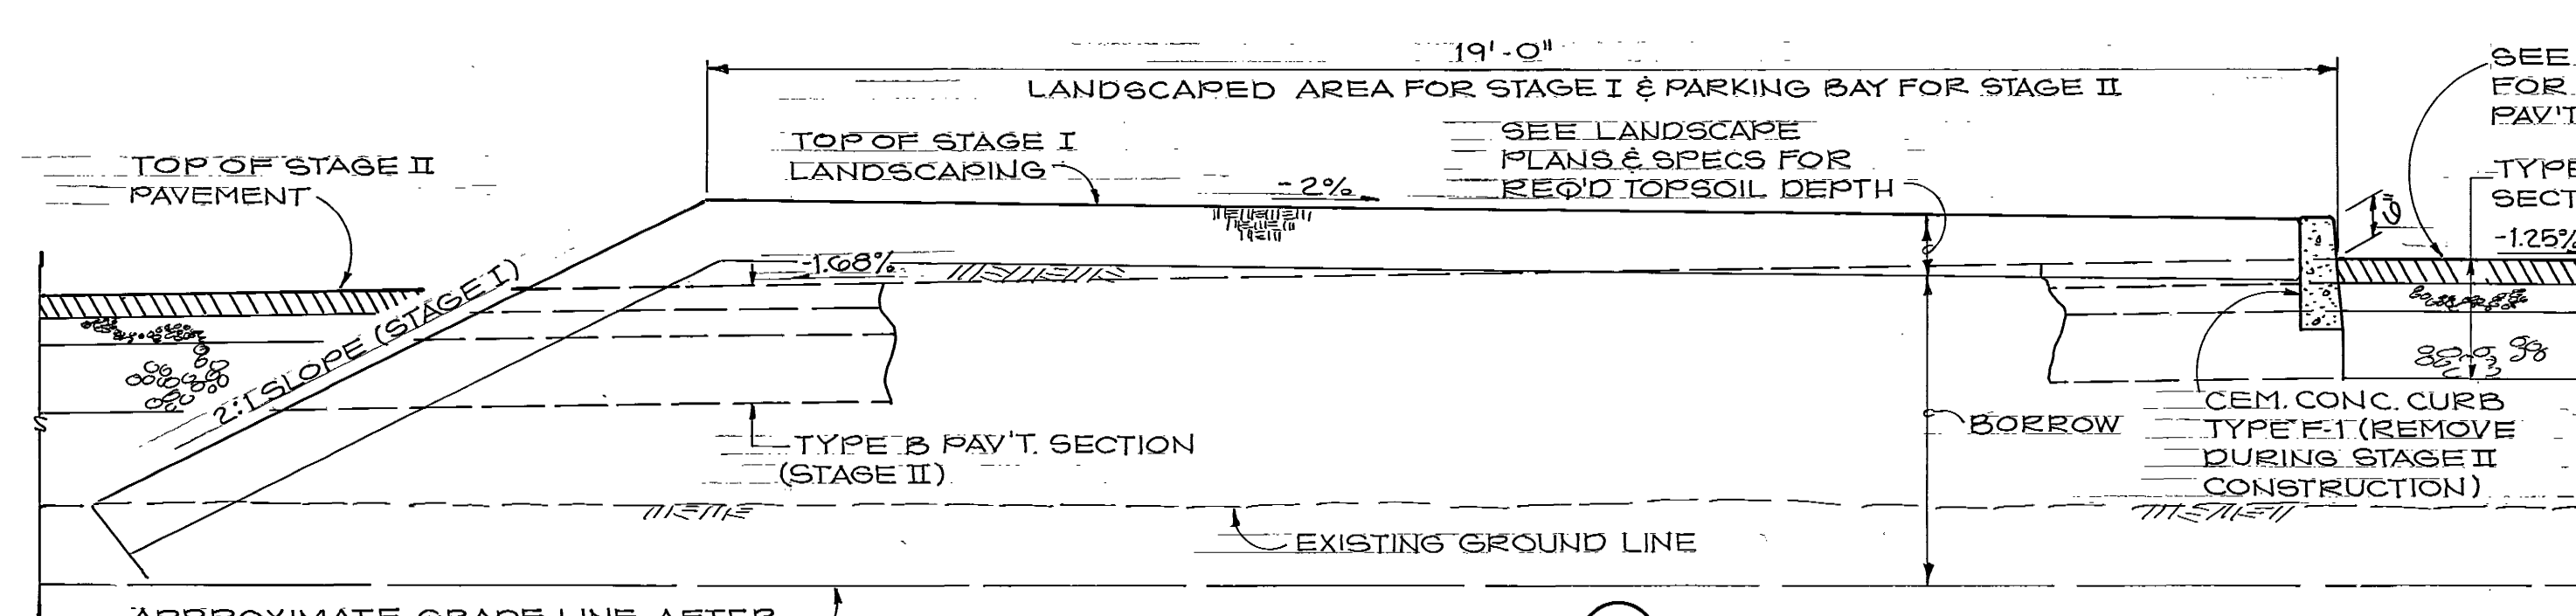


SECTION D
SCALE 1"=2'

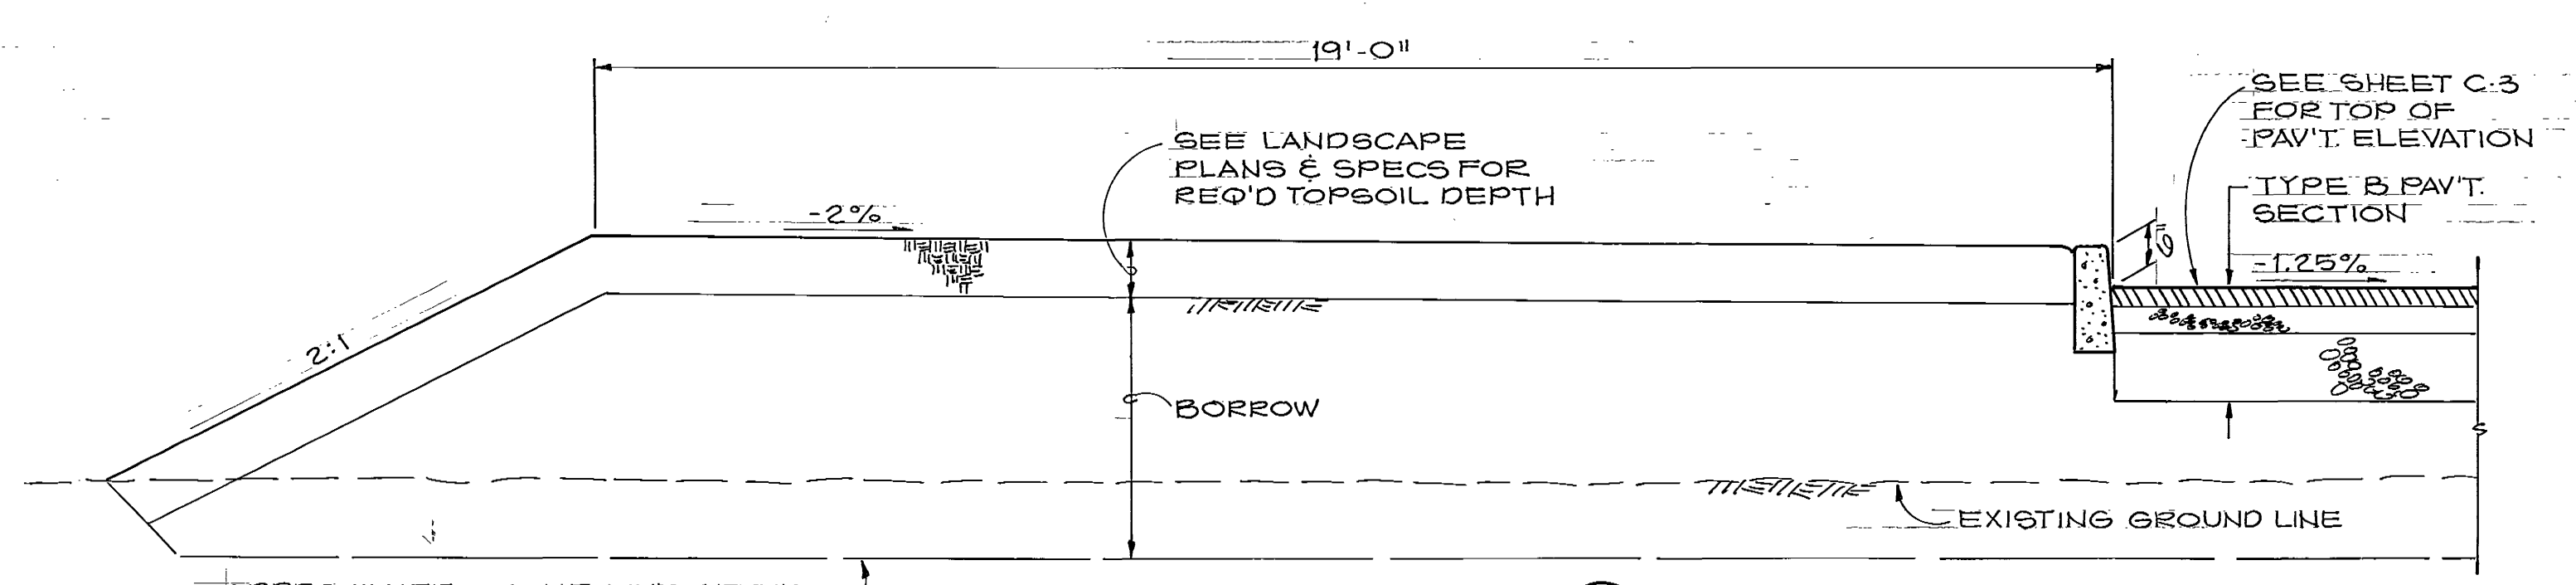


SECTION E
SCALE 1"=2'

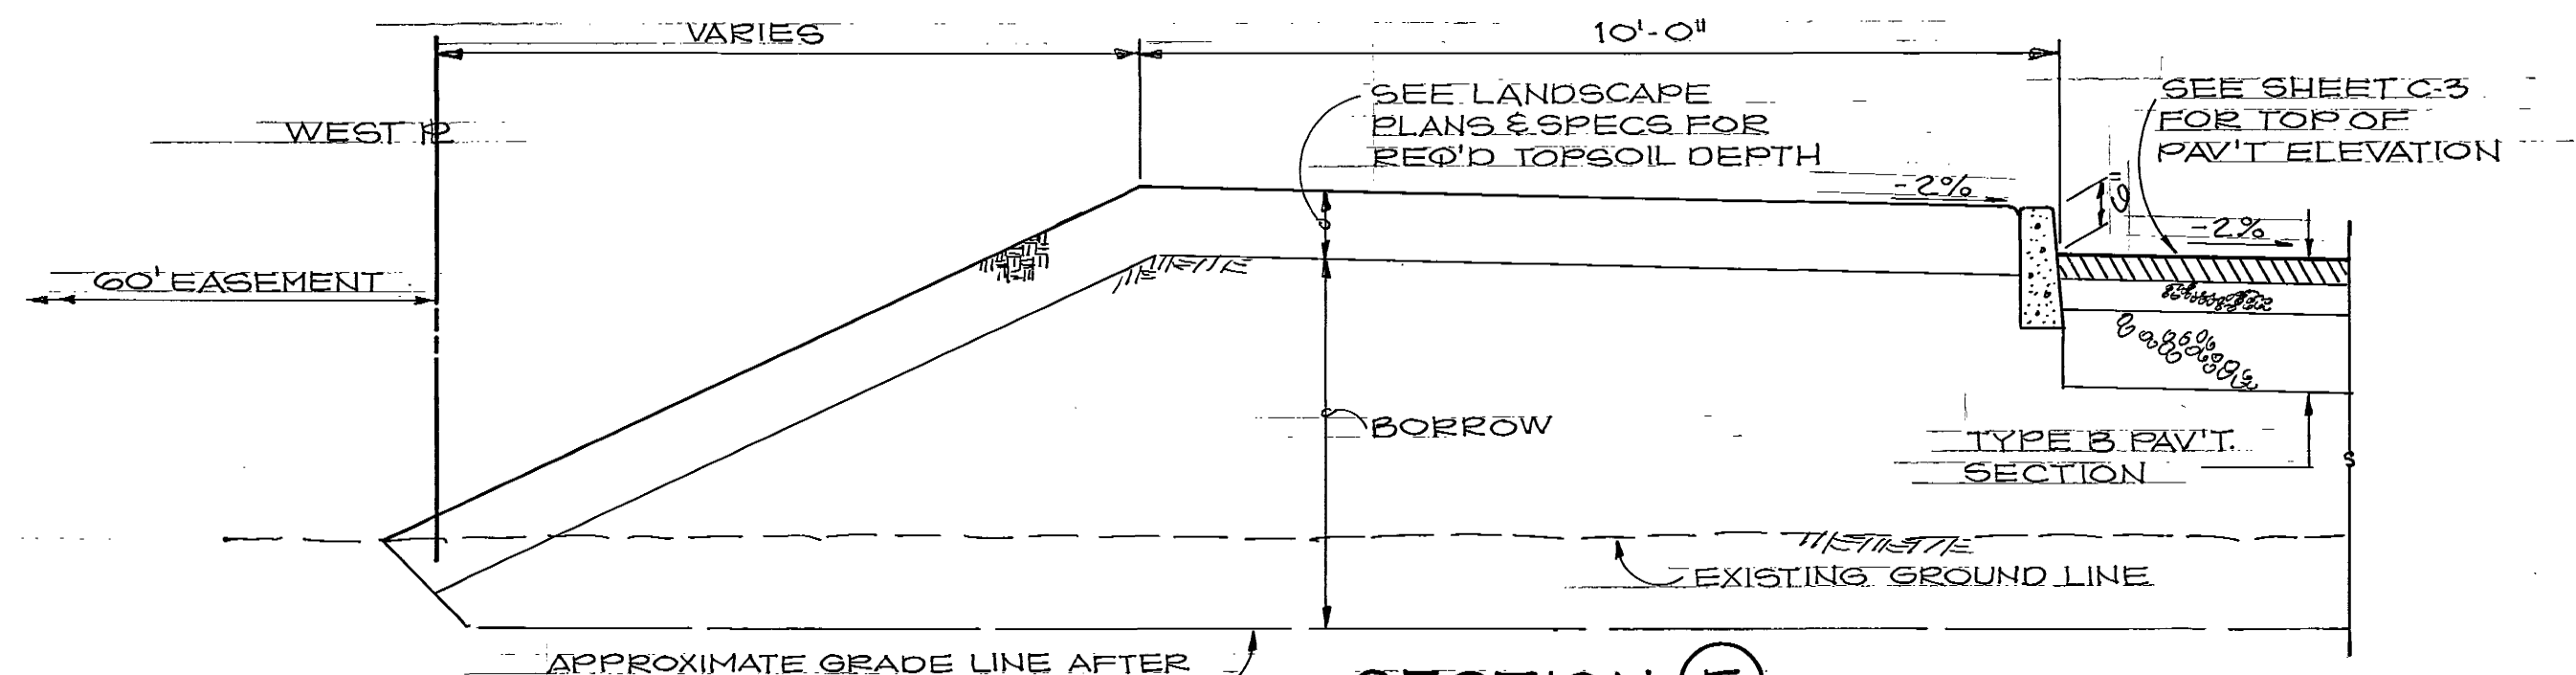

SECTION F
SCALE 1"=2'

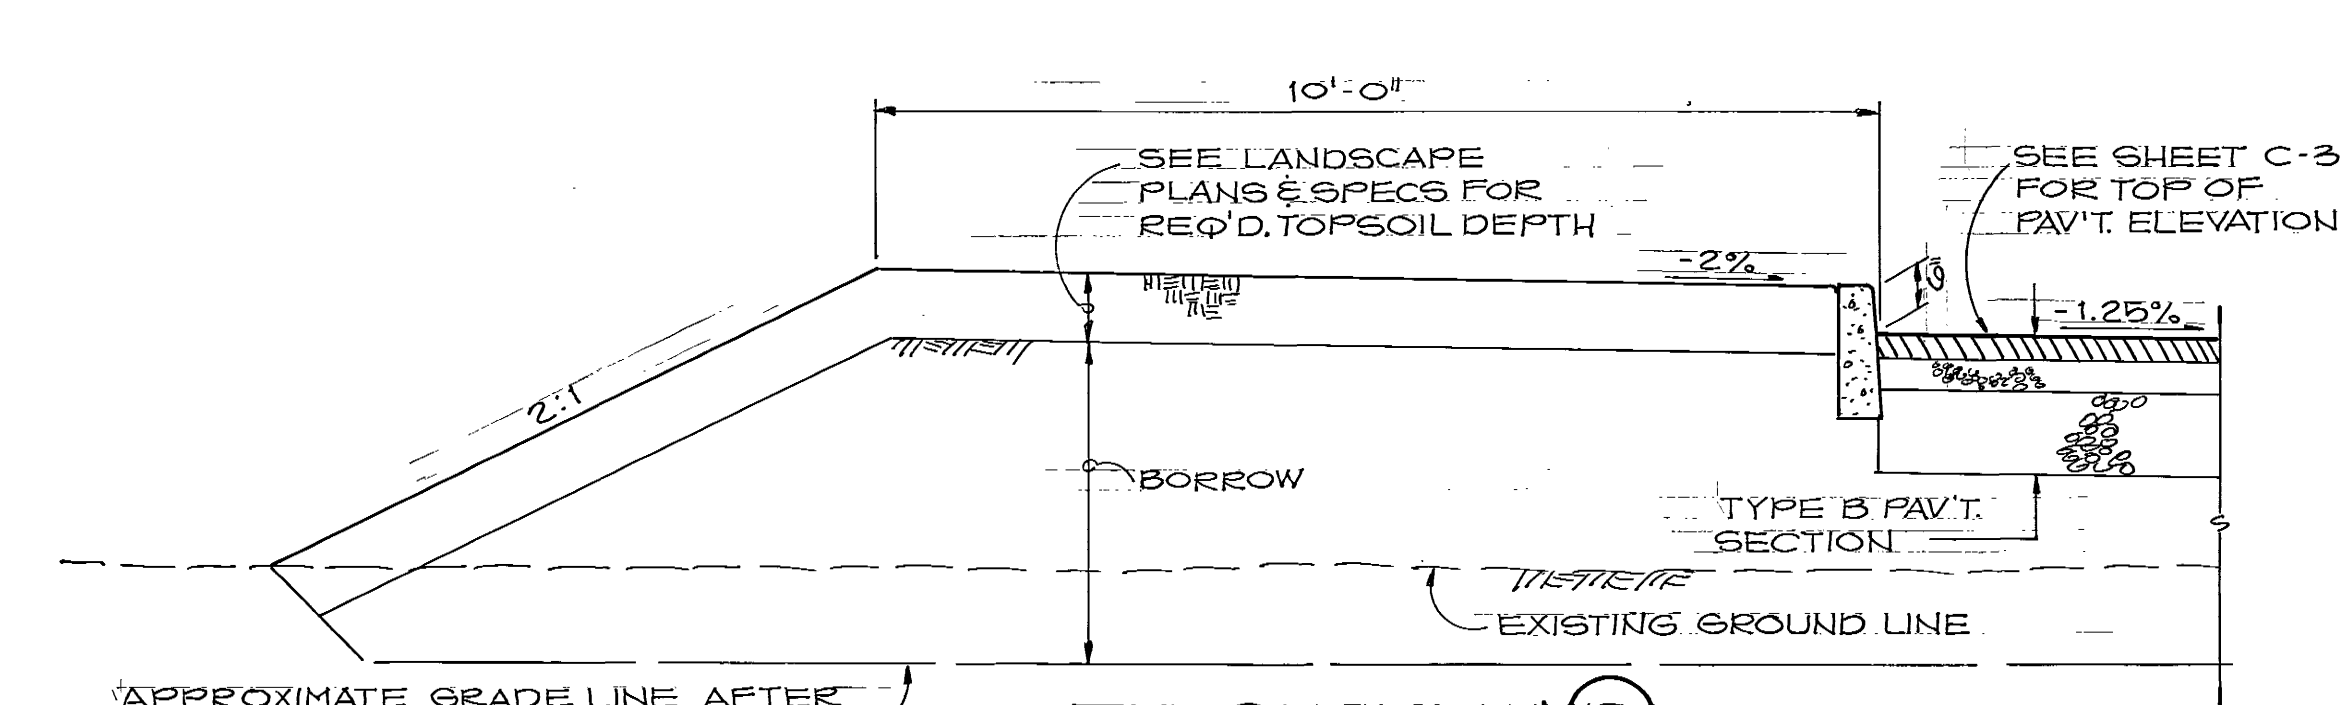


SECTION G
SCALE 1"=2'

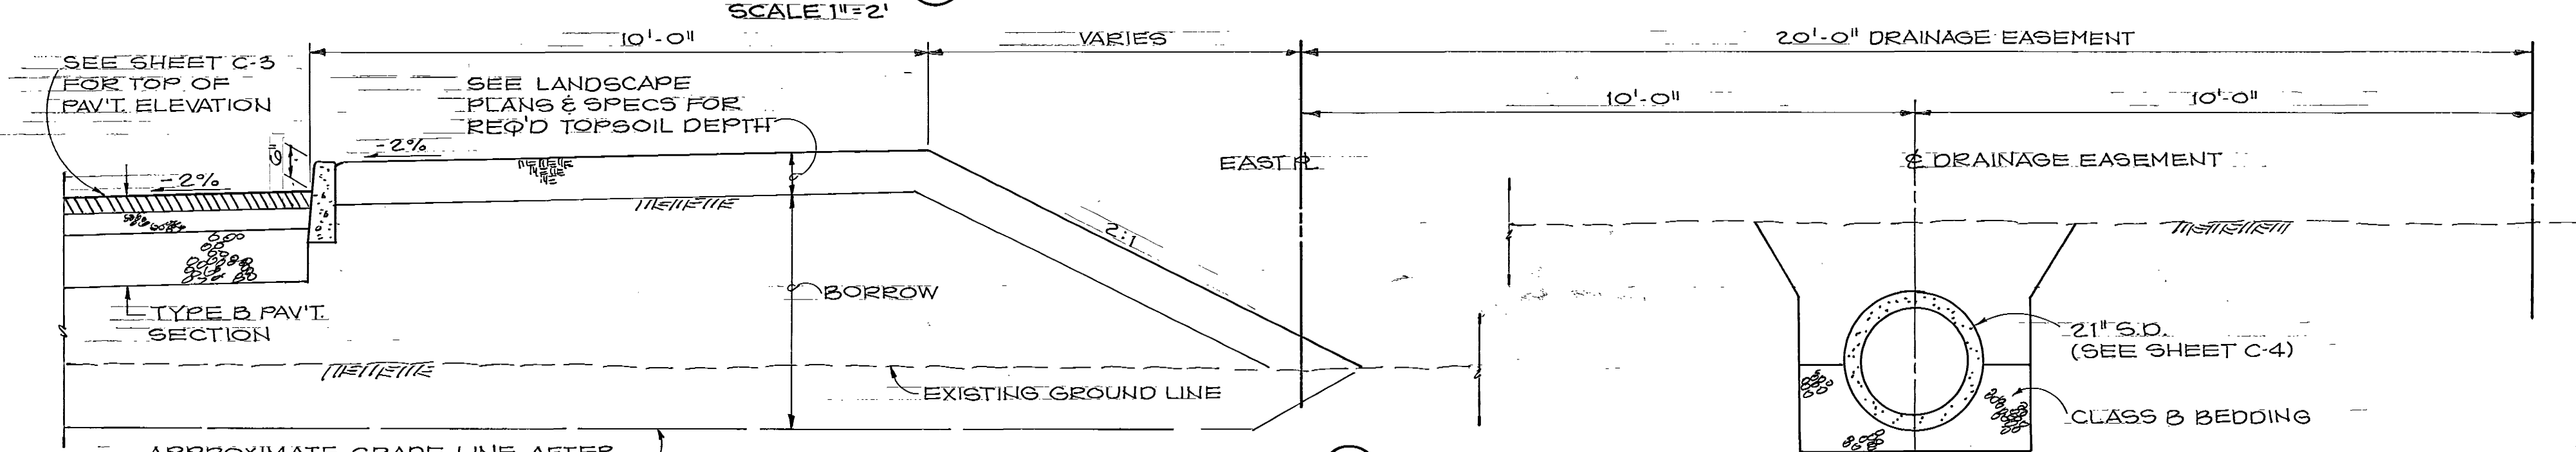

SECTION H
SCALE 1"=2'

"AS CONSTRUCTED"
FEB. 10 1978

MUNICIPALITY OF METROPOLITAN SEATTLE — TRANSIT DIVISION			
AUBURN PARK-AND-RIDE FACILITY 111199			
TYPICAL SECTIONS			
VICTOR O. GRAY & COMPANY, INC. REGISTERED ENGINEERS & PLANNERS		Date	9/76
RICHARD HAAG & ASSOCIATES LANDSCAPE ARCHITECTS		File No.	7605
JD 21 — LIGHTING ENGINEERS		Sheet	10 of 27
R. F. H. Designed	6/76 Date	Municipality of Metropolitan Seattle Approved <i>[Signature]</i> Date <i>12/29/76</i>	
A. O. K. Drawn	7/76 Date		
		C-10	
		Sheet Number	

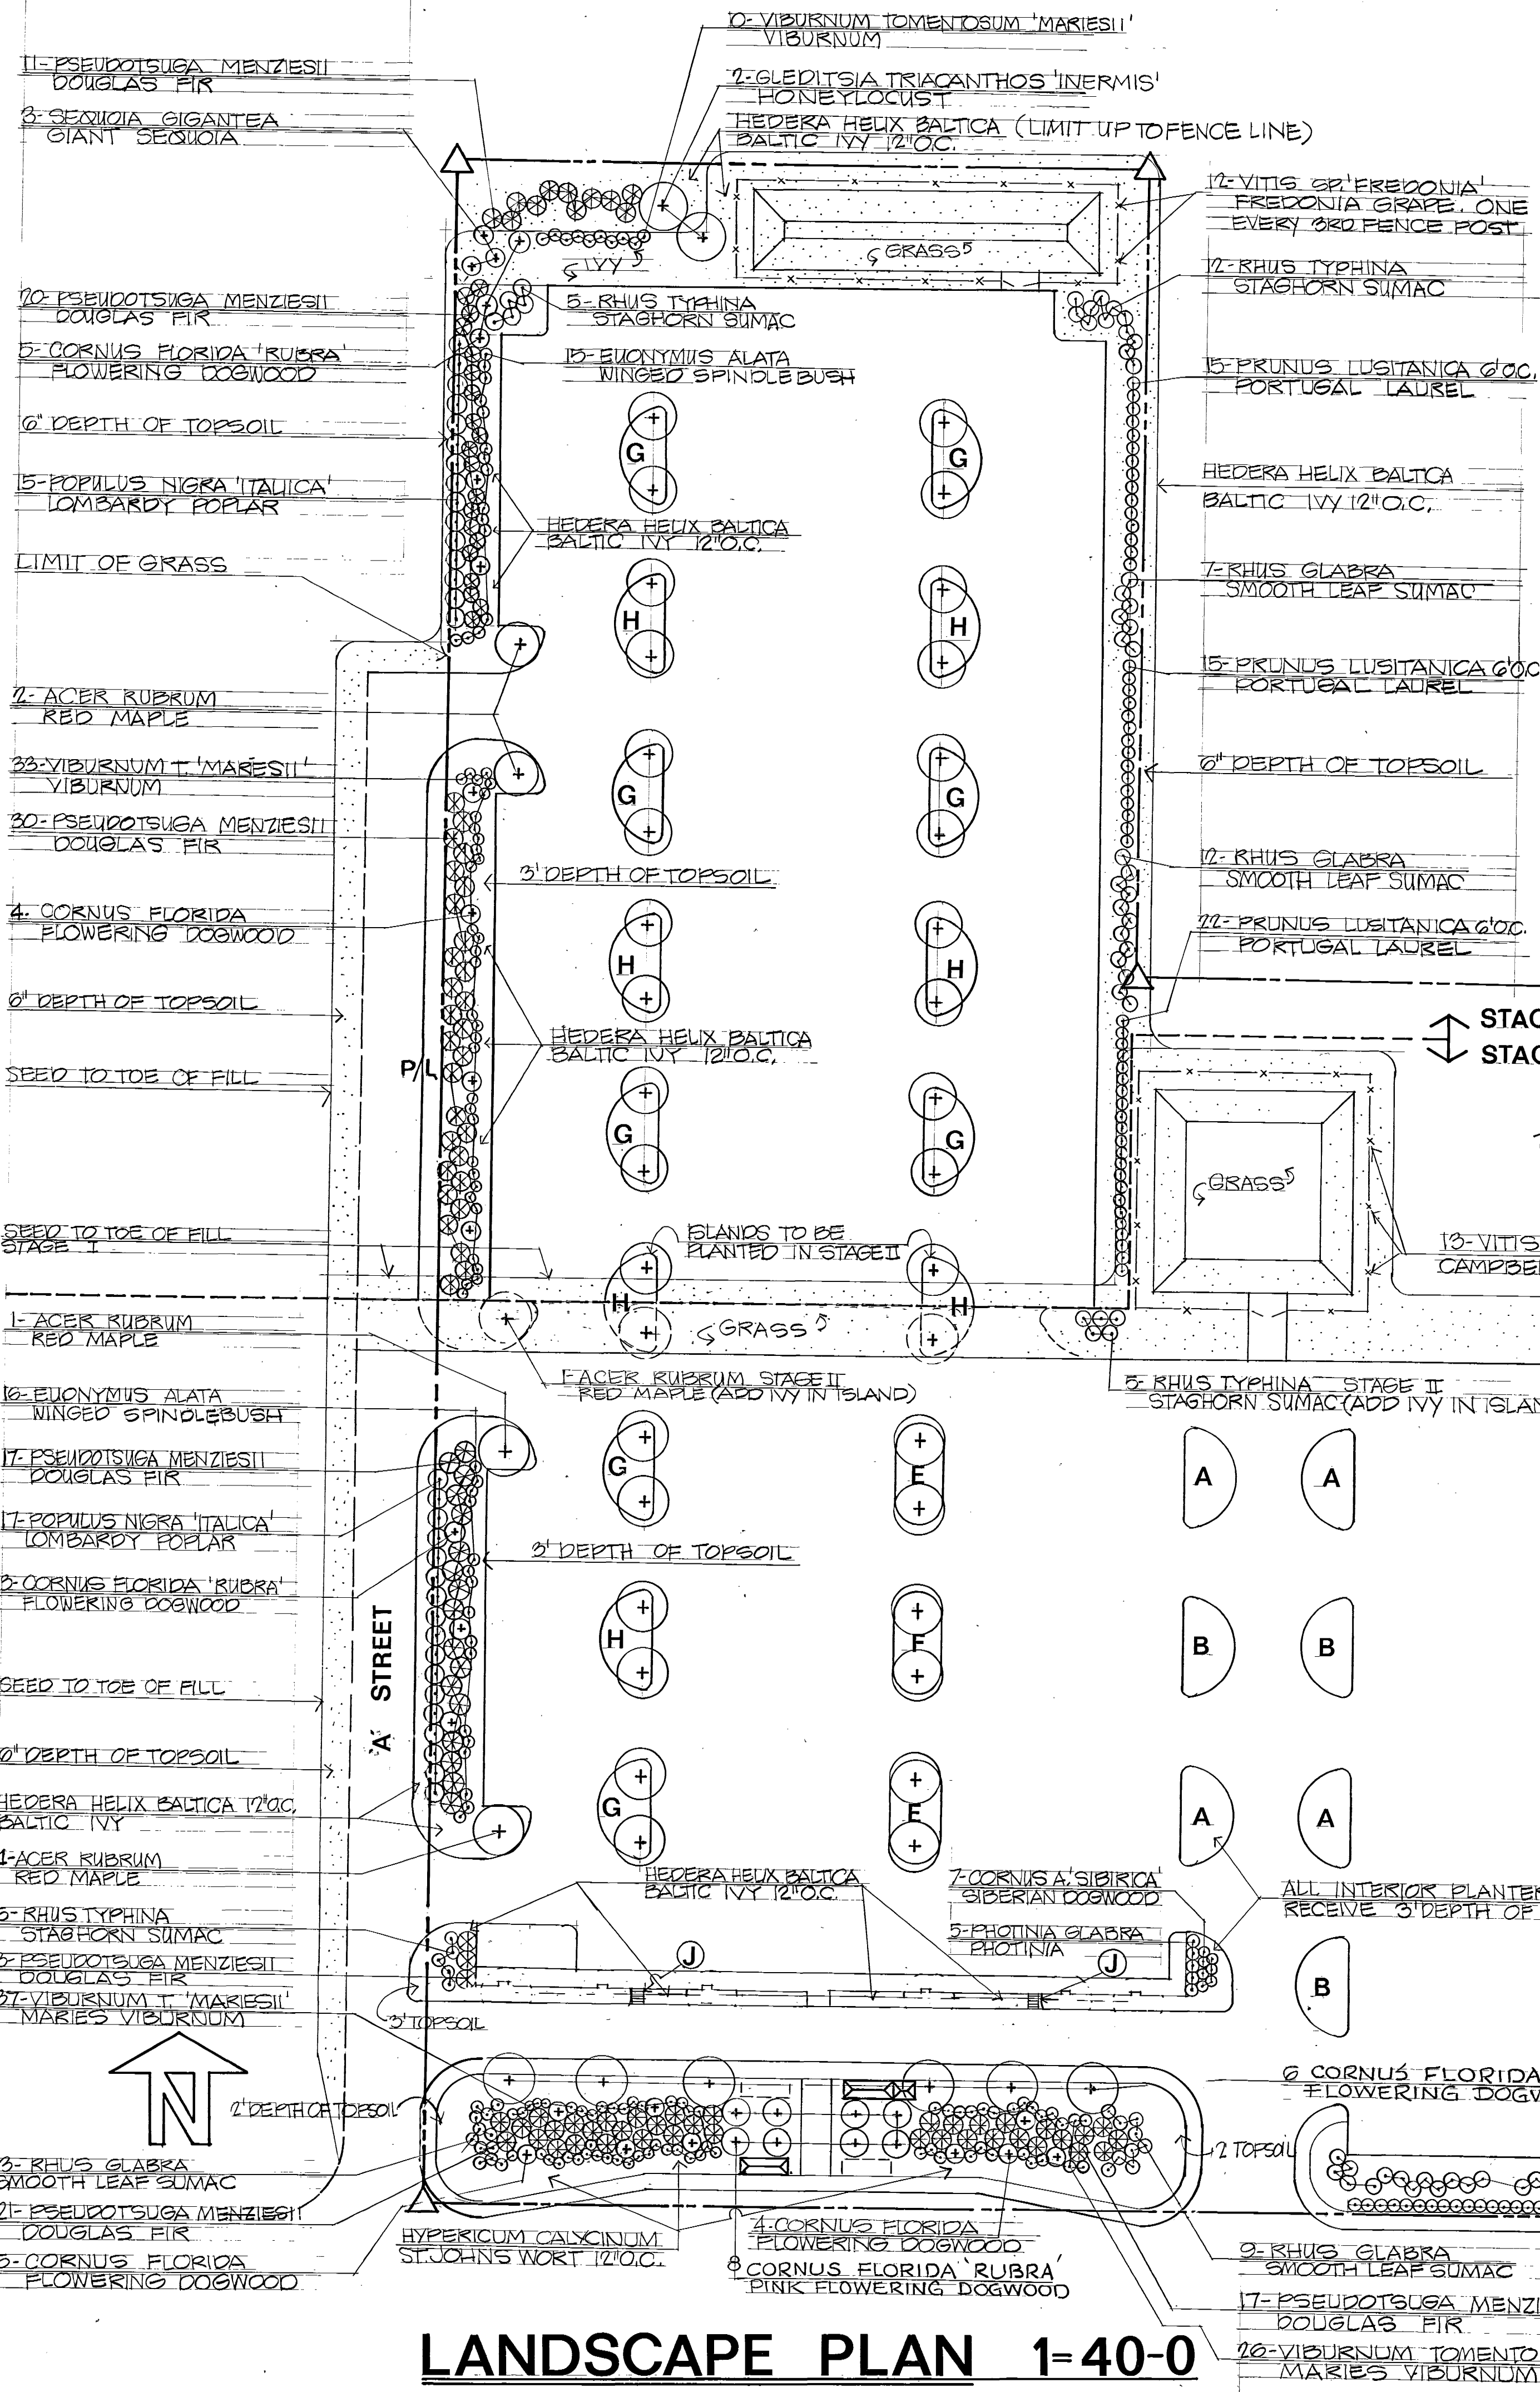

PLANT LIST

STAGE I	STAGE II	BOTANICAL NAME	COMMON NAME	SPECIFICATIONS
TREES				
18	27	ACER RUBRUM	RED MAPLE	2 1/2" CAL., 12'-14' HT., TYPE 1, B+B.
9	4	CORNUS FLORIDA	WHITE FLOWERING DOGWOOD	5'-6' HT., 8 OR MORE BRANCHES, TYPE 4, B+B.
11	5	CORNUS FLORIDA 'RUBRA'	PINK FLOWERING DOGWOOD	5'-6' HT., 8 OR MORE BRANCHES, TYPE 4, B+B.
17	15	POPULUS NIGRA 'ITALICA'	LOMBARDY POPLAR	1 1/4" CAL., 8'-10' HT., TYPE 1, B+B.
58	61	PSEUDOTSUGA MENZIESII	DOUGLAS FIR	4'-5' HT., 2 1/2'-3' SPREAD, TYPE 4, B+B.
-	2	LEDITSIA TRIACANTHOS 'INERMIS'	THORNLESS HONEYLOCUST	2 1/2" CAL., 12'-14' HT., TYPE 1, B+B.
-	3	SEQUOIA GIGANTEA	GIANT SEQUOIA	4'-5' HT., 2 1/2'-3' SPREAD, TYPE 4, B+B.
SHRUBS				
275	162	CORNUS ALBA 'SIBIRICA'	SIBERIAN DOGWOOD	2'-3' HT., 4 CANES OR MORE, TYPE 2, BR.
226	162	CORNUS STOLONIFERA 'FLAVIRAMEA'	YELLOW TWIG DOGWOOD	2'-3' HT., 4 CANES OR MORE, TYPE 2, BR.
10	15	EUONYMUS ALATA	WINGED SPINDLEBUSH	2'-3' HT., 2 CANES OR MORE, TYPE 4, BB
173	72	PHOTINIA GLABRA	PHOTINIA	18"-24" HT. MIN. SPREAD 12" TYPE 4, BB.
68	19	RHUS GLABRA	SMOOTH LEAF SUMAC	8'-4' HT., 1 OR MORE CANES, 1/2" CAL., TYPE 5, BB.
5	22	RHUS TYPHINA	STAGHORN SUMAC	3'-4' HT., 1 OR MORE CANES, 1/2" CAL., TYPE 5, B+B.
63	43	VIBURNUM TOMENTOSUM 'MARESII'	MARIES VIBURNUM	2'-3' HT., 3 CANES OR MORE, TYPE 3, B+B.
105	52	PRUNUS LUSITANICA	PORTUGAL LAUREL	2 1/2'-3' HT. MIN. SPREAD 20", TYPE 5, B+B.
GROUND COVER				
36,600	32,400	HEDERA HELIX BALTICA	BALTIC IVY	FLATS, WELL ROOTED CUTTINGS
13		VITIS SP. 'CAMPBELLS EARLY'	CAMPBELLS EARLY GRAPE	2 YEAR, NUMBER 1, TYPE 2
12,200		HYPERICUM CALYCINUM	ST. JOHNS WORT	FLATS, WELL ROOTED CUTTINGS
1.9 ACRES	.2 ACRES	VITIS SP. 'FRECONIA'	FREDONIA GRAPE	2 YEAR, NUMBER 1, TYPE 2
		GRASS	GRASS	SEE SPEC'S.


LANDSCAPE PLAN 1-40-0

15th STREET N.E.


"AS CONSTRUCTED"
FEB. 15, 1978




MUNICIPALITY OF METROPOLITAN SEATTLE -- TRANSIT DIVISION AUBURN PARK-AND-RIDE FACILITY LANDSCAPE PLAN	
VICTOR O. GRAY & COMPANY, INC. CONSULTING ENGINEERS & PLANNERS RICHARD HAAG & ASSOCIATES LANDSCAPE ARCHITECTS JD 21 -- LIGHTING ENGINEERS	Date 9/76 File No. 7605 Sheet 11 of 27
KN Designed KN Drawn	8/76 Date 8/76 Date Approved Date
Municipality of Metropolitan Seattle Approved Date	L-1 Sheet Number

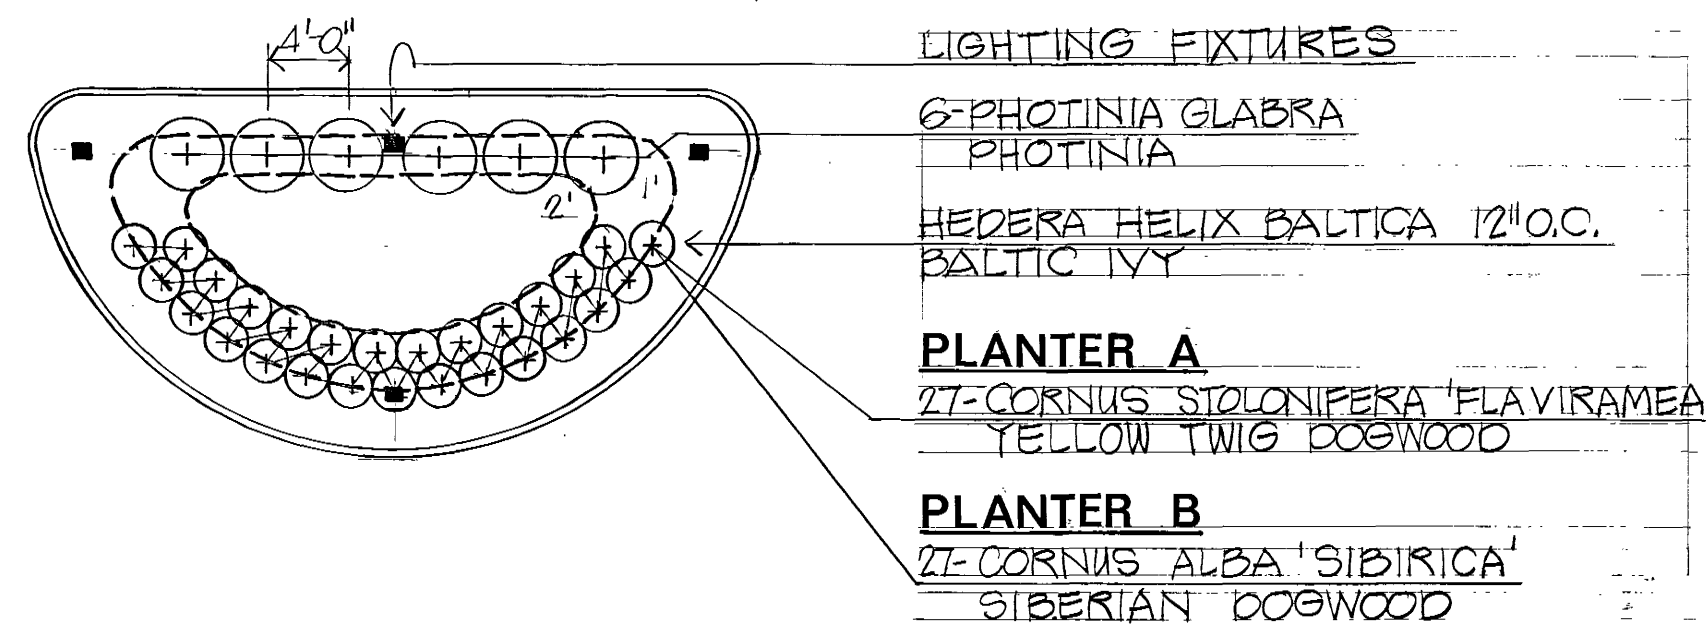


PLANTERS A & B SCALE 1"=10'-0"

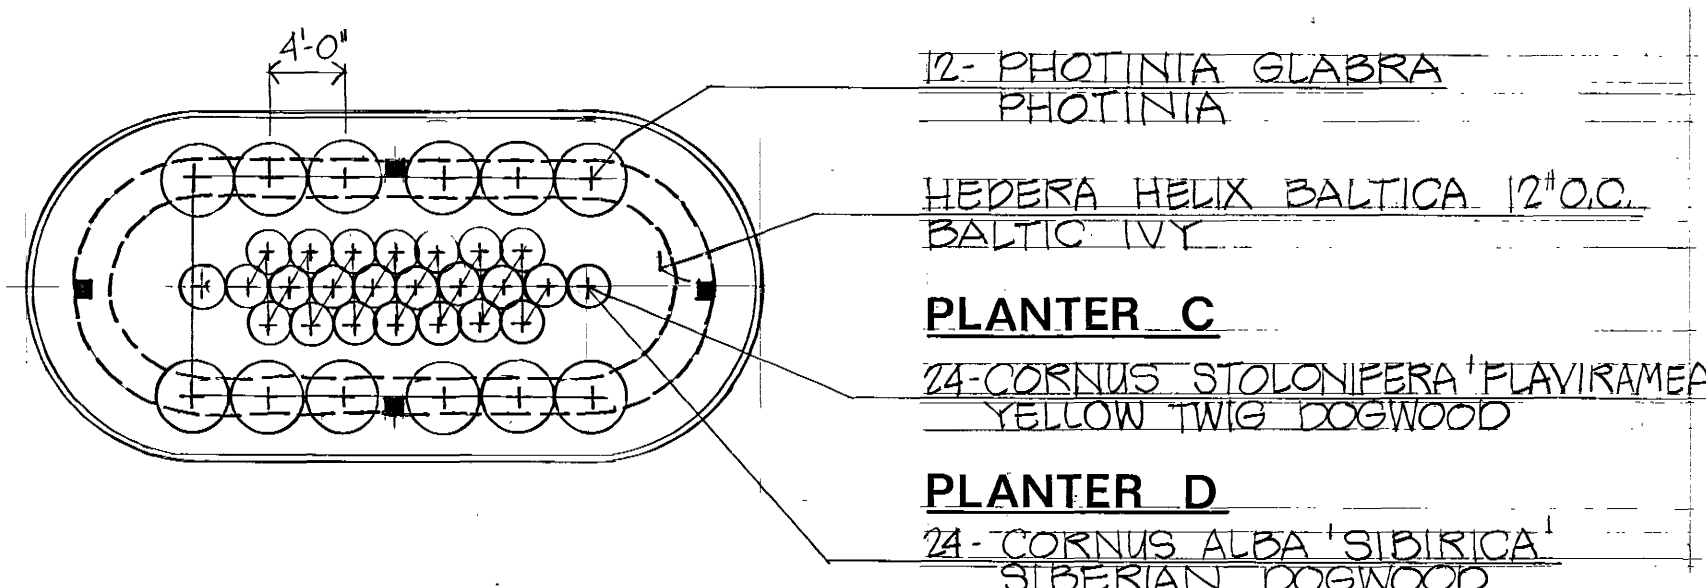


PLANTERS C & D SCALE 1"=10'-0"

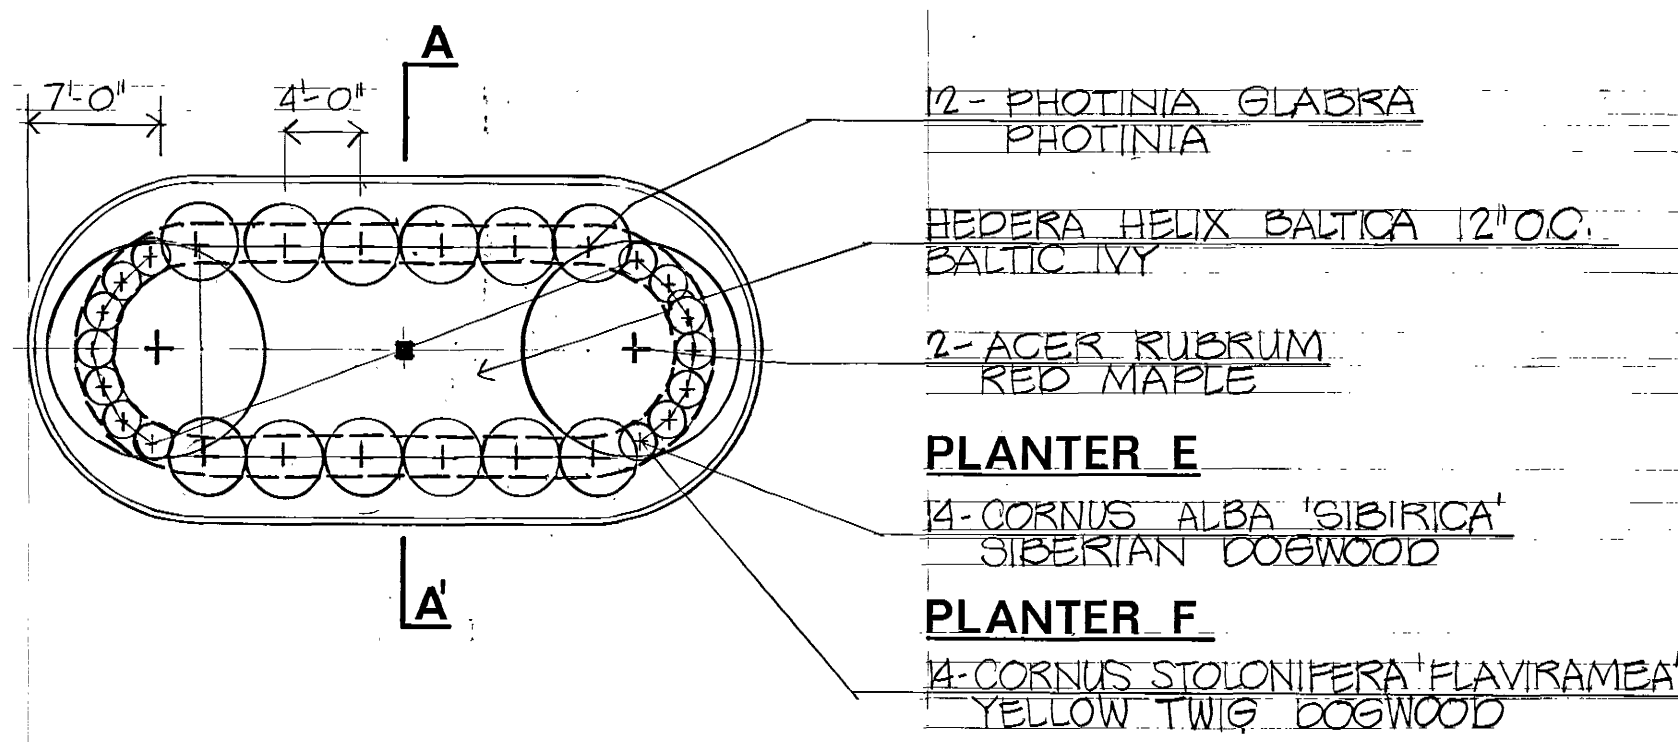


PLANTER E & F SCALE 1"=10'-0"

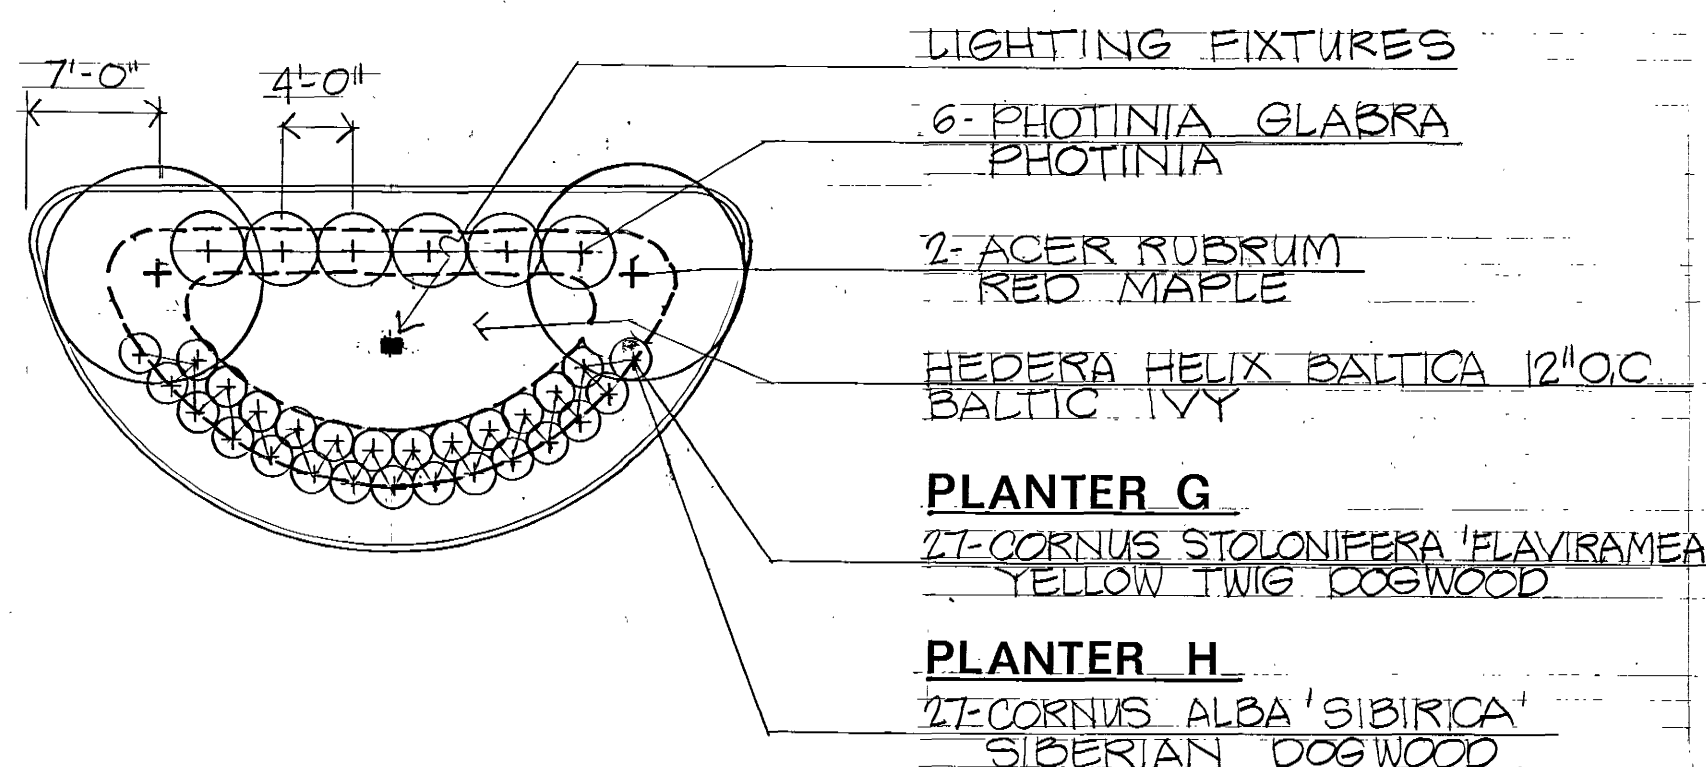


PLANTERS G & H SCALE 1"=10'-0"

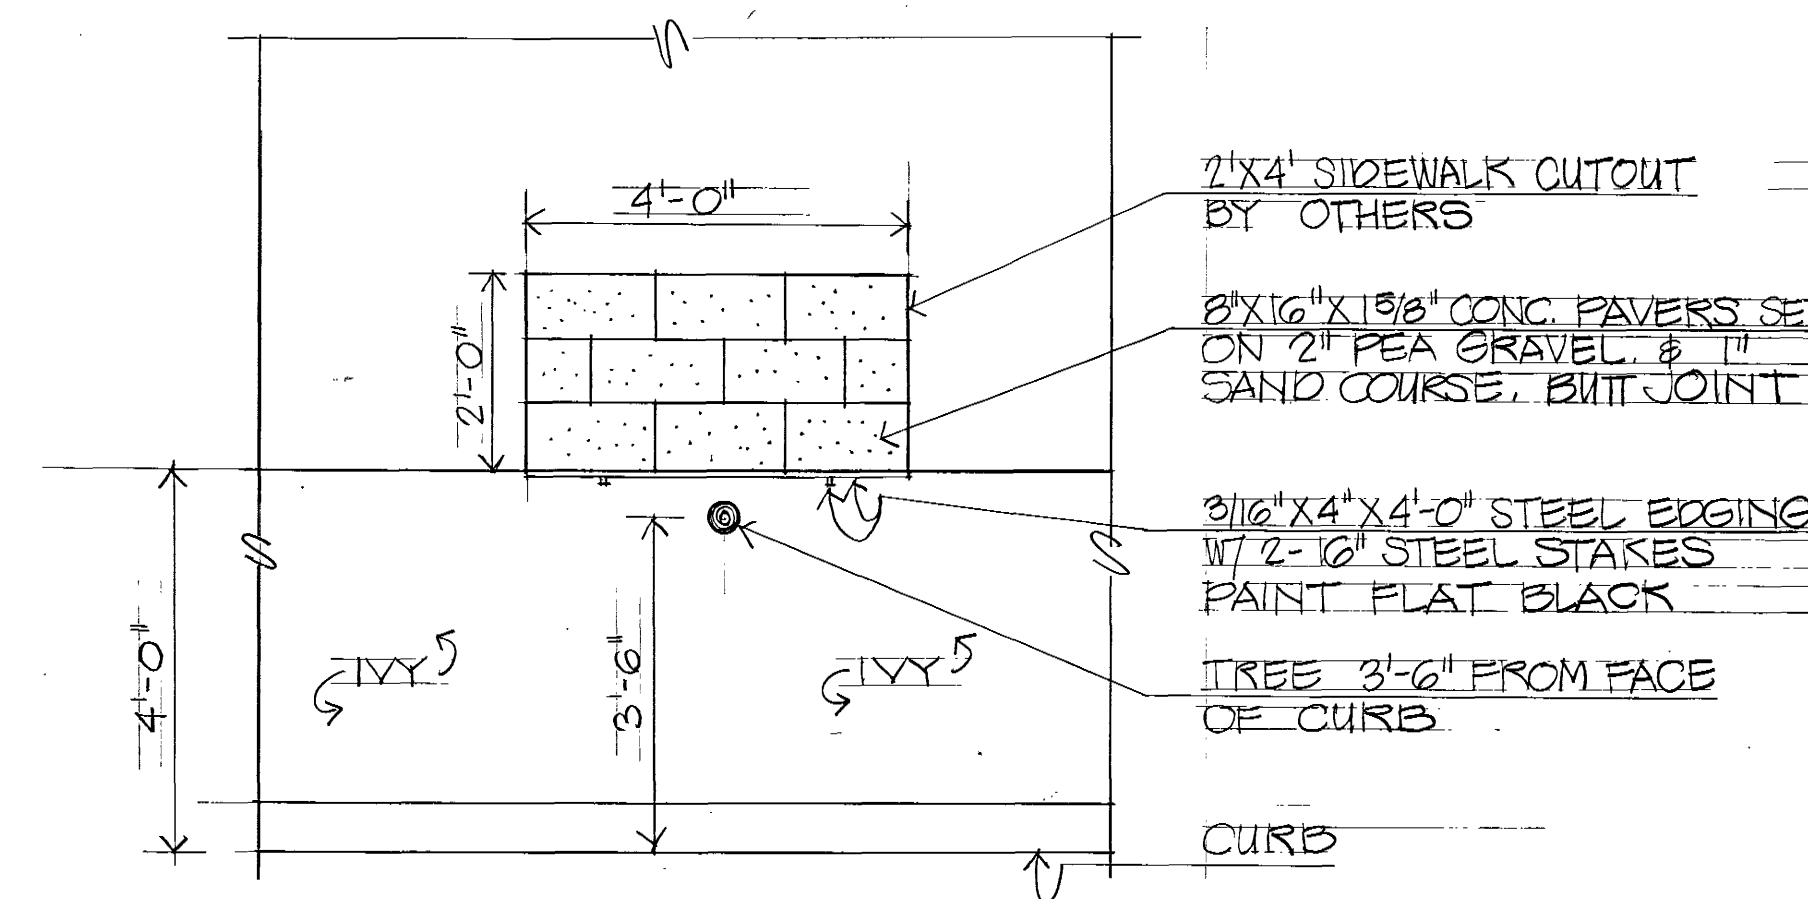


TREE CUTOUT I SCALE 1/2"=1'-0"

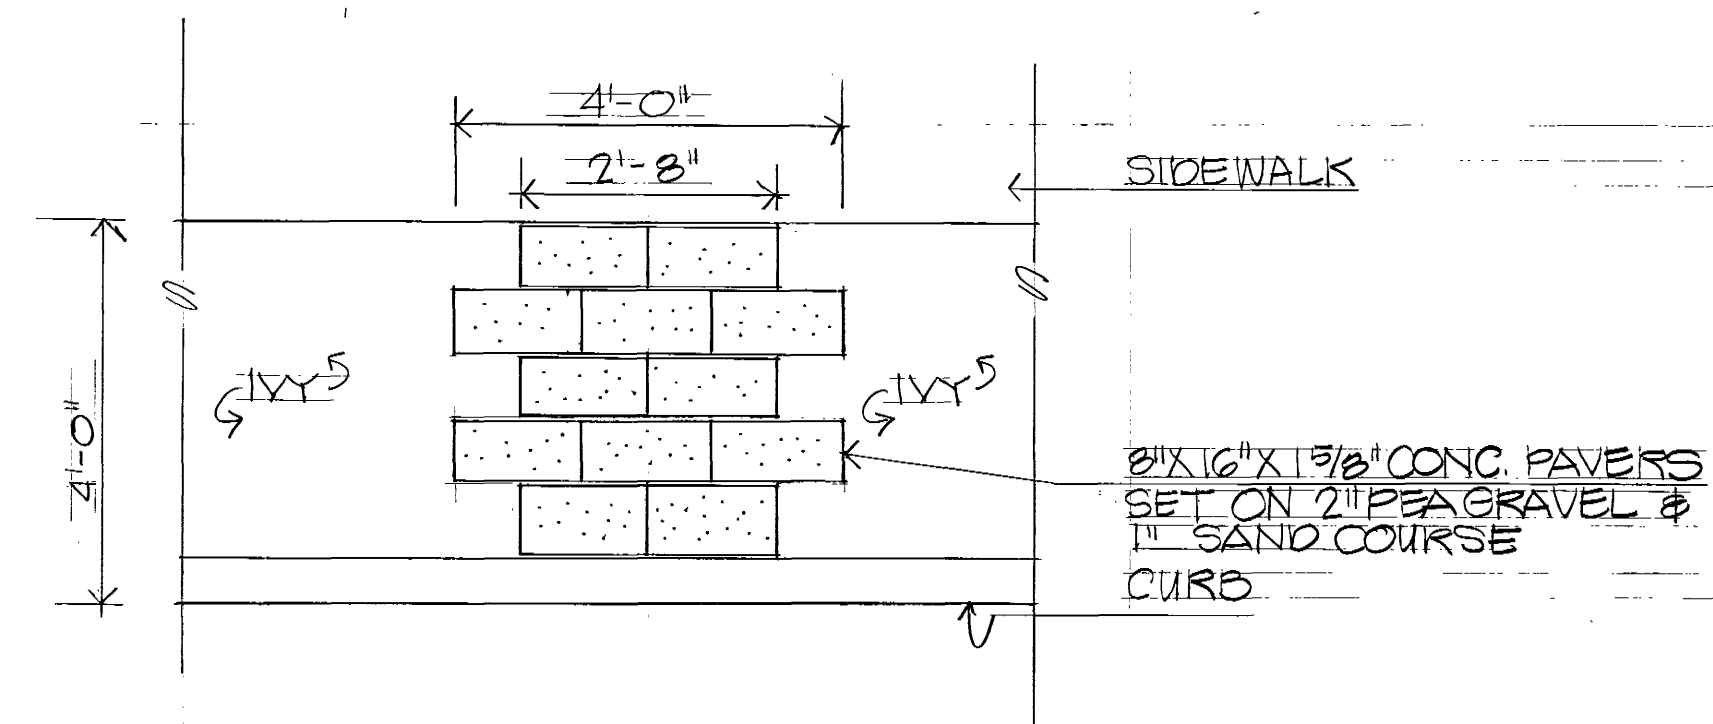


PAVER WALK J SCALE 1/2"=1'-0"

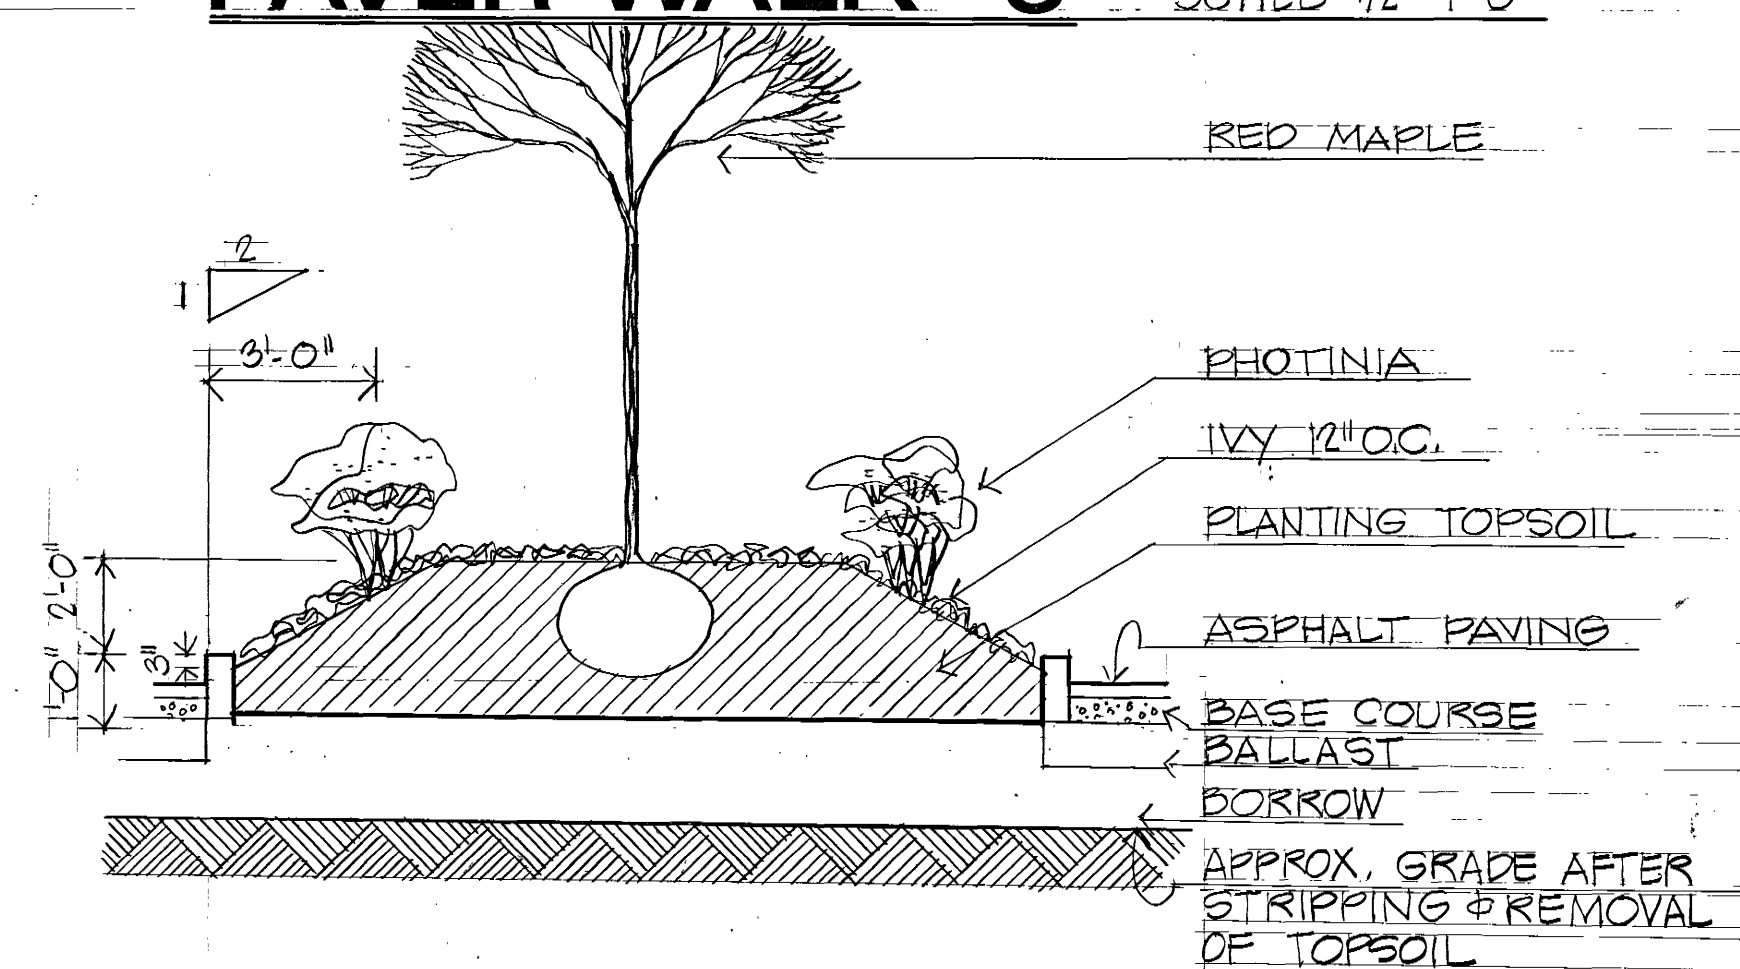


SECTION A-A SCALE 1/4"=1'-0"

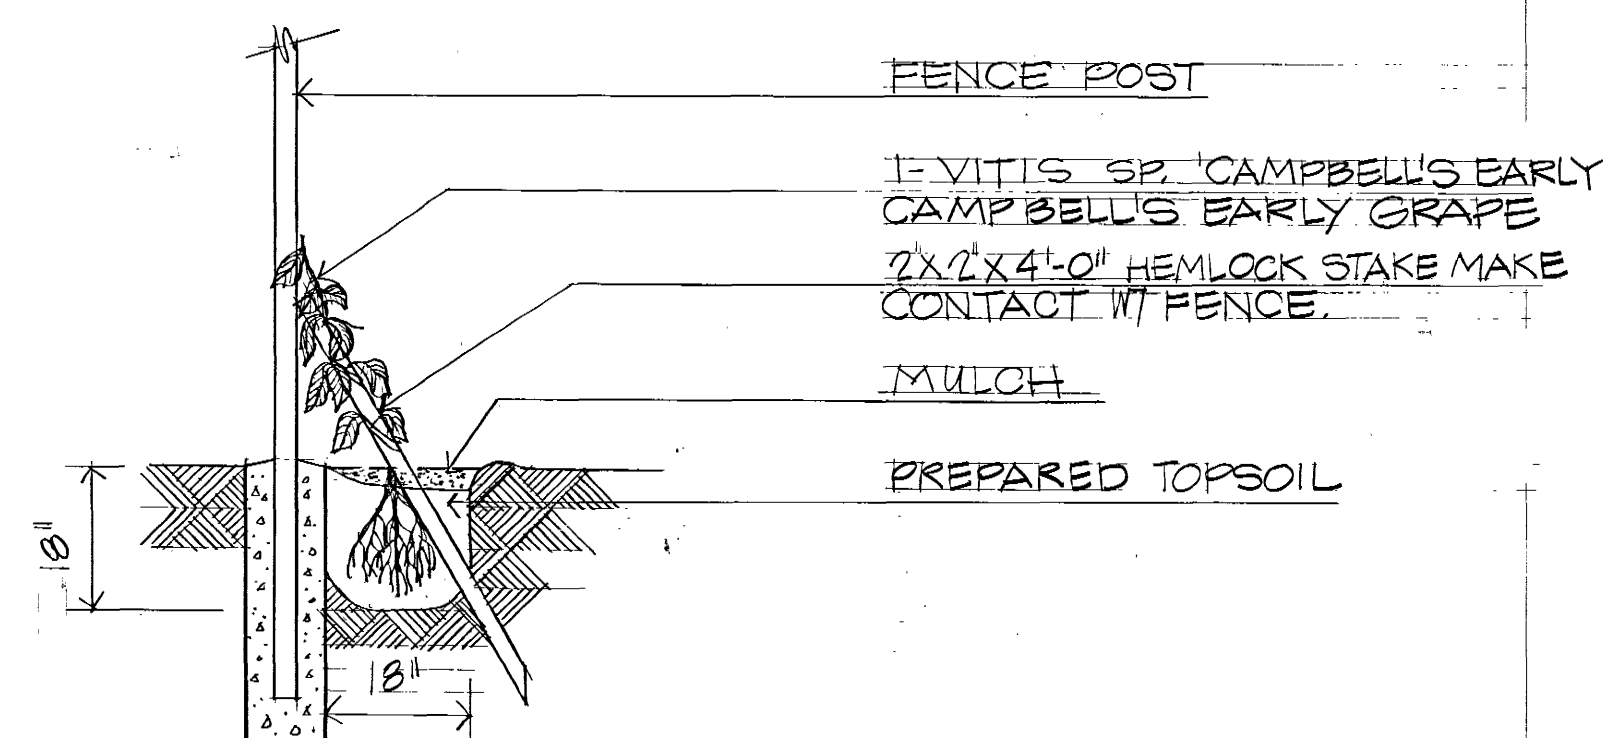

VINE STAKING SCALE 1/2"=1'-0"

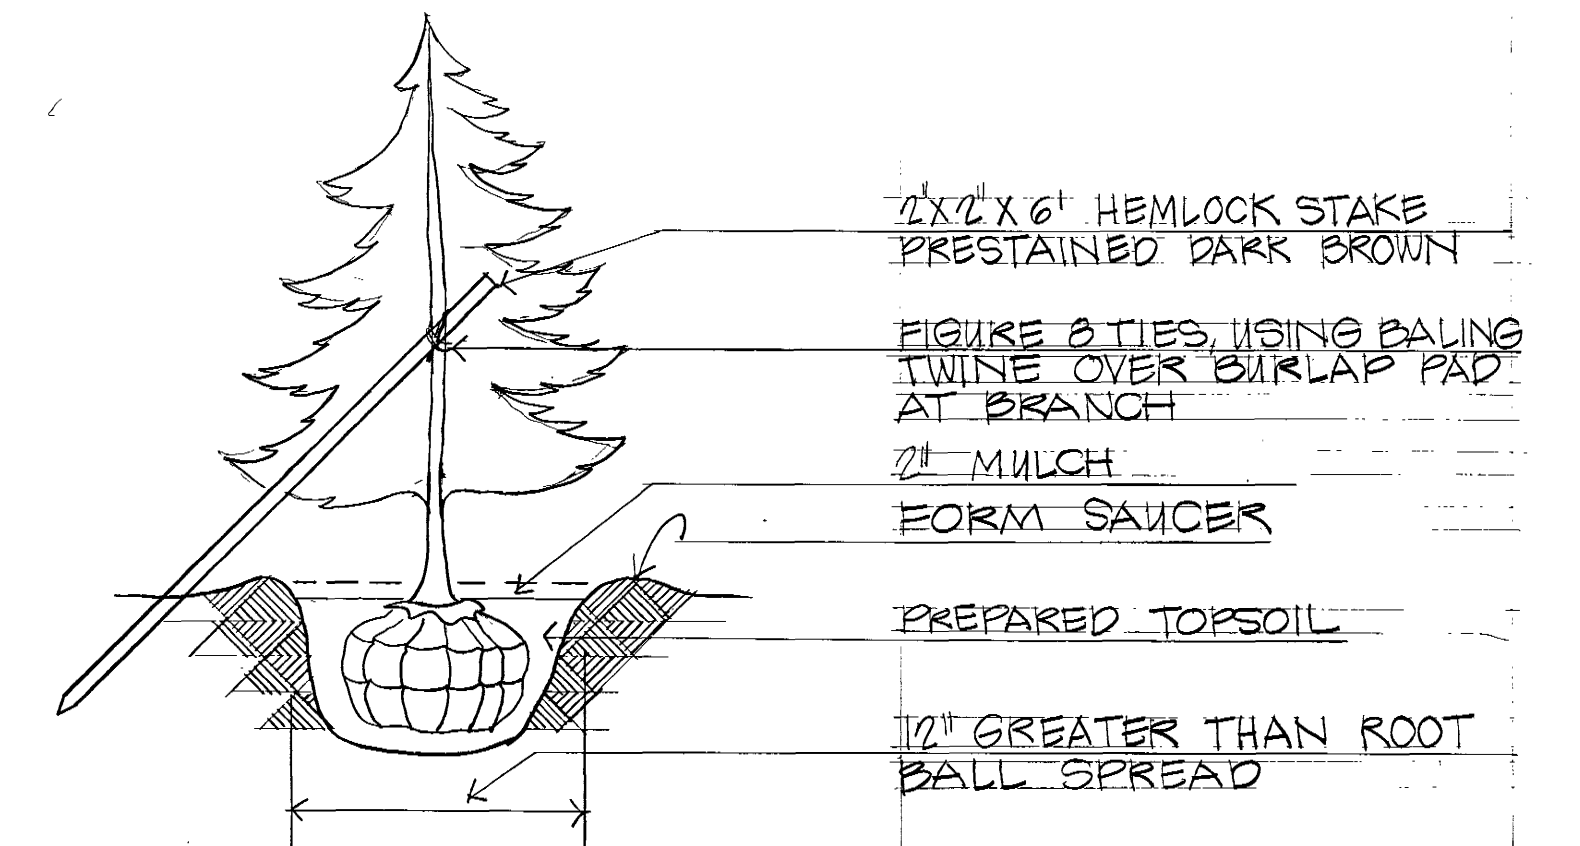

EVERGREEN STAKING SCALE 1/2"=1'-0"

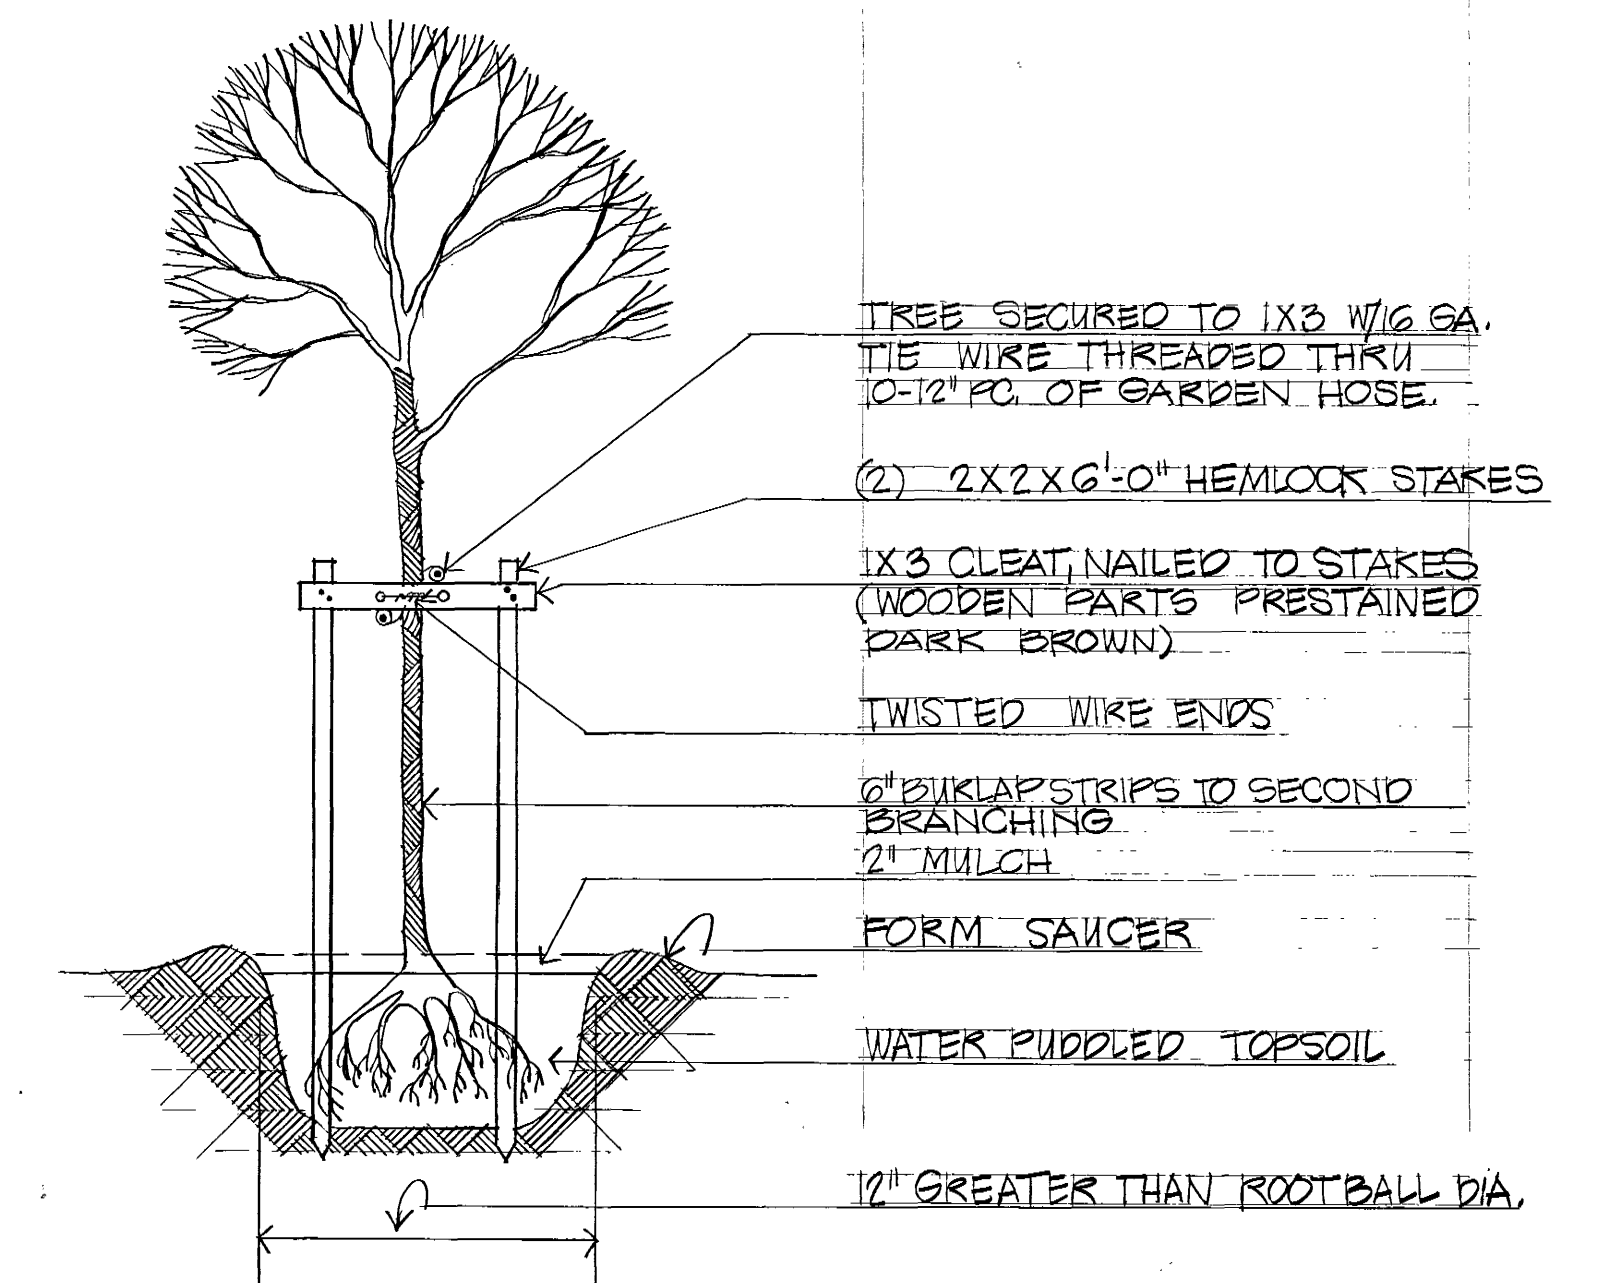



DEC. TREE STAKING SCALE 1/2"=1'-0"

111201



MUNICIPALITY OF METROPOLITAN SEATTLE — TRANSIT DIVISION			
AUBURN PARK-AND-RIDE FACILITY			
LANDSCAPE DETAILS			
VICTOR O. GRAY & COMPANY, INC. CONSULTING ENGINEERS & PLANNERS RICHARD HAAG & ASSOCIATES LANDSCAPE ARCHITECTS JD 21 — LIGHTING ENGINEERS		Date 9/76 File No. 7605 Sheet 12 of 27	
KN Designed KN Drawn	8/76 Date 8/76 Date	Municipality of Metropolitan Seattle Approved Date	L-2 Sheet Number


IRRIGATION SCHEDULE				
SYMBOL	DESCRIPTION	PSI	GPM	R' Δ
•	RAINBIRD 131 66-F STREAM SPRAY	30	2.1	22' 15'
•	RAINBIRD 131 66-H STREAM SPRAY	30	1.2	22' 15'
•	RAINBIRD 131 66-Q STREAM SPRAY	30	0.8	22' 15'
•	RAINBIRD 2400-F	30	3.8	20' 14.5'
•	RAINBIRD 2400-TD	30	3.1	4' 14.5'
•	RAINBIRD 2400-H	30	2.5	4' 14.5'
•	RAINBIRD 2400-T	30	1.9	4' 14.5'
•	RAINBIRD 2400-Q	30	1.5	4' 14.5'
•	RAINBIRD 2400-FLT-F	35	2.7	20' 10' ±
•	RAINBIRD 2400-FLT-H	35	1.25	10' 10' ±
•	RAINBIRD EF ELECTRIC REMOTE CONTROL VALVE			
•	3" GATE VALVE, CRANE # 461 OR EQUAL			
•	3" MUELLER H-2310 PRESSURE REDUCING VALVE OR EQUAL			
•	3" FISCO 805 DOUBLE CHECK VALVE ASSEMBLY			
•	RAINBIRD RC-8A & RC-11 AUTOMATIC CONTROLLERS			
•	CONTROLLER CIRCUIT NUMBER			
•	VALVE SIZE			
•	GALLONS PER MINUTE			
•	CLASS 200 SDR 21 PVC PIPE (LATERAL)			
•	SCHEDULE 40 PVC PIPE (MAINLINE)			
•	TRANSITE SLEEVE (SIZE AS SPECIFIED)			
•	RAINBIRD 2400 CG	30	1.3	7' x 36' 15'
•	RAINBIRD 2400 EB	30	0.7	7' x 18' 15'

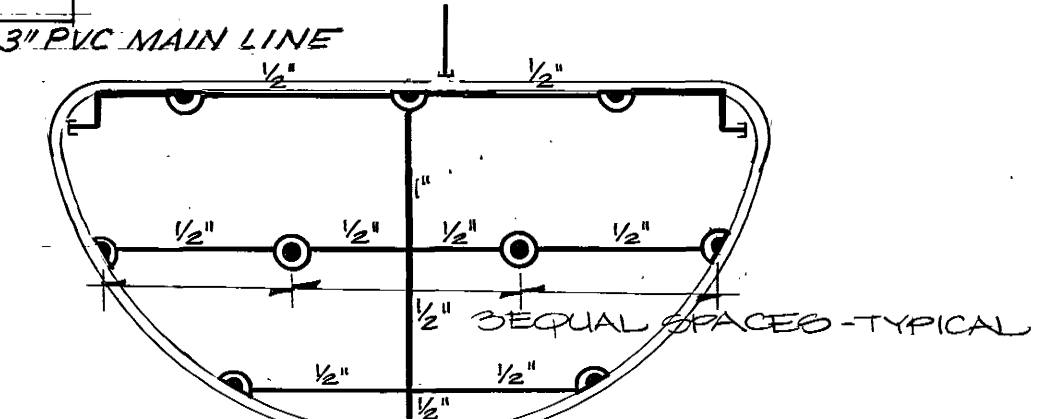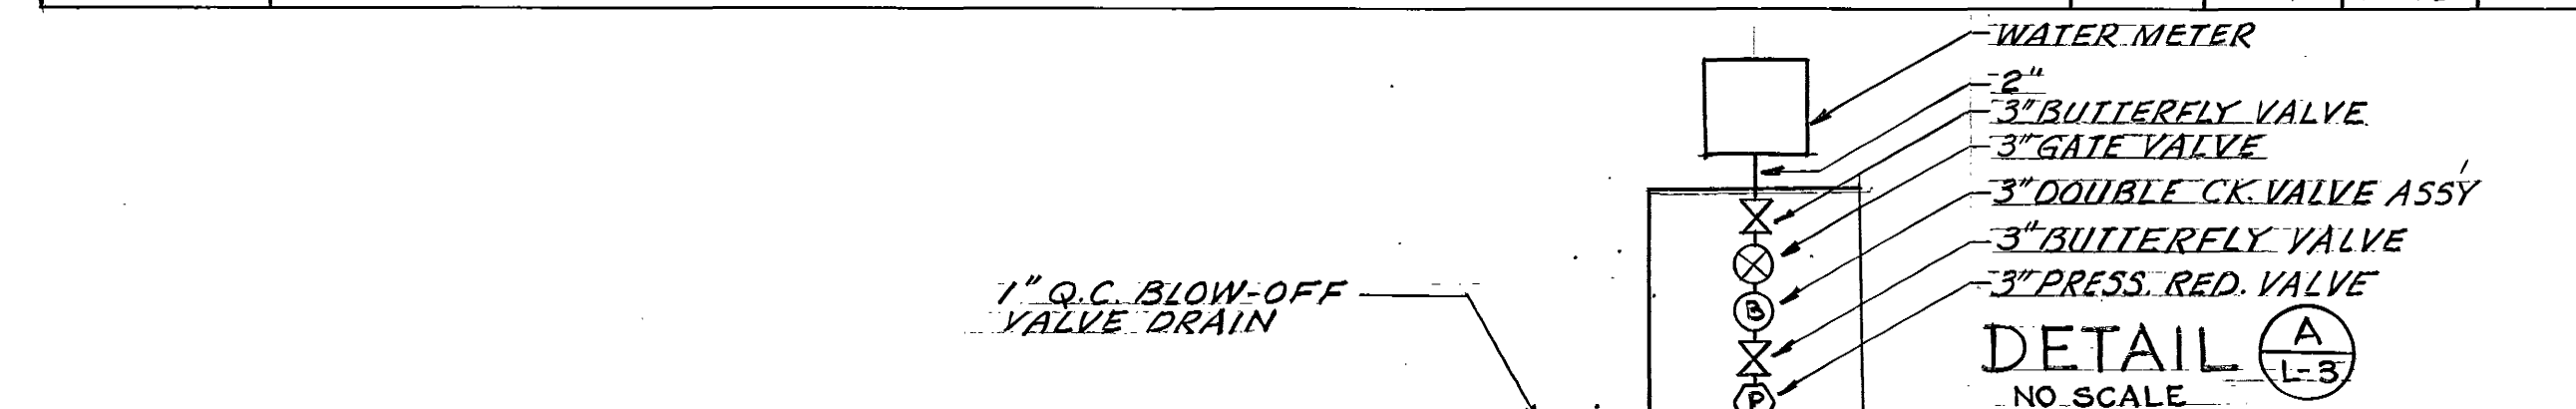

2-RAINBIRD 2400 FLT-F @ 35 PSI
 3-RAINBIRD 2400 FLT-H @ 35 PSI
 16.2 = TOTAL GPM FOR ISLAND

PLANTERS A&B


SCALE 1"=10'-0"

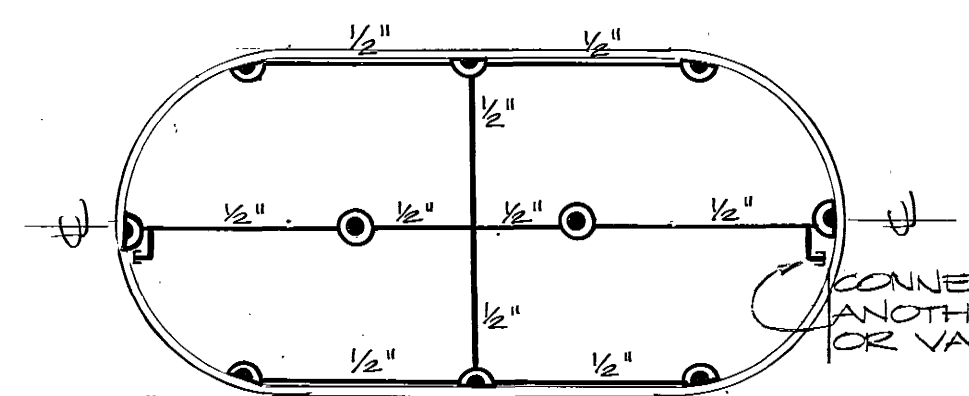

2-RAINBIRD 2400 FLT-F @ 35 PSI
 3-RAINBIRD 2400 FLT-H @ 35 PSI
 16.2 = TOTAL GPM FOR ISLAND

PLANTERS E&F


SCALE 1"=10'-0"

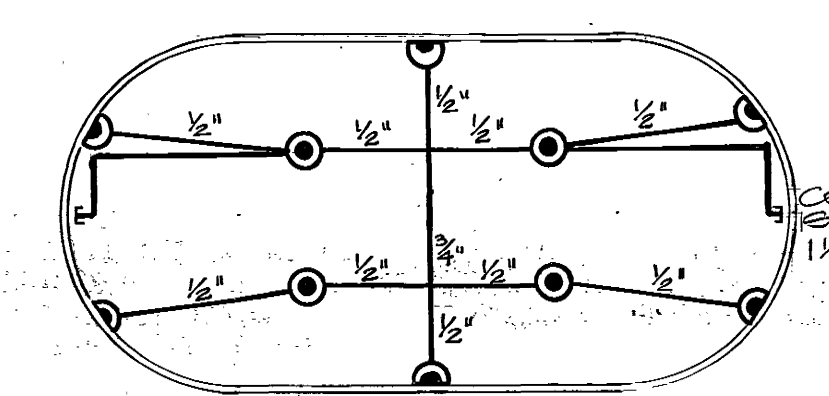

4-RAINBIRD 2400 FLT-F @ 35 PSI
 6-RAINBIRD 2400 FLT-H @ 35 PSI
 18.2 = TOTAL GPM FOR ISLAND

PLANTERS C&D


SCALE 1"=10'-0"

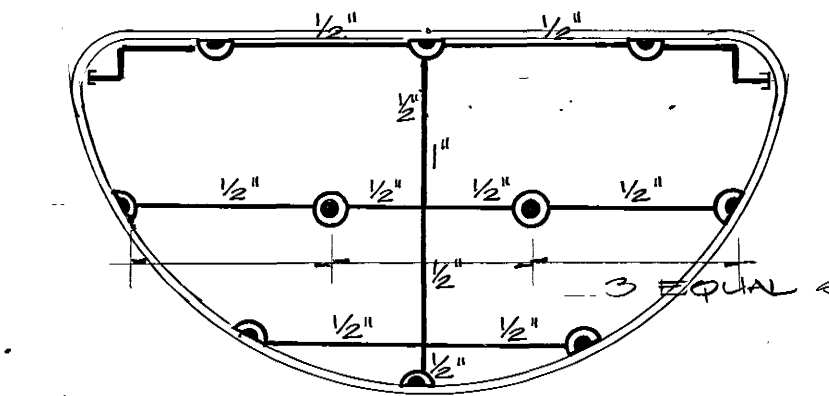

2-RAINBIRD 2400 FLT-F @ 35 PSI
 3-RAINBIRD 2400 FLT-H @ 35 PSI
 16.2 = TOTAL GPM FOR ISLAND

PLANTERS G&H

SCALE 1"=10'-0"

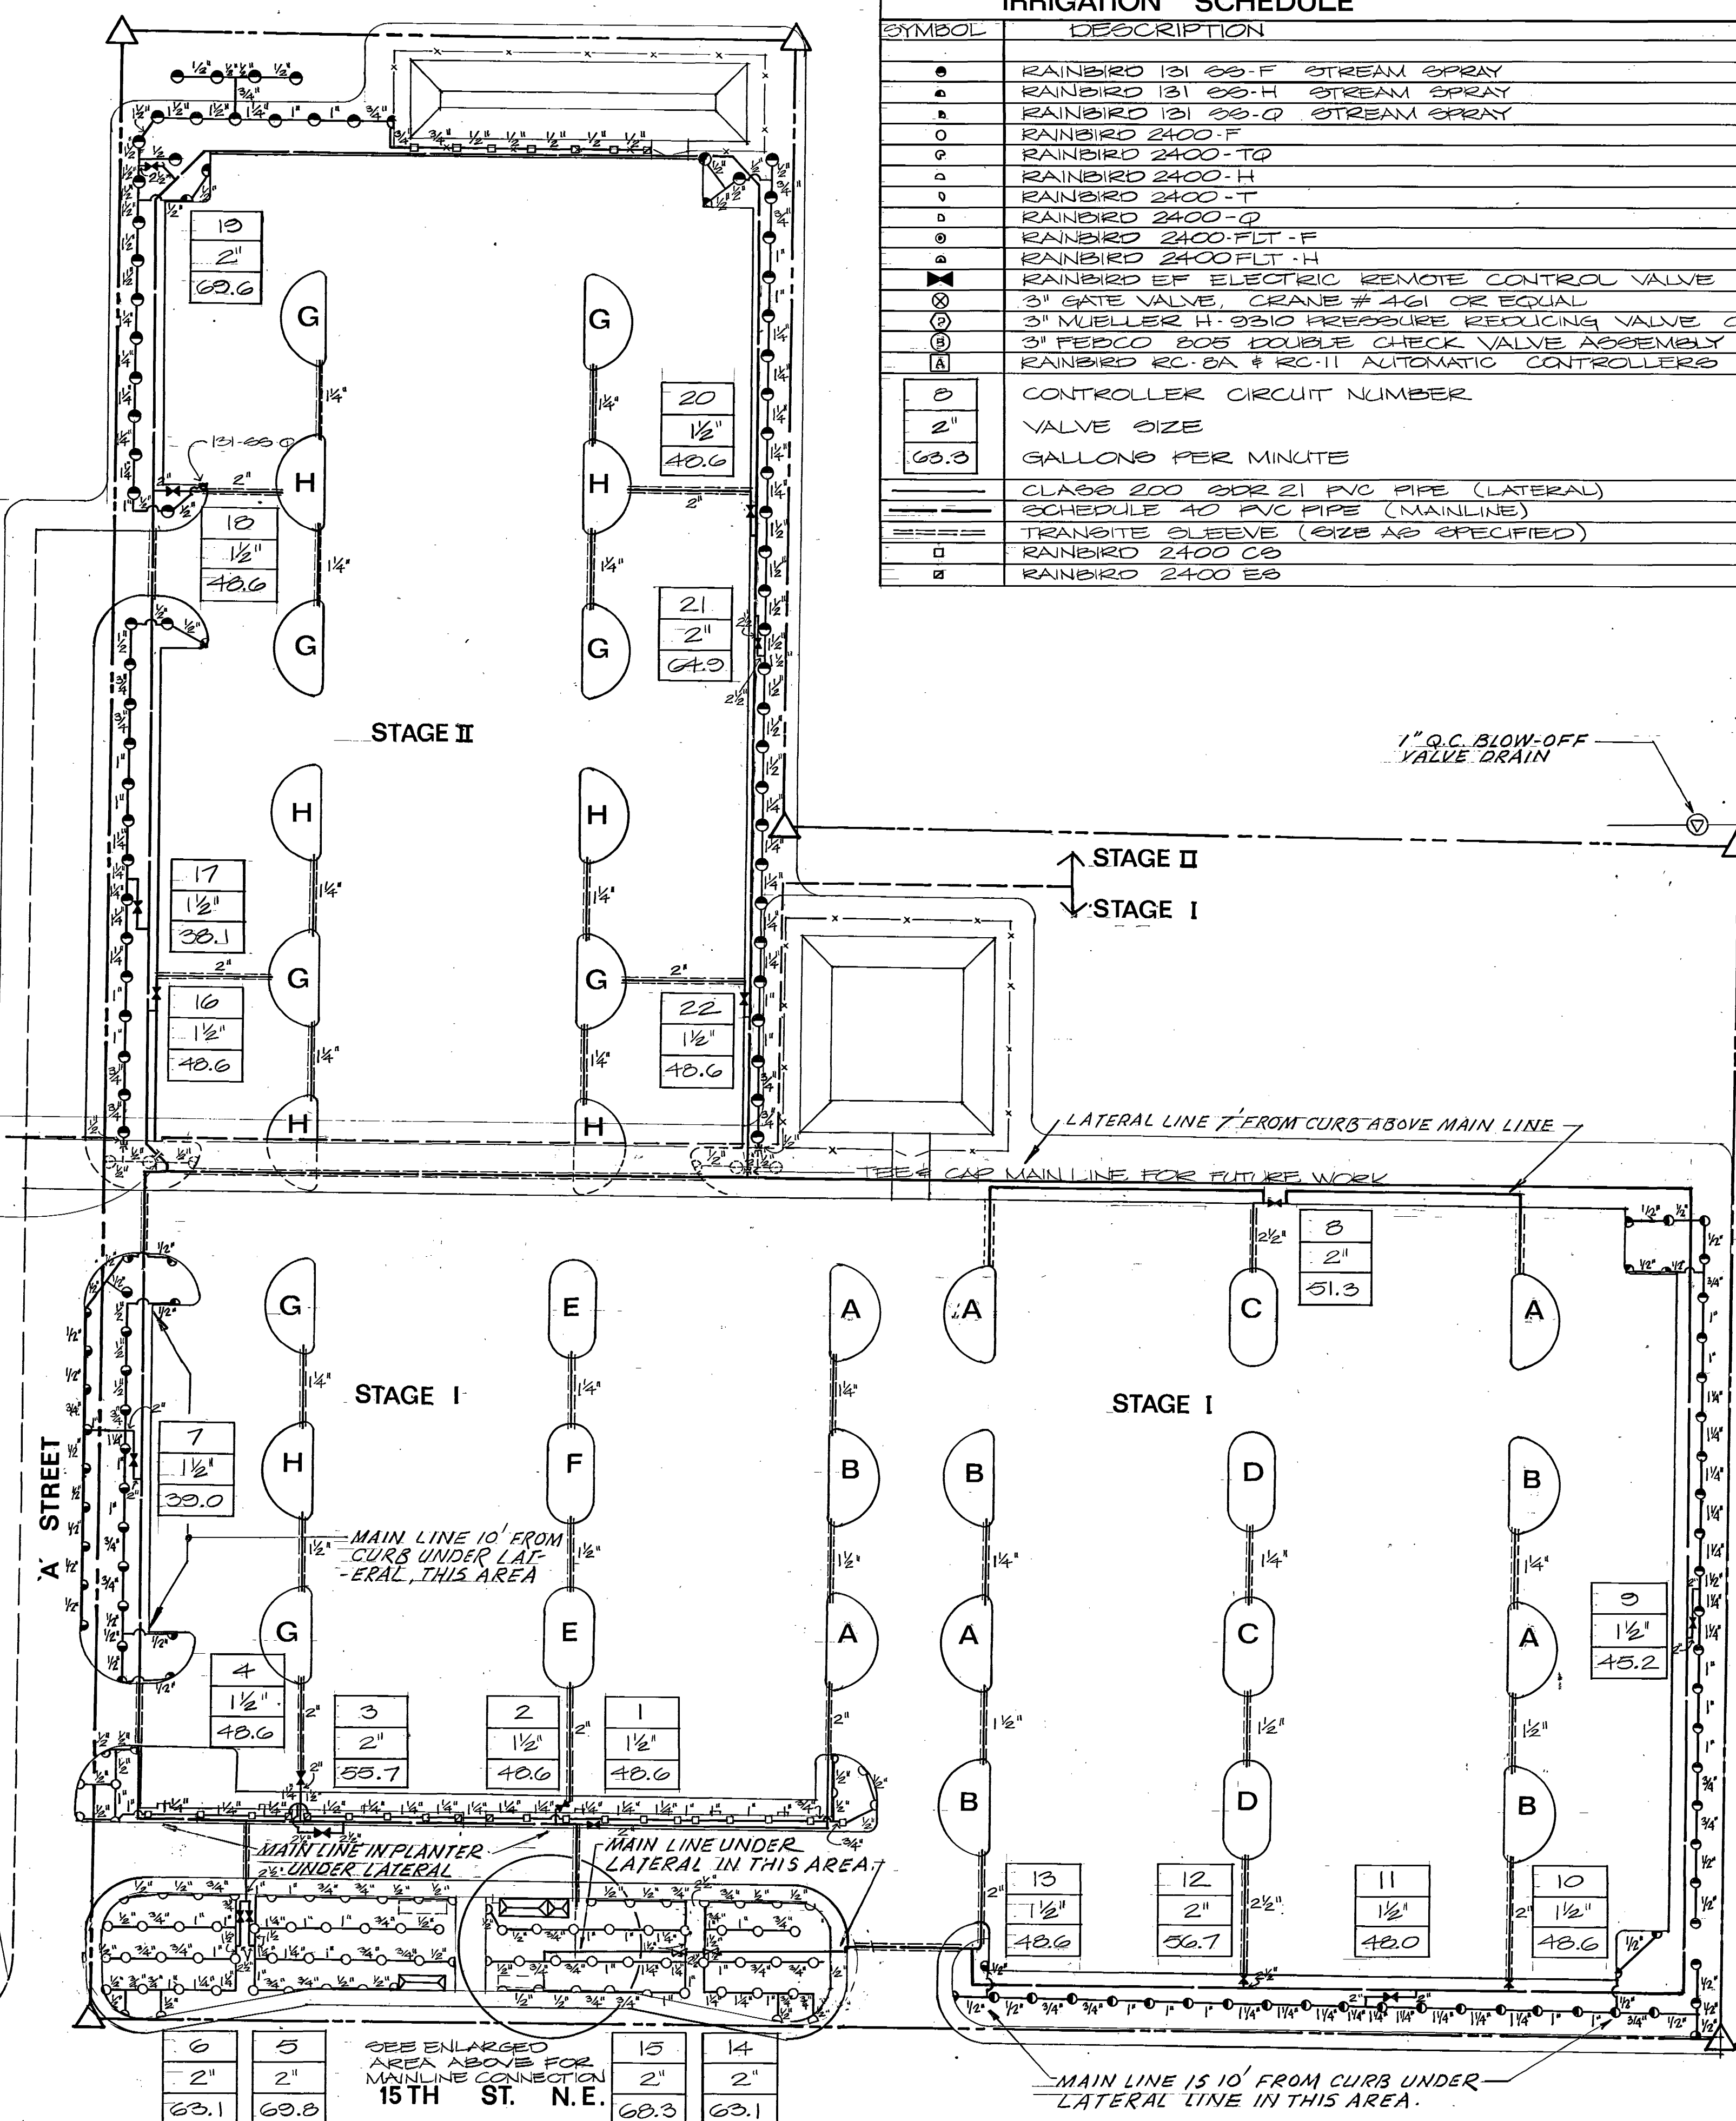

IRRIGATION PLAN 1"=40'-0"



NOTE:
 ALL IRRIGATION LINES UNDER ASPHALT PAVEMENT ARE 2 1/2" I.D.



MUNICIPALITY OF METROPOLITAN SEATTLE — TRANSIT DIVISION AUBURN PARK-AND-RIDE FACILITY IRRIGATION PLAN			
VICTOR O. GRAY & COMPANY, INC. CONSULTING ENGINEERS & PLANNERS RICHARD HAAG & ASSOCIATES LANDSCAPE ARCHITECTS JD 21 — LIGHTING ENGINEERS		Date 9/76 File No. 7605 Sheet 13 of 27	L-3 Sheet Number
SR Designed KN Drawn	9/76 Date 9/76 Date	Municipality of Metropolitan Seattle Approved Date 12/29/76	


111202

"AS CONSTRUCTED"
 FEB. 10, 1978

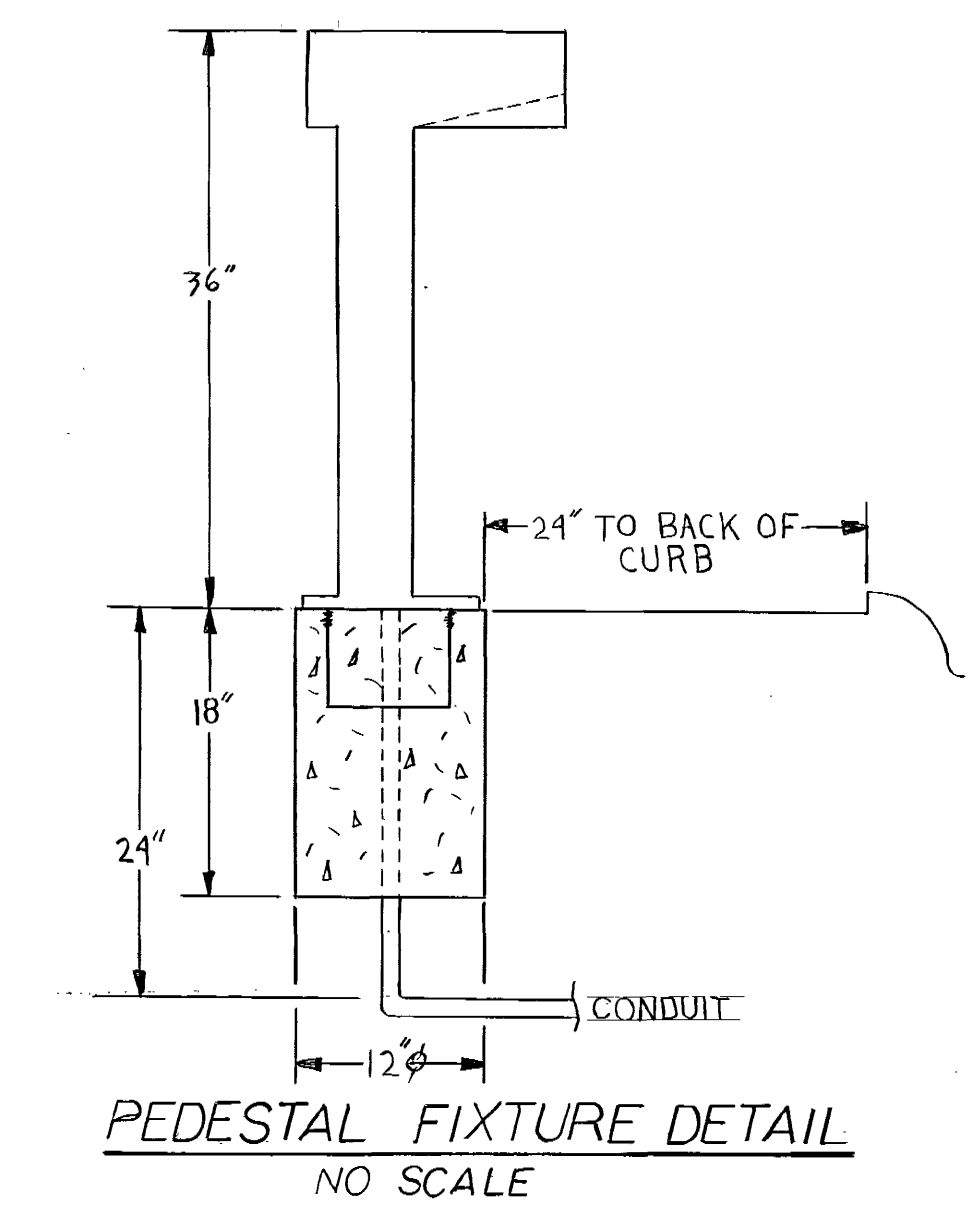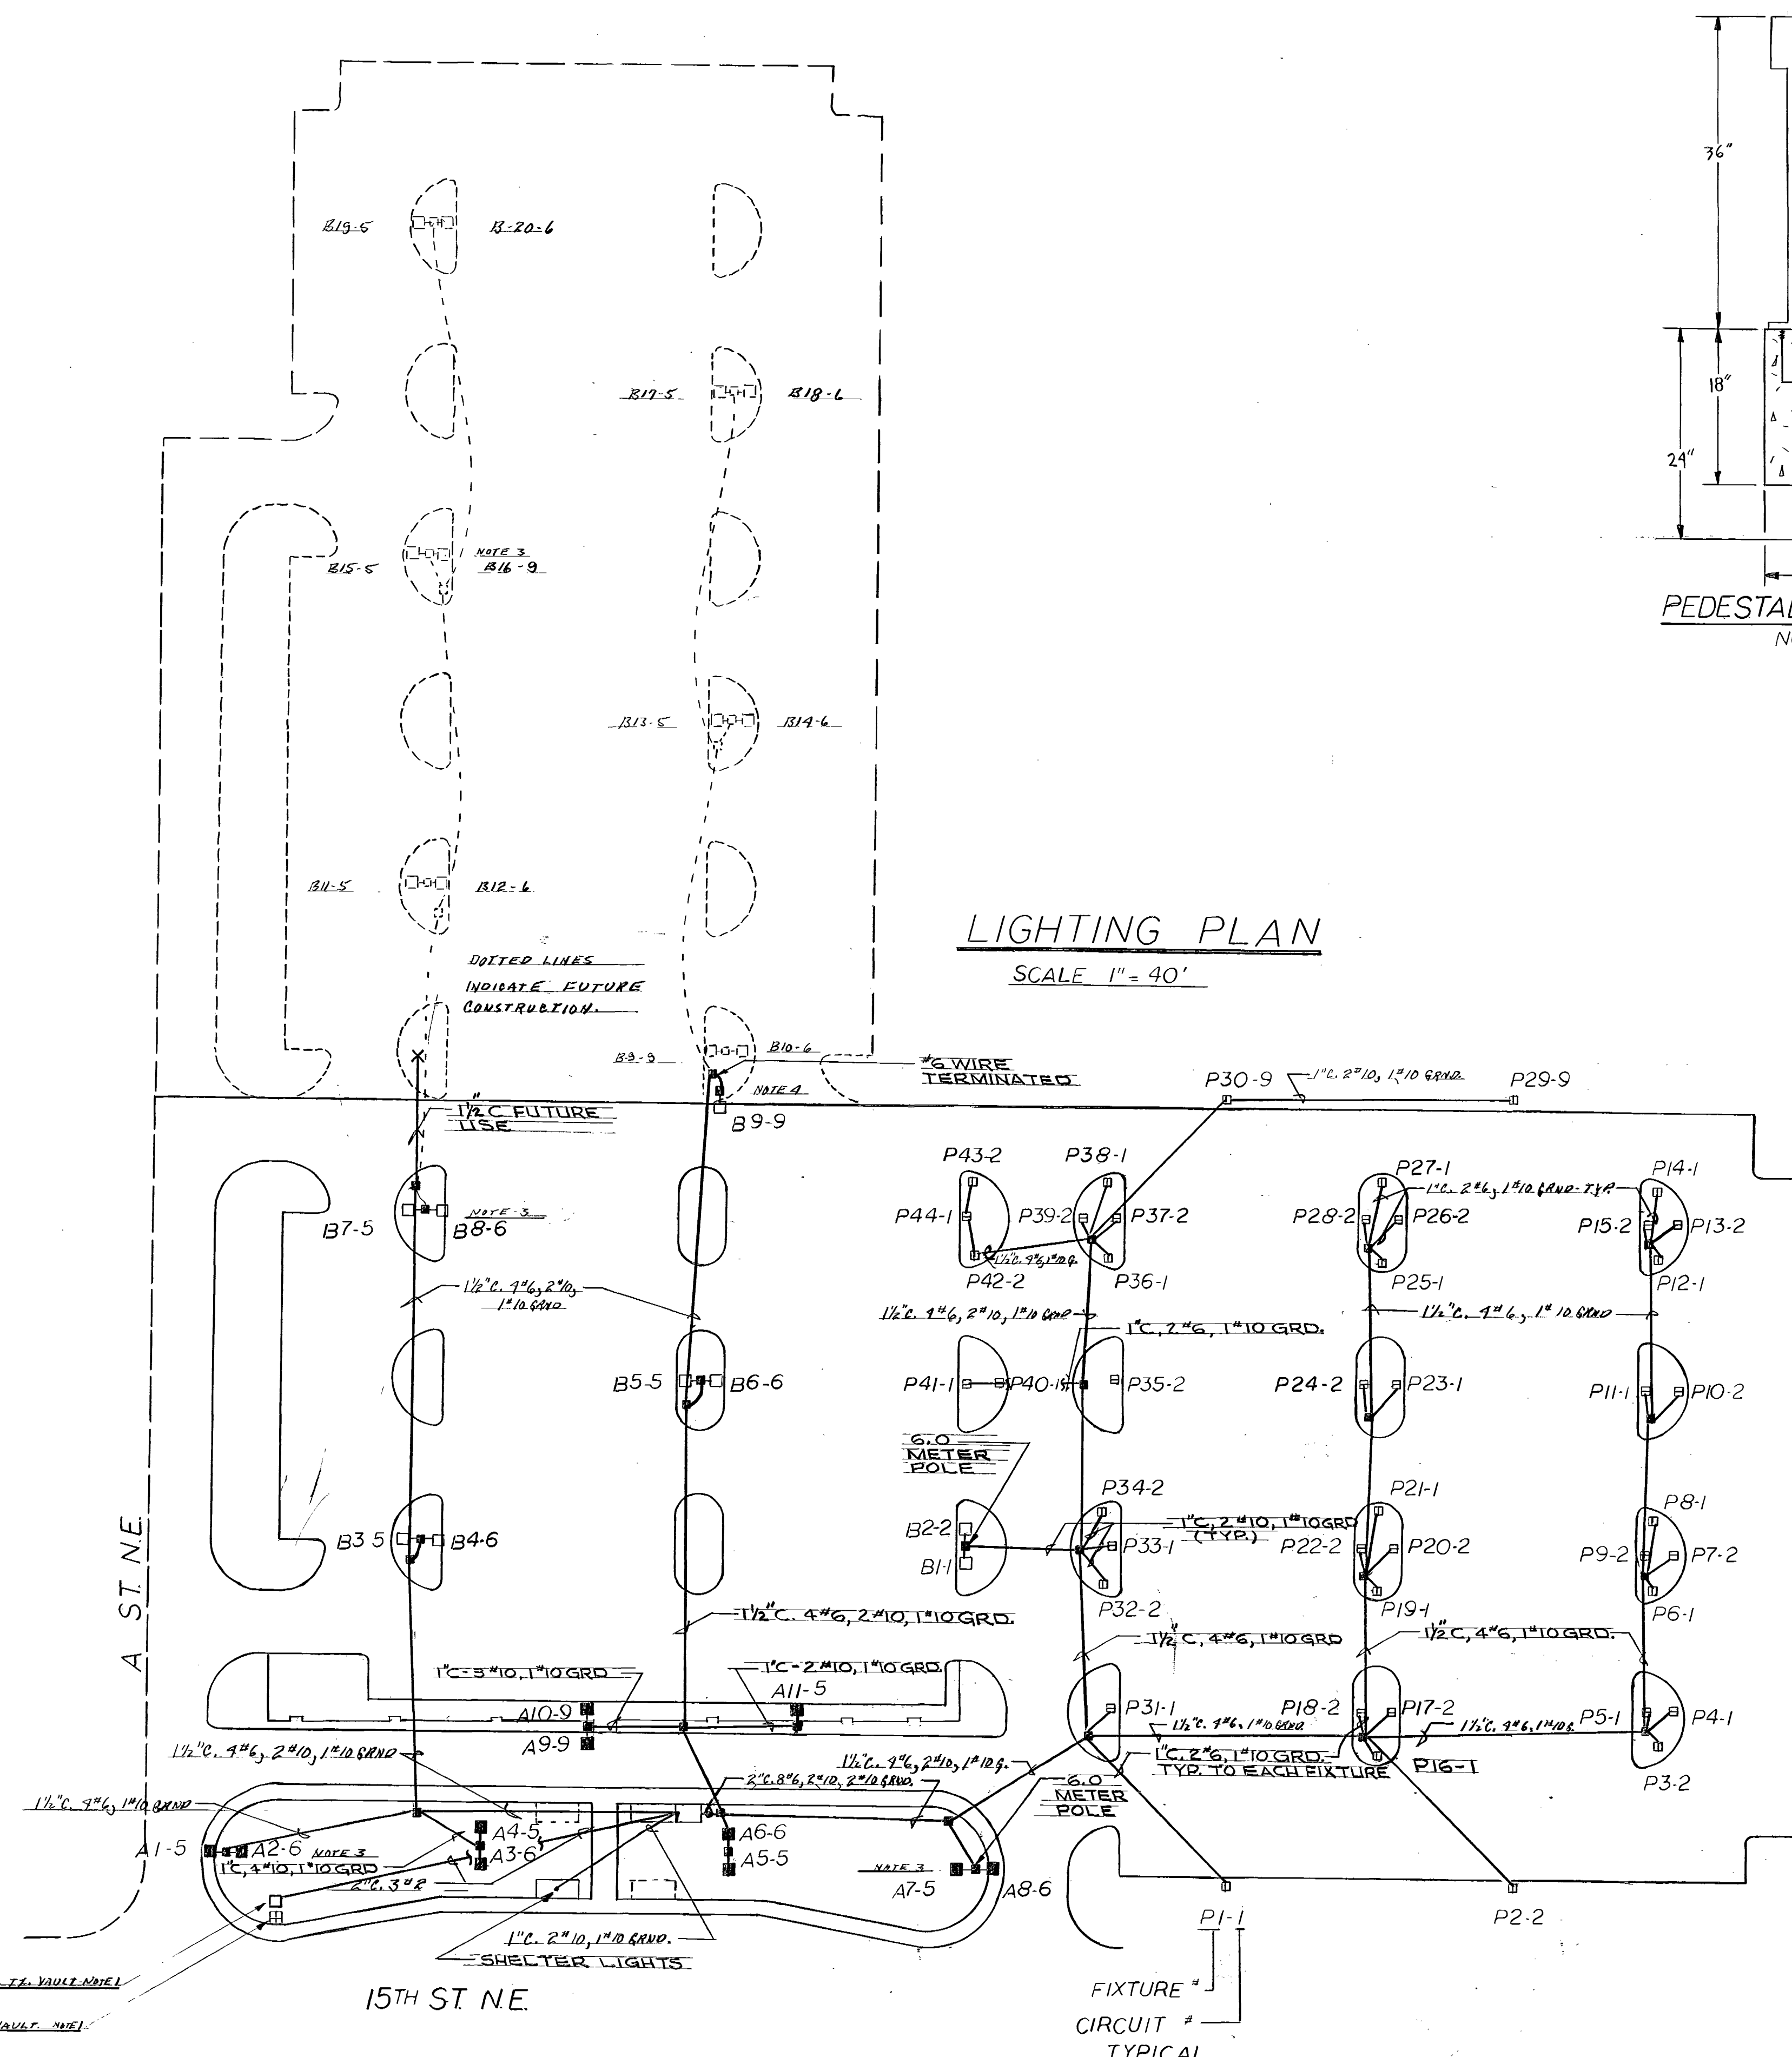

- KEY**
- PEDESTAL LUMINAIRE 175 W. 240V. LAMP - H39KC-175/DX
 - AREA LIGHT-8.0 METER POLE 250W. 240V. LAMP- LU250/BU
NOTE: POLE TO HAVE PROVISIONS FOR FUTURE TANDEM FIXTURE MOUNTING
 - TANDEM AREA LIGHT-8.0 METER POLE 2-250W. 240V. LAMP: LU250/BU
 - AREA LIGHT-8.5 METER POLE 400 W. 240V. LAMP LU400/BU
 - TANDEM AREA LIGHT-8.5 METER POLE 2-400W. 240V. LAMP LU400/BU
 - CONCRETE HAND HOLE - 12" OR EQUIV.

- NOTES**
- EXISTING ELECTRICAL VAULT SHALL BE ADJUSTED TO GRADE. SEE SHEET C-4. A NEW TRANSFORMER VAULT SHALL BE PROVIDED AND INSTALLED. THE CONTRACTOR SHALL BE RESPONSIBLE FOR DOING THIS OR ARRANGING TO HAVE IT DONE BY PSPL ALONG WITH ALL COSTS AND CHARGES.
 - SOME CONDUIT RUNS CROSS STORM DRAIN PIPES. GRADUALLY ELEVATE CONDUIT RUNS OVER OTHER UTILITY LINES.
 - SHIFT FIXTURE BASE TO CLEAR STORM DRAIN.
 - FIXTURE B-9 AND ITS STANDARD WILL BE MOVED TO THE LOCATION SHOWN BY THE DASHED LINES IN THE FUTURE CONSTRUCTION.

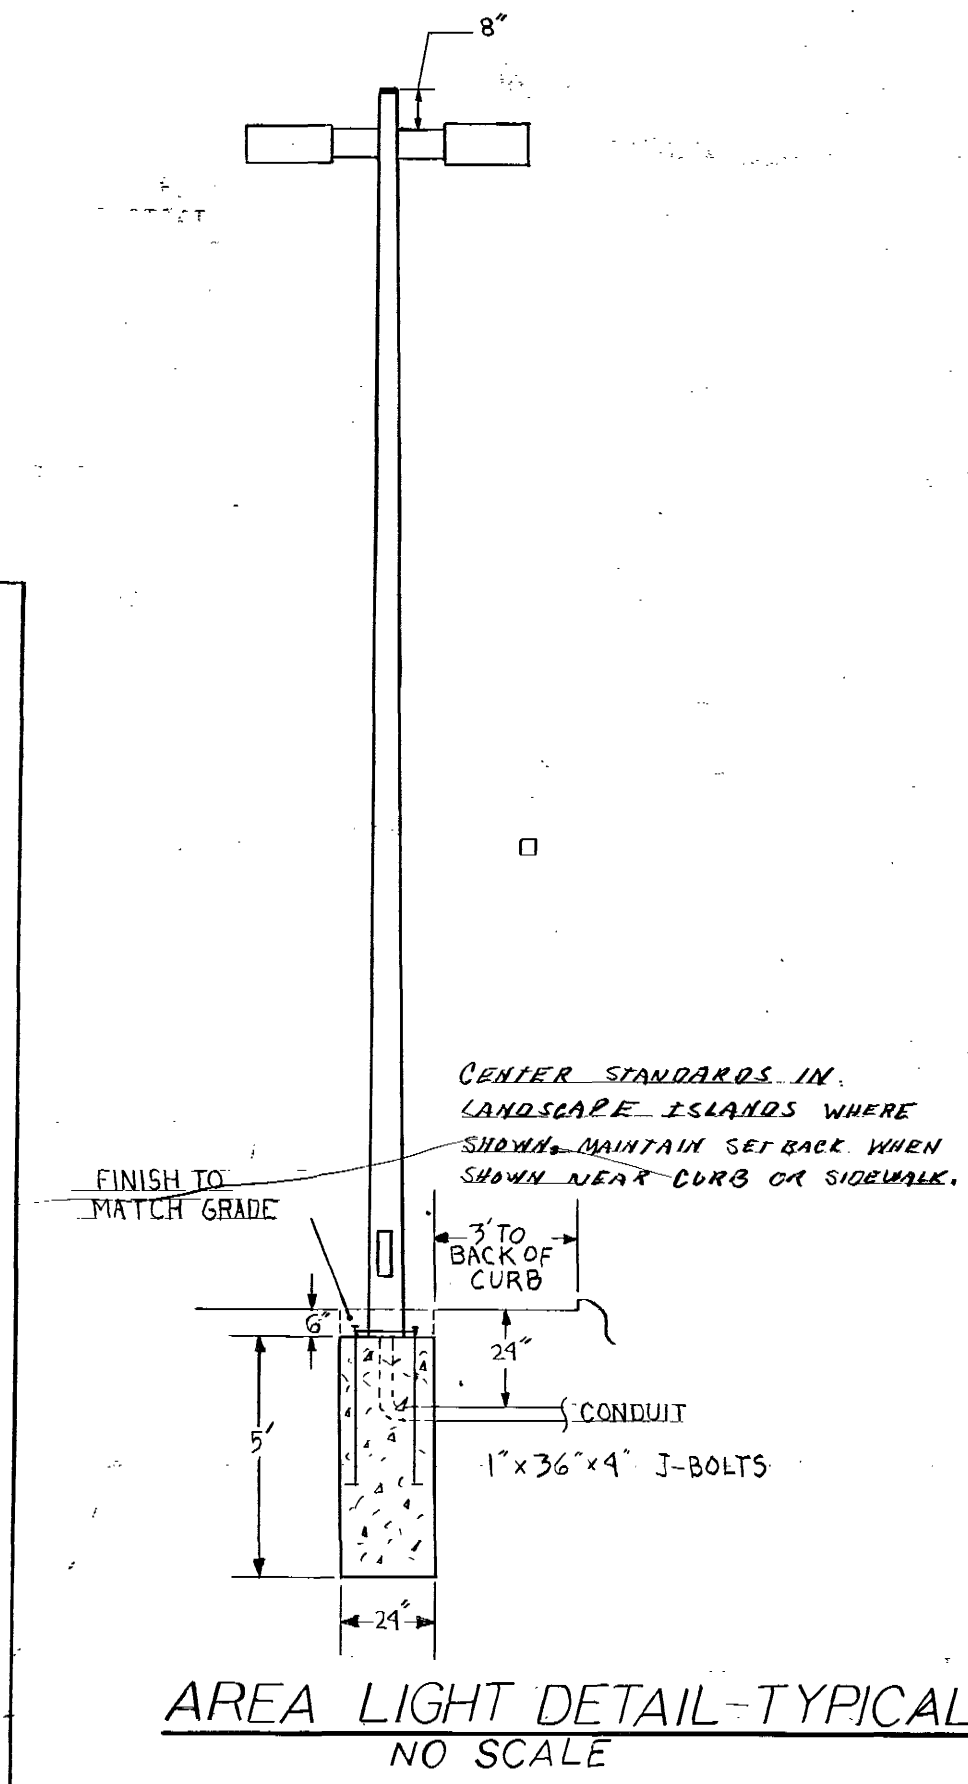


AS - BUILT
2-23-78

111203

MUNICIPALITY OF METROPOLITAN SEATTLE — TRANSIT DIVISION				
AUBURN PARK-AND-RIDE FACILITY				
LIGHTING AND ELECTRICAL PLAN				
	VICTOR O. GRAY & COMPANY, INC. CONSULTING ENGINEERS & PLANNERS RICHARD HAAG & ASSOCIATES LANDSCAPE ARCHITECTS JD 21 — LIGHTING ENGINEERS		Date 9/76 File No. 7605 Sheet 14 of 27	
	J.D.A. 8/76 Designed B.J.A. 8/76 Drawn	Municipality of Metropolitan Seattle Approved 12/29/76 Date	E-1 Sheet Number	


MAIN PANEL SCHEDULE

CIRCUIT #	BREAKER	CONTACTOR	WIRE	LOAD (KW)		TO
				A	B	
MAIN	2P100A			10.34	10.34	74 A. MAX./Ø
1, 3	2P40A	2P30A	#2	3.72	3.72	AREA LIGHTS
2, 4	2P40A	2P30A	#6	3.72	3.72	AREA LIGHTS
5, 7	2P30A	2P30A	#6	1.50	1.50	AREA LIGHTS
6, 8	2P30A	2P30A	#6	1.30	1.30	AREA LIGHTS
9, 11	2P30A	TIME CLOCK TC-1	#10	1.00	1.00	SECURITY LIGHTS
10, 12	2P30A					SPARE
13	1P20A		#12	0.20		LIGHT AND FAN
14	1P20A		#12	0.40		RECEPTACLES
15	1P20A		#12		0.75	WALL HEATER
16	1P20A		#12			HOT WATER HEATER
17	1P20A		#12	0.20		IRR. CONTROL
18	1P20A					SPARE
19	1P20A		#12			SHELTER LIGHTING
20	1P20A		#12			TIME CLOCKS & CONTROL

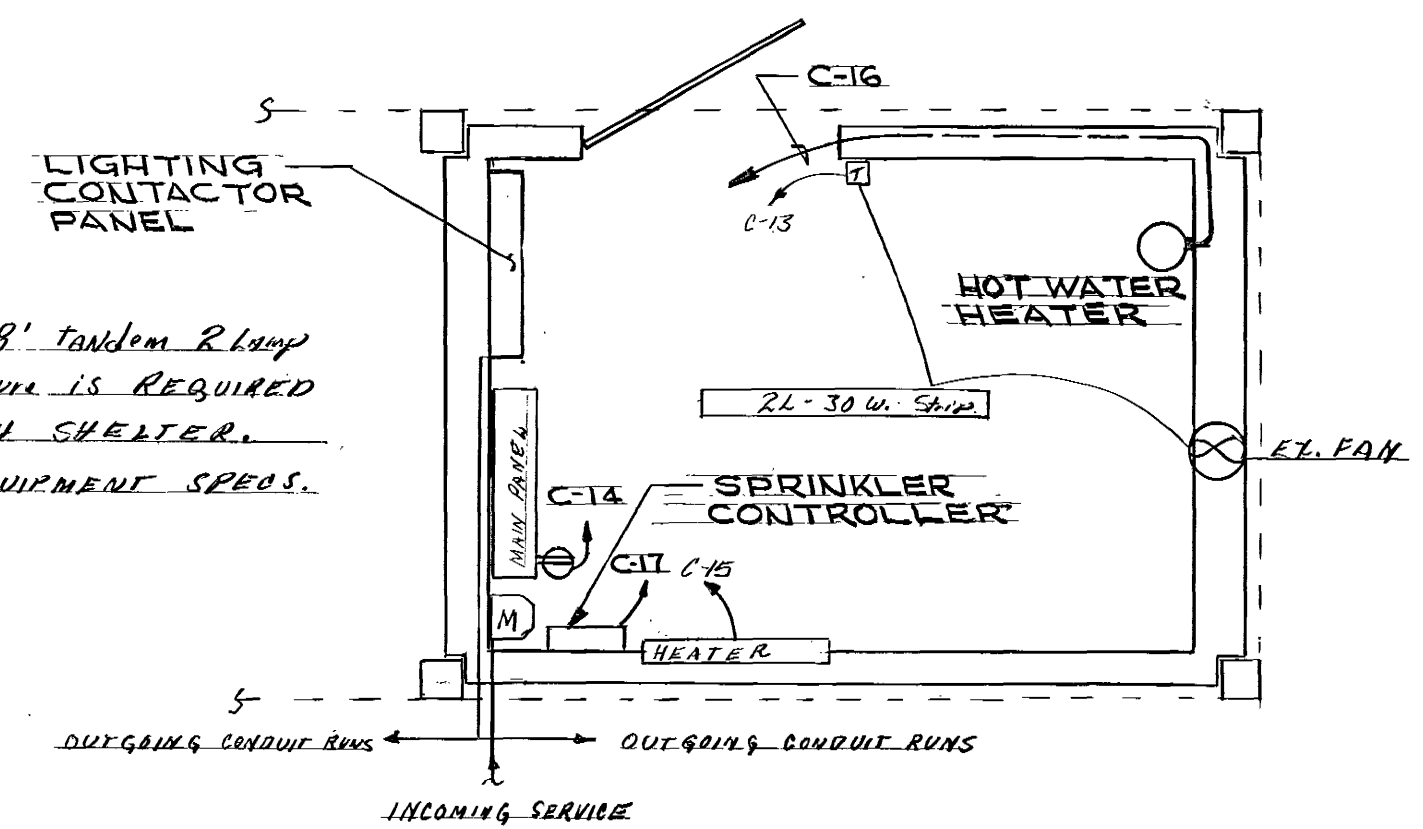


DRIVER'S TOILET ELECTRICAL PLAN

SCALE 1/4" = 12"

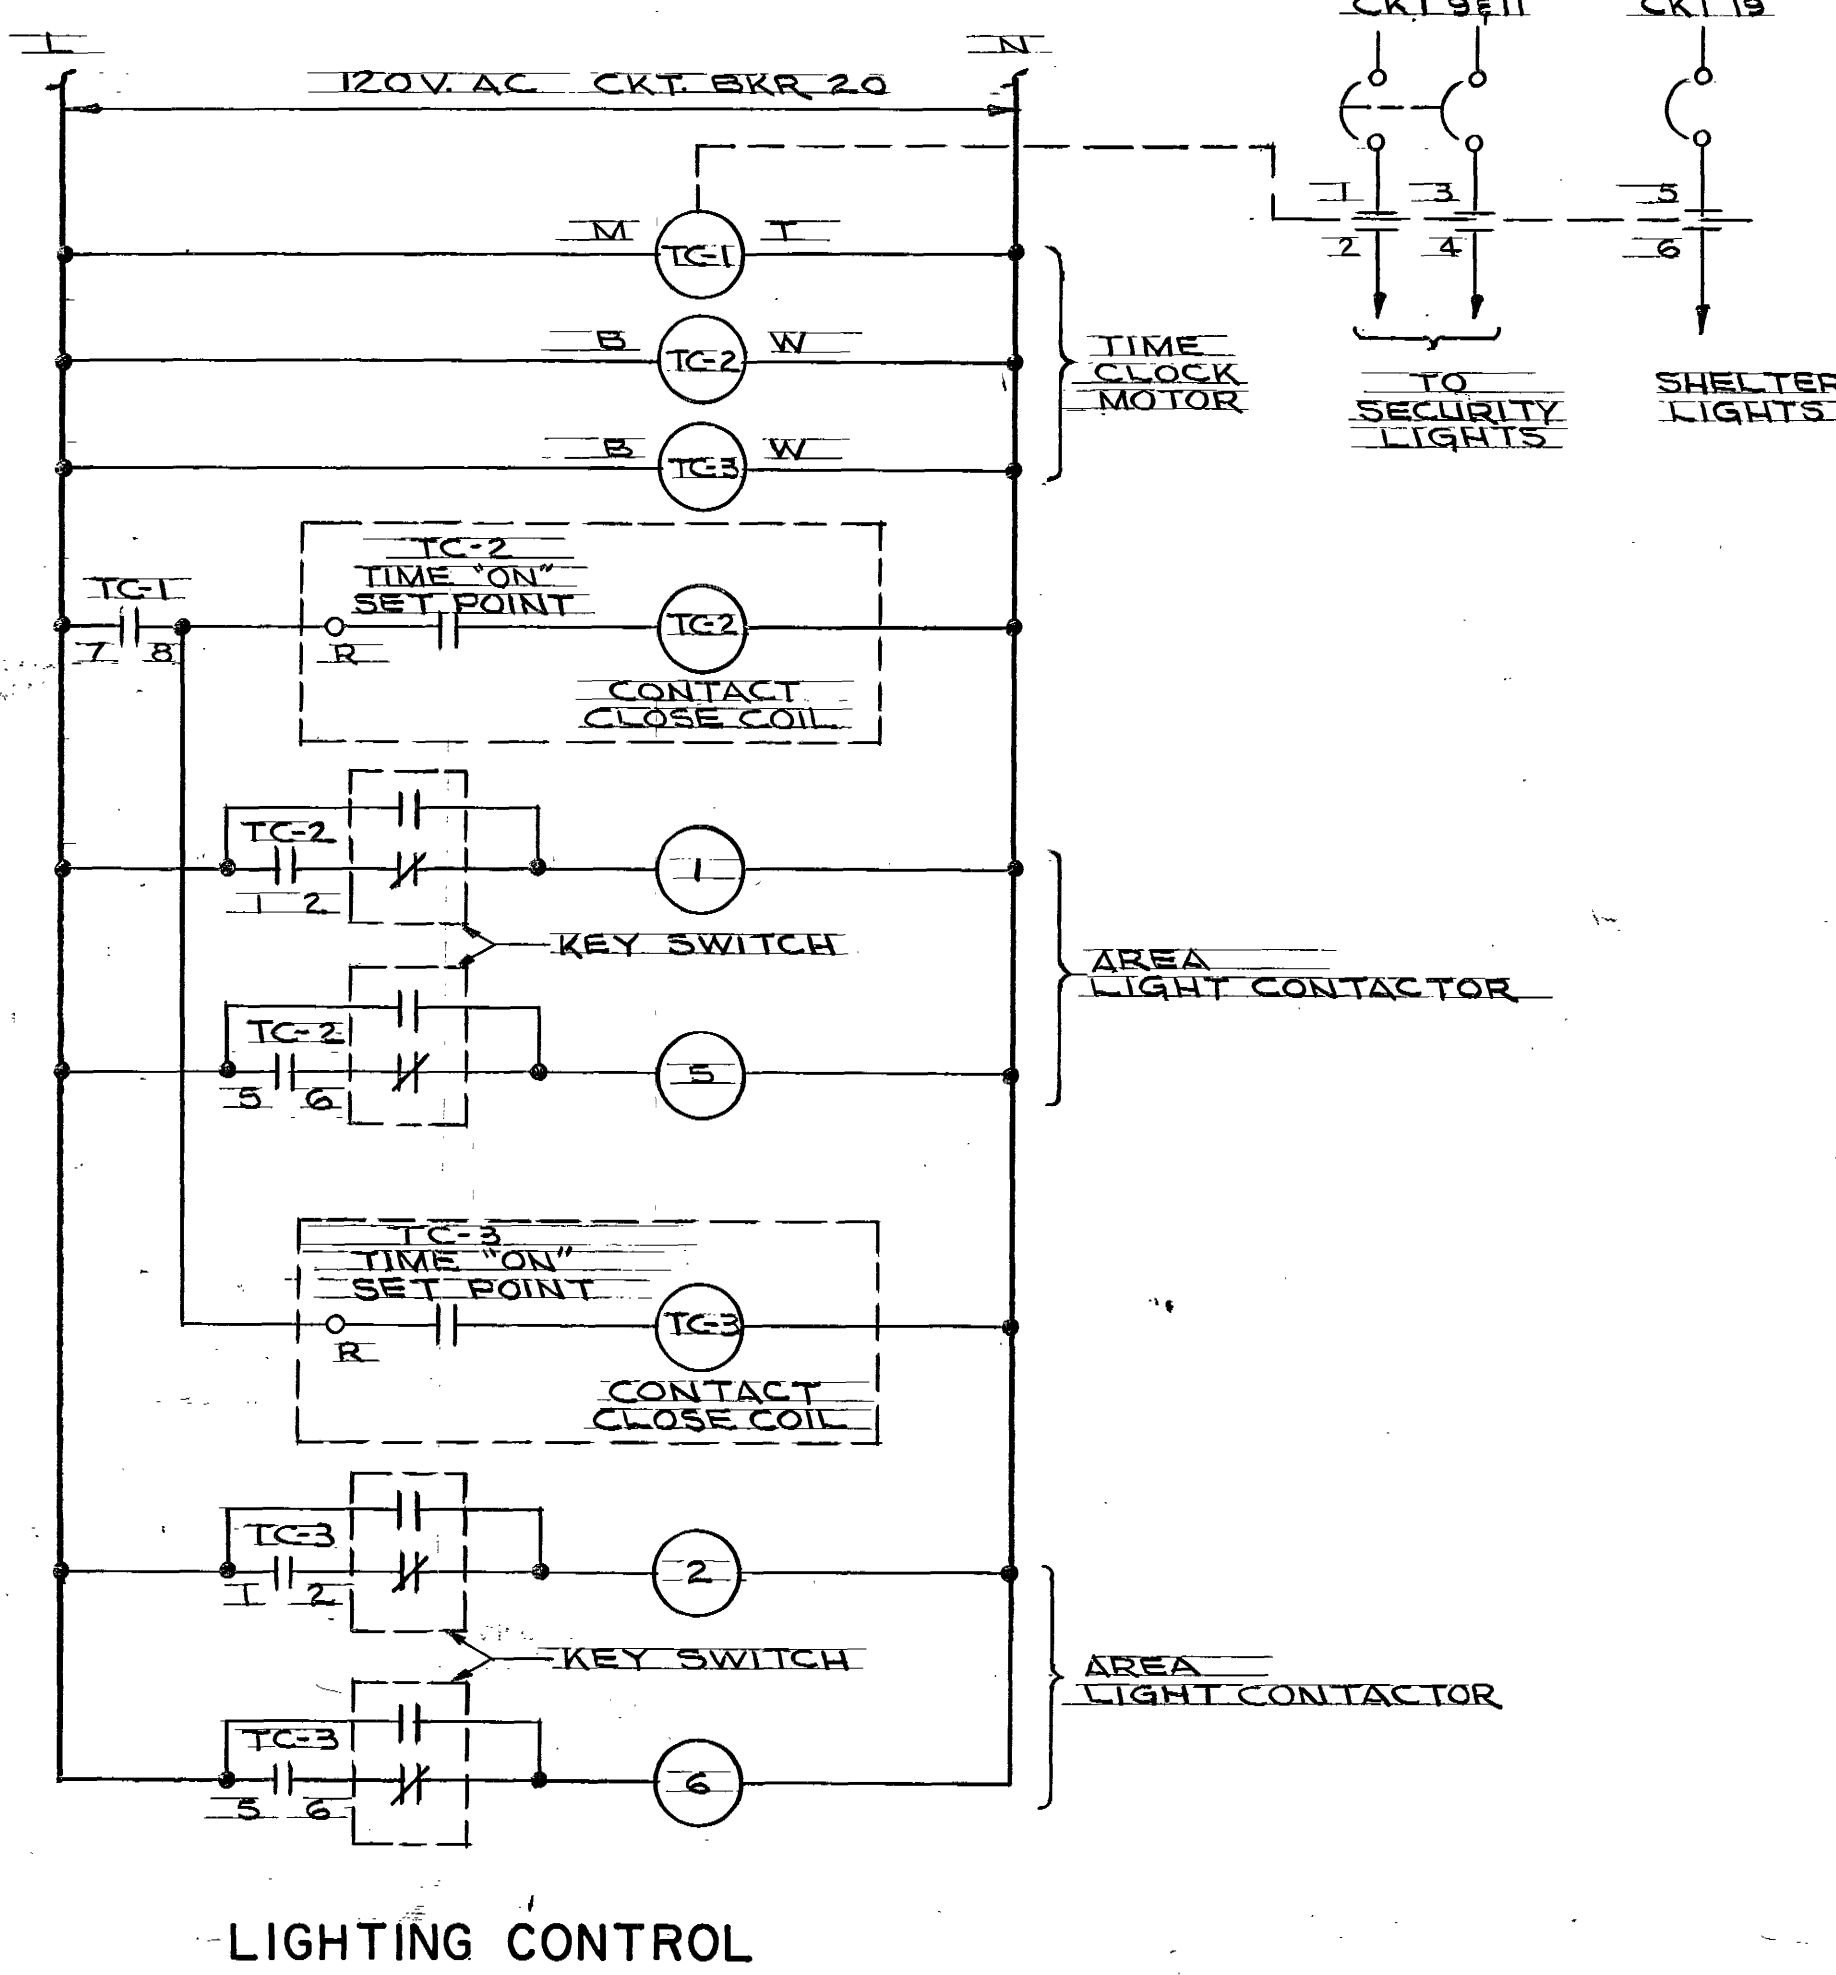


EQUIPMENT SPECS AND NOTES

- WALL BOX MOUNTED INTERVAL TIMER - 13.8A, 120V, 0-60 MINUTES. PARAGON #FF51-00 OR EQUAL.
- EXHAUST FAN - "THRU-THE-WALL" 250 CFM - 0.85A, 120V, NUTONE #8170
- HEATER - FAN FORCED WALL-INTEGRAL THERMOSTAT - 750W, 120V, CHROMALOX 'H-5022.
- DUPLEX RECEPTACLES - 20A, 120V, STAINLESS STEEL COVER - BRYANT #5362 OR EQUAL.
- TWO LAMP FLUORESCENT FIXTURES SHALL BE INSTALLED IN THE SHELTERS. THEY SHALL BE "STRIP" FIXTURES, BE UL LABELED FOR "DAMP LOCATIONS" AND BE SUITABLE FOR RELIABLE LAMP STARTING TO 0°F. DRIVERS TOILET SHALL HAVE A 2L - 30W - 120V, CONTROLLED BY AN INTERVAL TIMER. THE SHELTERS SHALL HAVE A 4L - 40W - 120V, 96" UNIT IN EACH CONTROLLED BY THE TIME CLOCK ON C-9. NOTE THAT P.E. CELLS ARE NOT REQUIRED FOR THIS PROJECT. LAMPS WARM WHITE.
- CIRCUIT C-17 SHALL BE EXTENDED TO THE IRRIGATION CONTROL AND THE CONNECTION MADE.
- TC-1 24-HOUR ASTRONOMICAL TIME CLOCK WITH SPRING LOADED "CARRY-OVER" FEATURE, DPST - 40A - 120V, INTERMATIC V45470-SC-R. TC-1 PROVIDES SECURITY LIGHTING, BUS SHELTER LIGHTING AND TURN-ON CONTROL.
- TC-2&3, 7-DAY SIGNAL INITIATED TIME CLOCK WITH "CARRY-OVER" FEATURE, OFF-TIME SHALL BE INDIVIDUALLY ADJUSTABLE BY DAY, 2 NO AND 1 NC CONTACT - 20A - 120V, PARAGON #77211-00. ALL LIGHTS COME ON AT SUNSET BY TC-1, EARLY TURN OFF CAN BE ACCOMPLISHED ON ALTERNATE DAYS FOR ENERGY CONSERVATION AND UNIFORM BURNING HOURS ON ALL LUMINAIRES.
- LTG. CONT. SHALL BE 2P30A WITH 120V, CONTROL COIL GE #CR260L302 - ALL UNITS SHALL BE MOUNTED IN A SINGLE NEMA 1 ENCLOSURE.
- KEY OPERATOR SWITCH, CUTLER HAMMER #1025T15112, CONTACTS #10250T1, KEY H611.

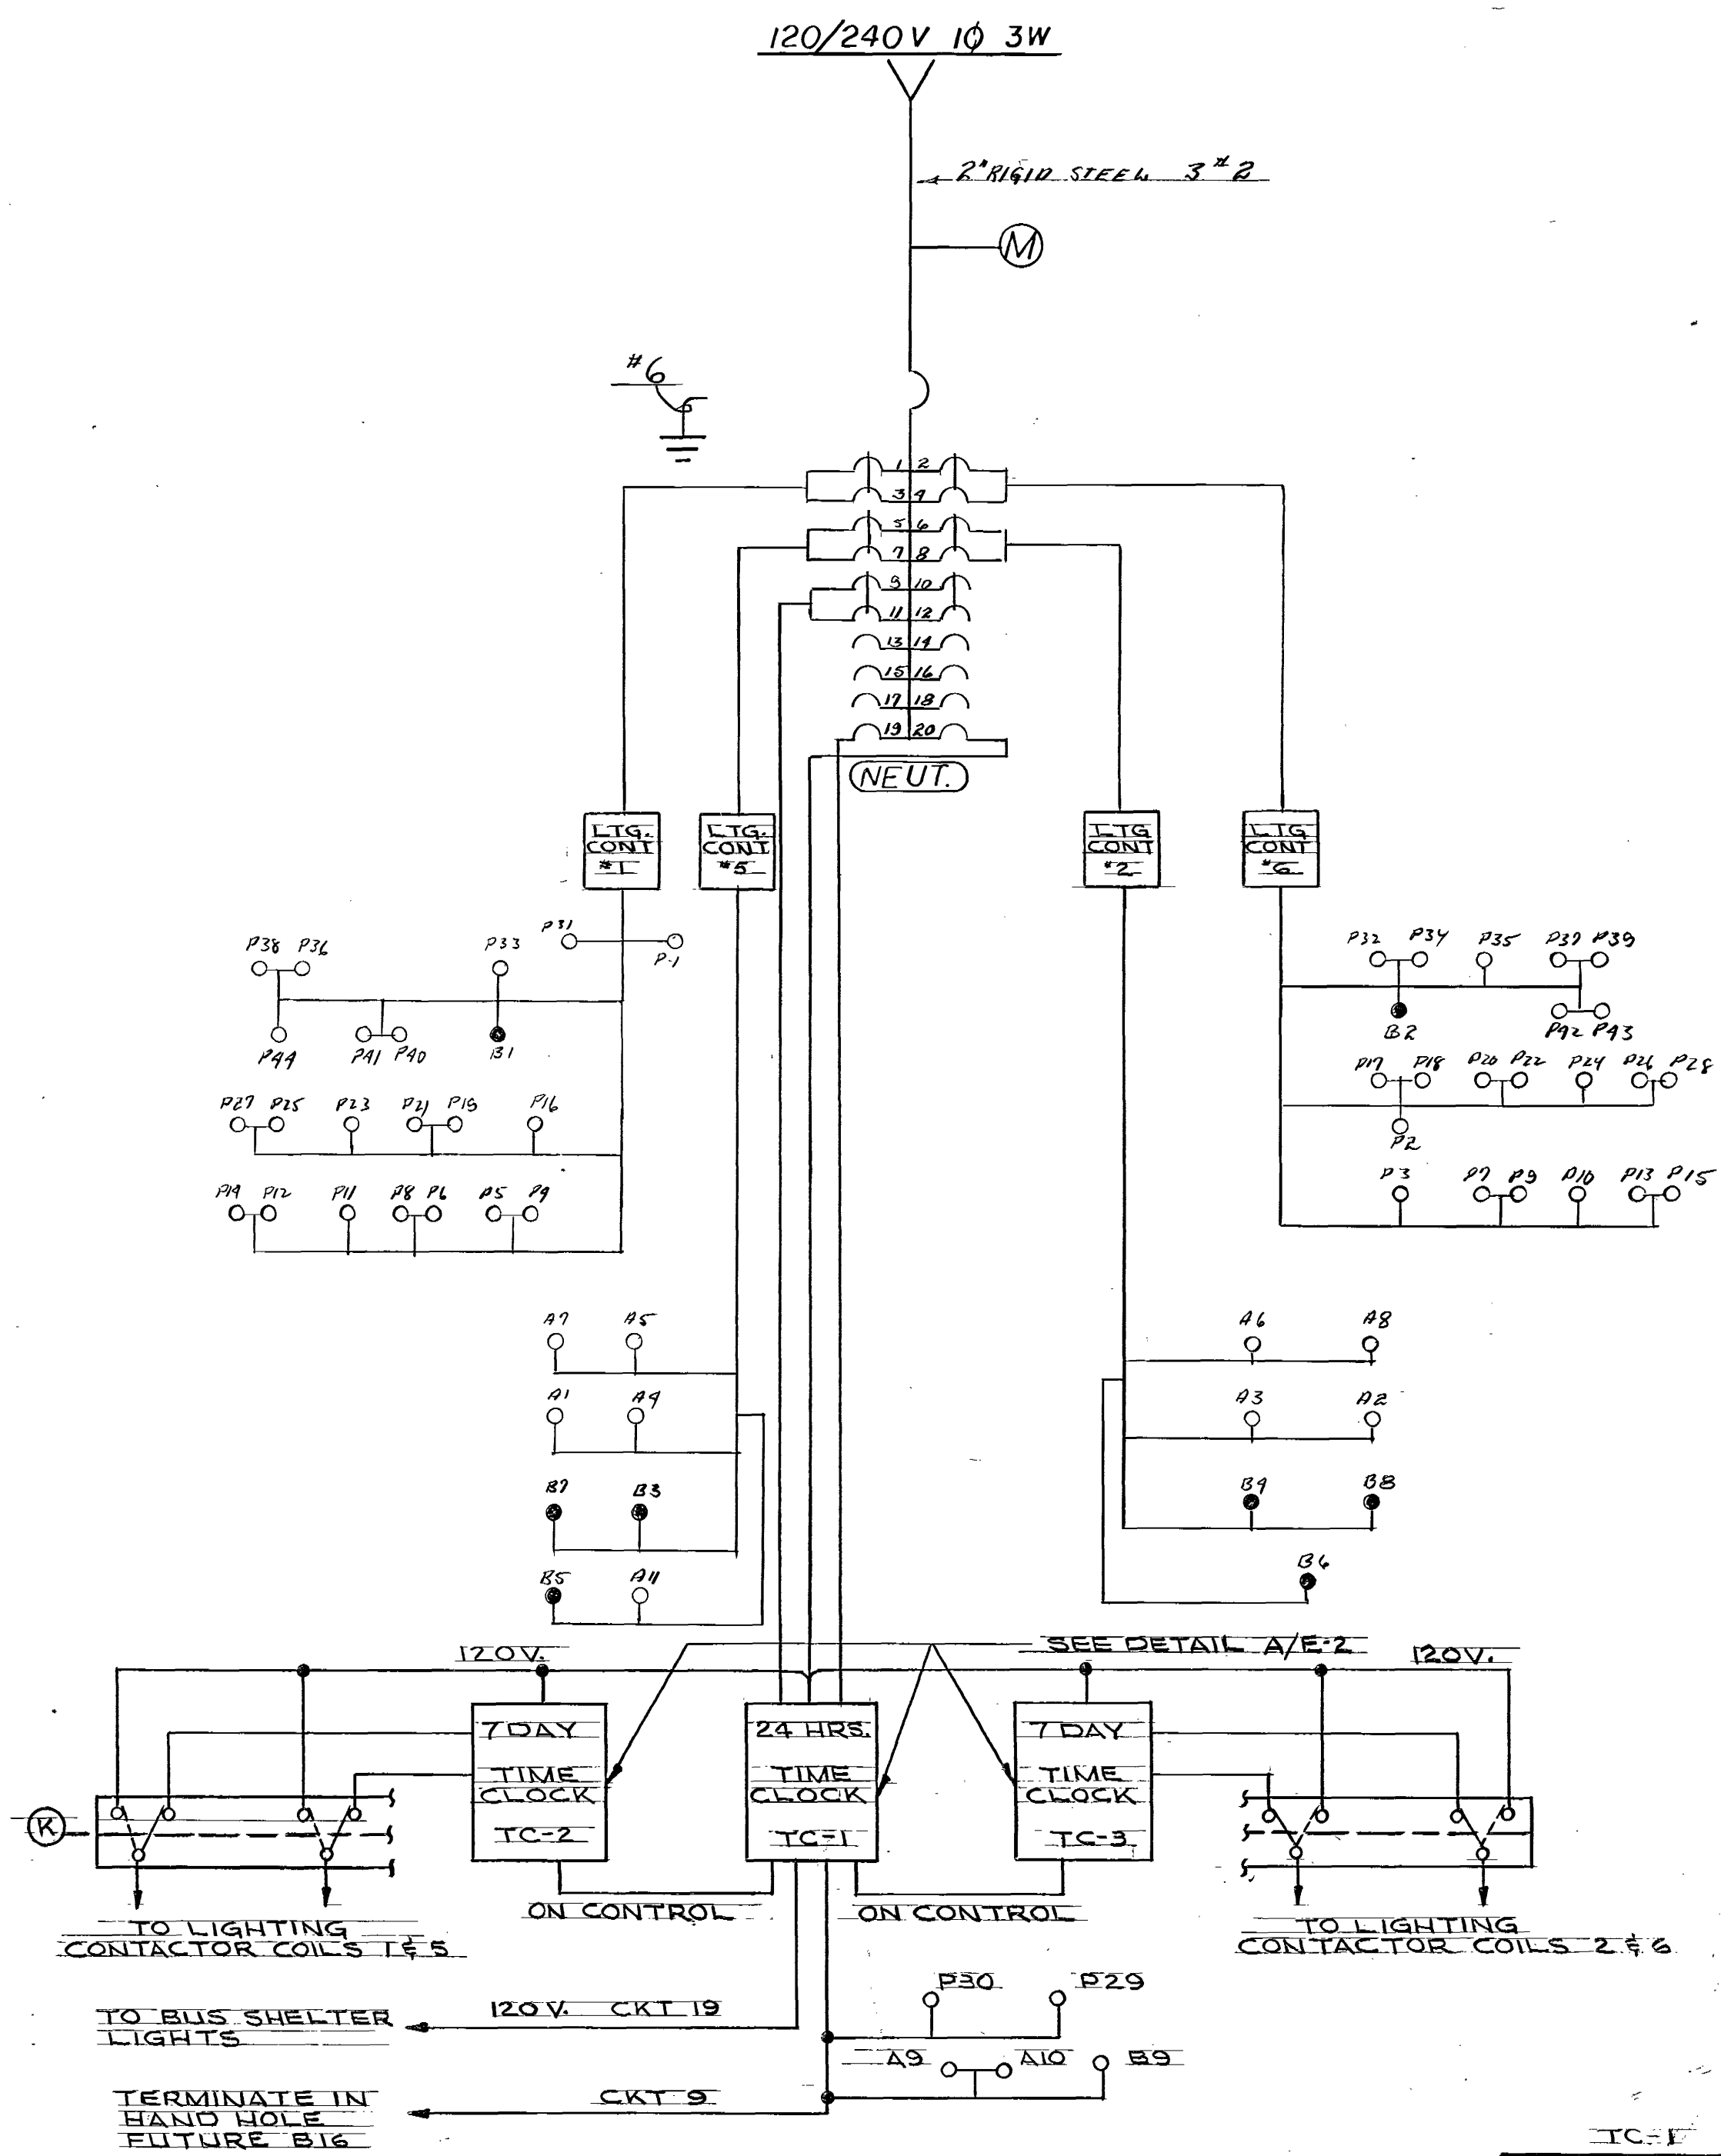

ONE LINE DIAGRAM

NO SCALE

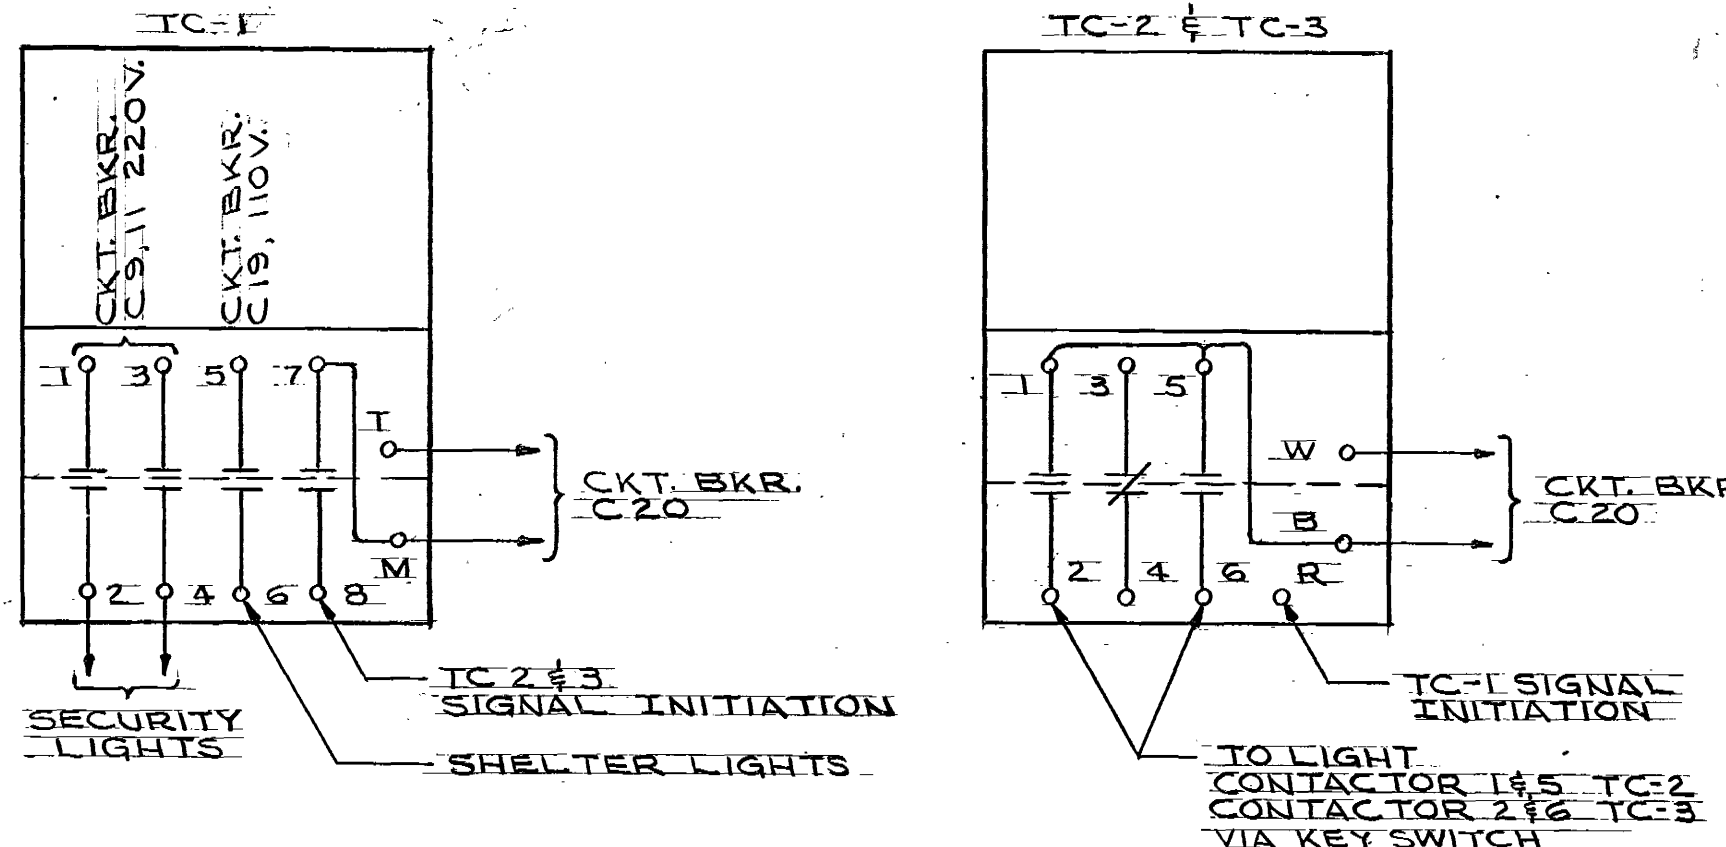


DETAIL A


AS-BUILT
2-23-78

111204

MUNICIPALITY OF METROPOLITAN SEATTLE — TRANSIT DIVISION AUBURN PARK-AND-RIDE FACILITY ELECTRICAL DETAILS			
	VICTOR O. GRAY & COMPANY, INC. CONSULTING ENGINEERS & PLANNERS RICHARD HAAG & ASSOCIATES LANDSCAPE ARCHITECTS JD 21 — LIGHTING ENGINEERS		Date 9/76 File No. 7605 Sheet 15 of 27
	J.D.A. 8/76 Designed	J.D.A. 8/76 Date	Municipality of Metropolitan Seattle Approved Date J.D.A. 12/29/76 Date
	J.D.A. 8/76 Drawn	J.D.A. 8/76 Date	
	E-2 Sheet Number		

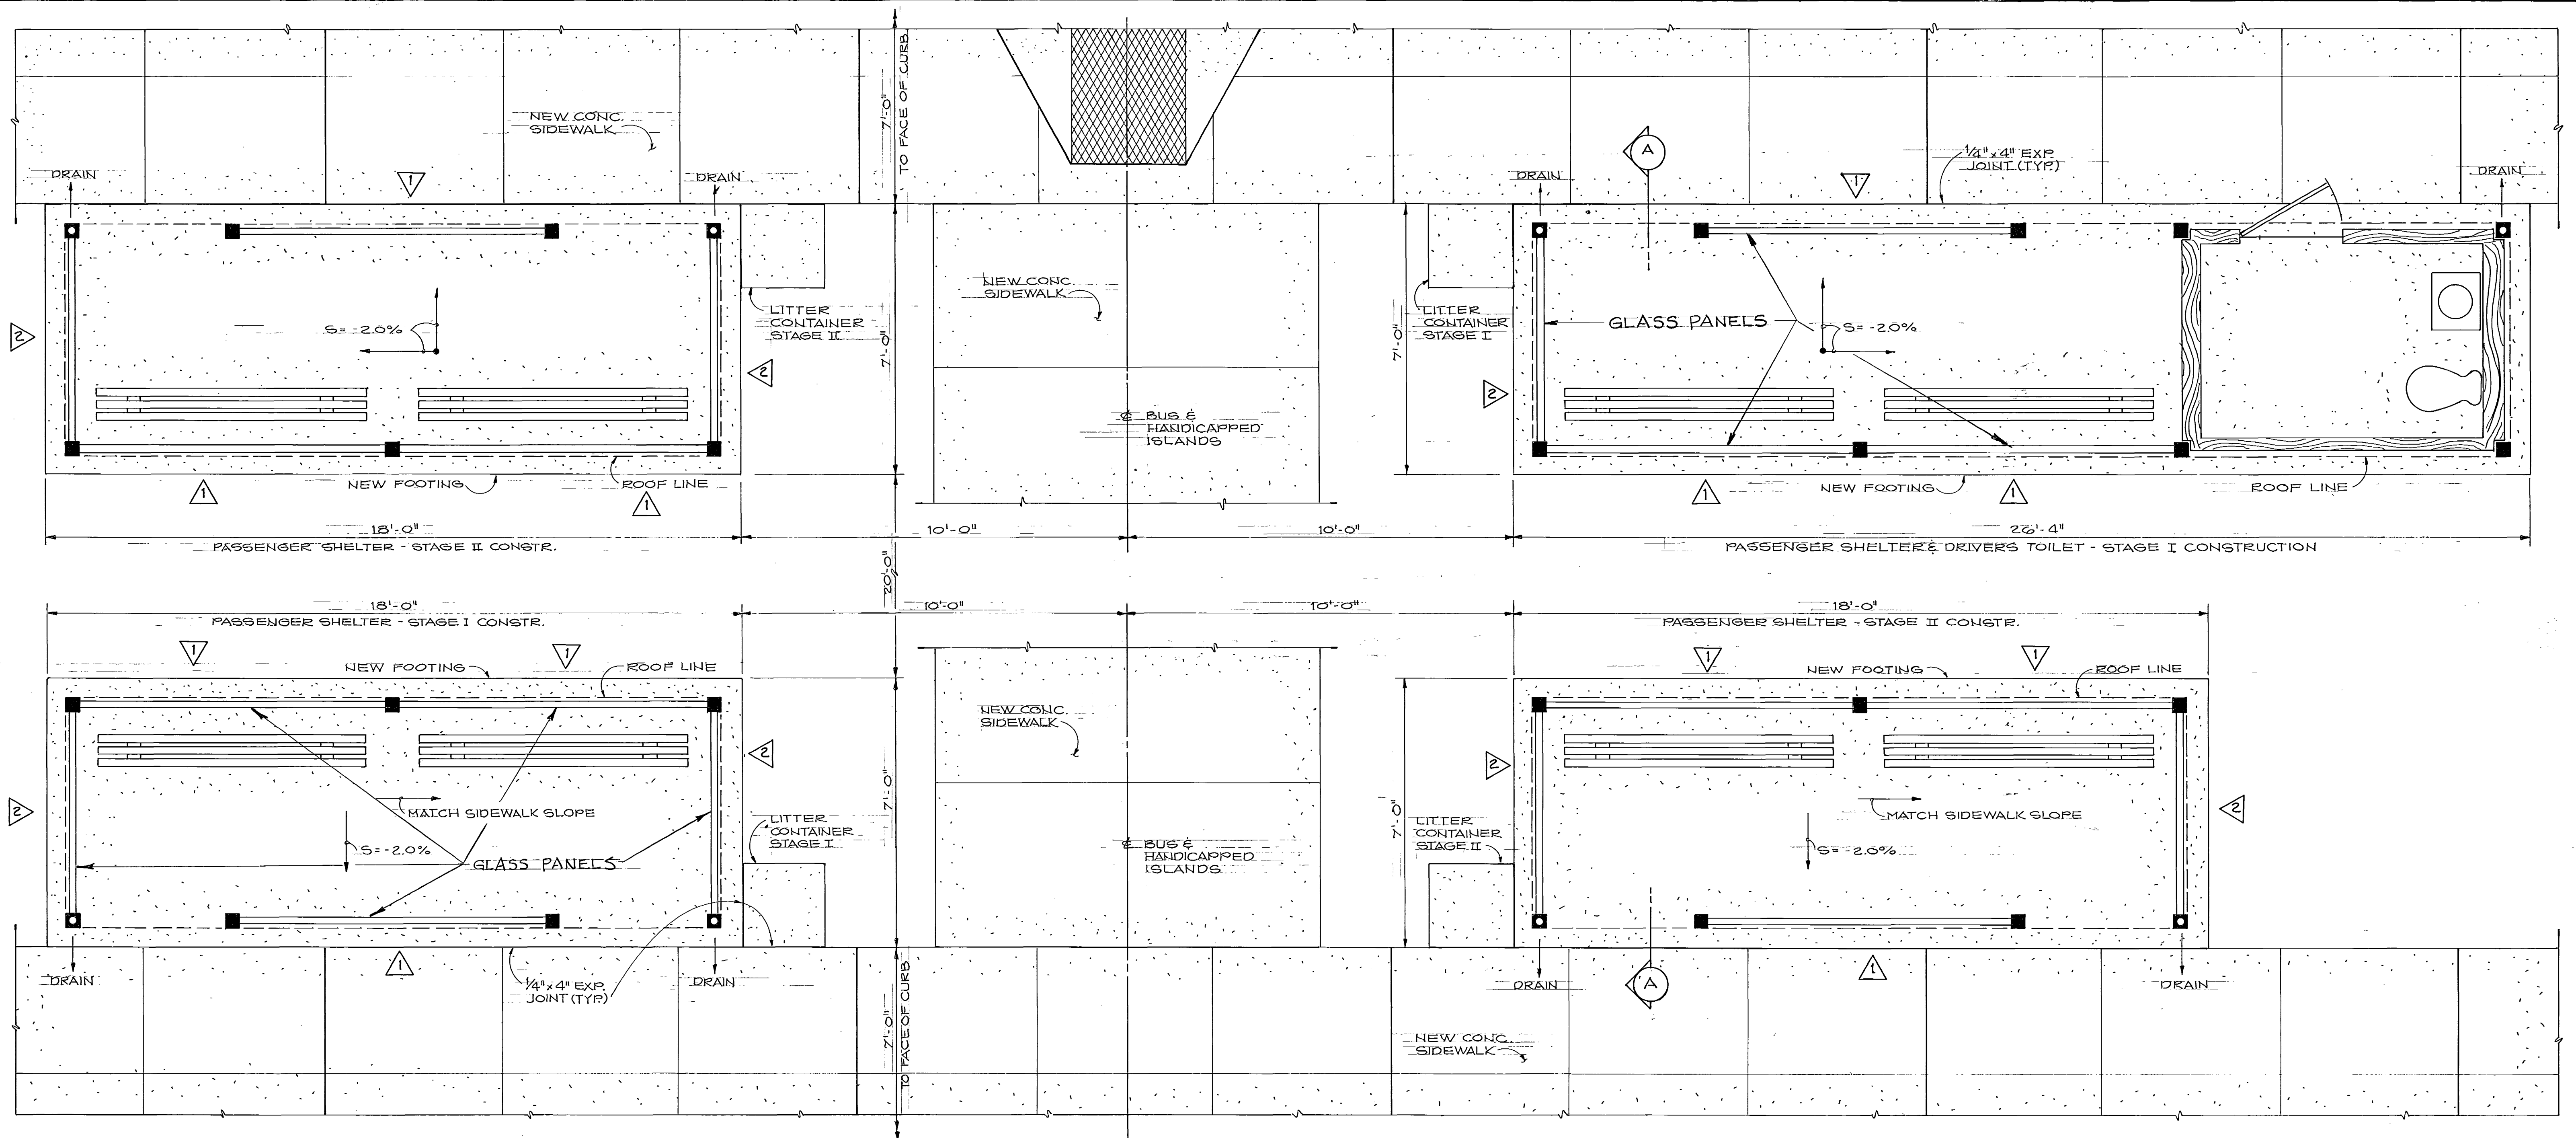

PLAN
SCALE 1/2"=1'-0"

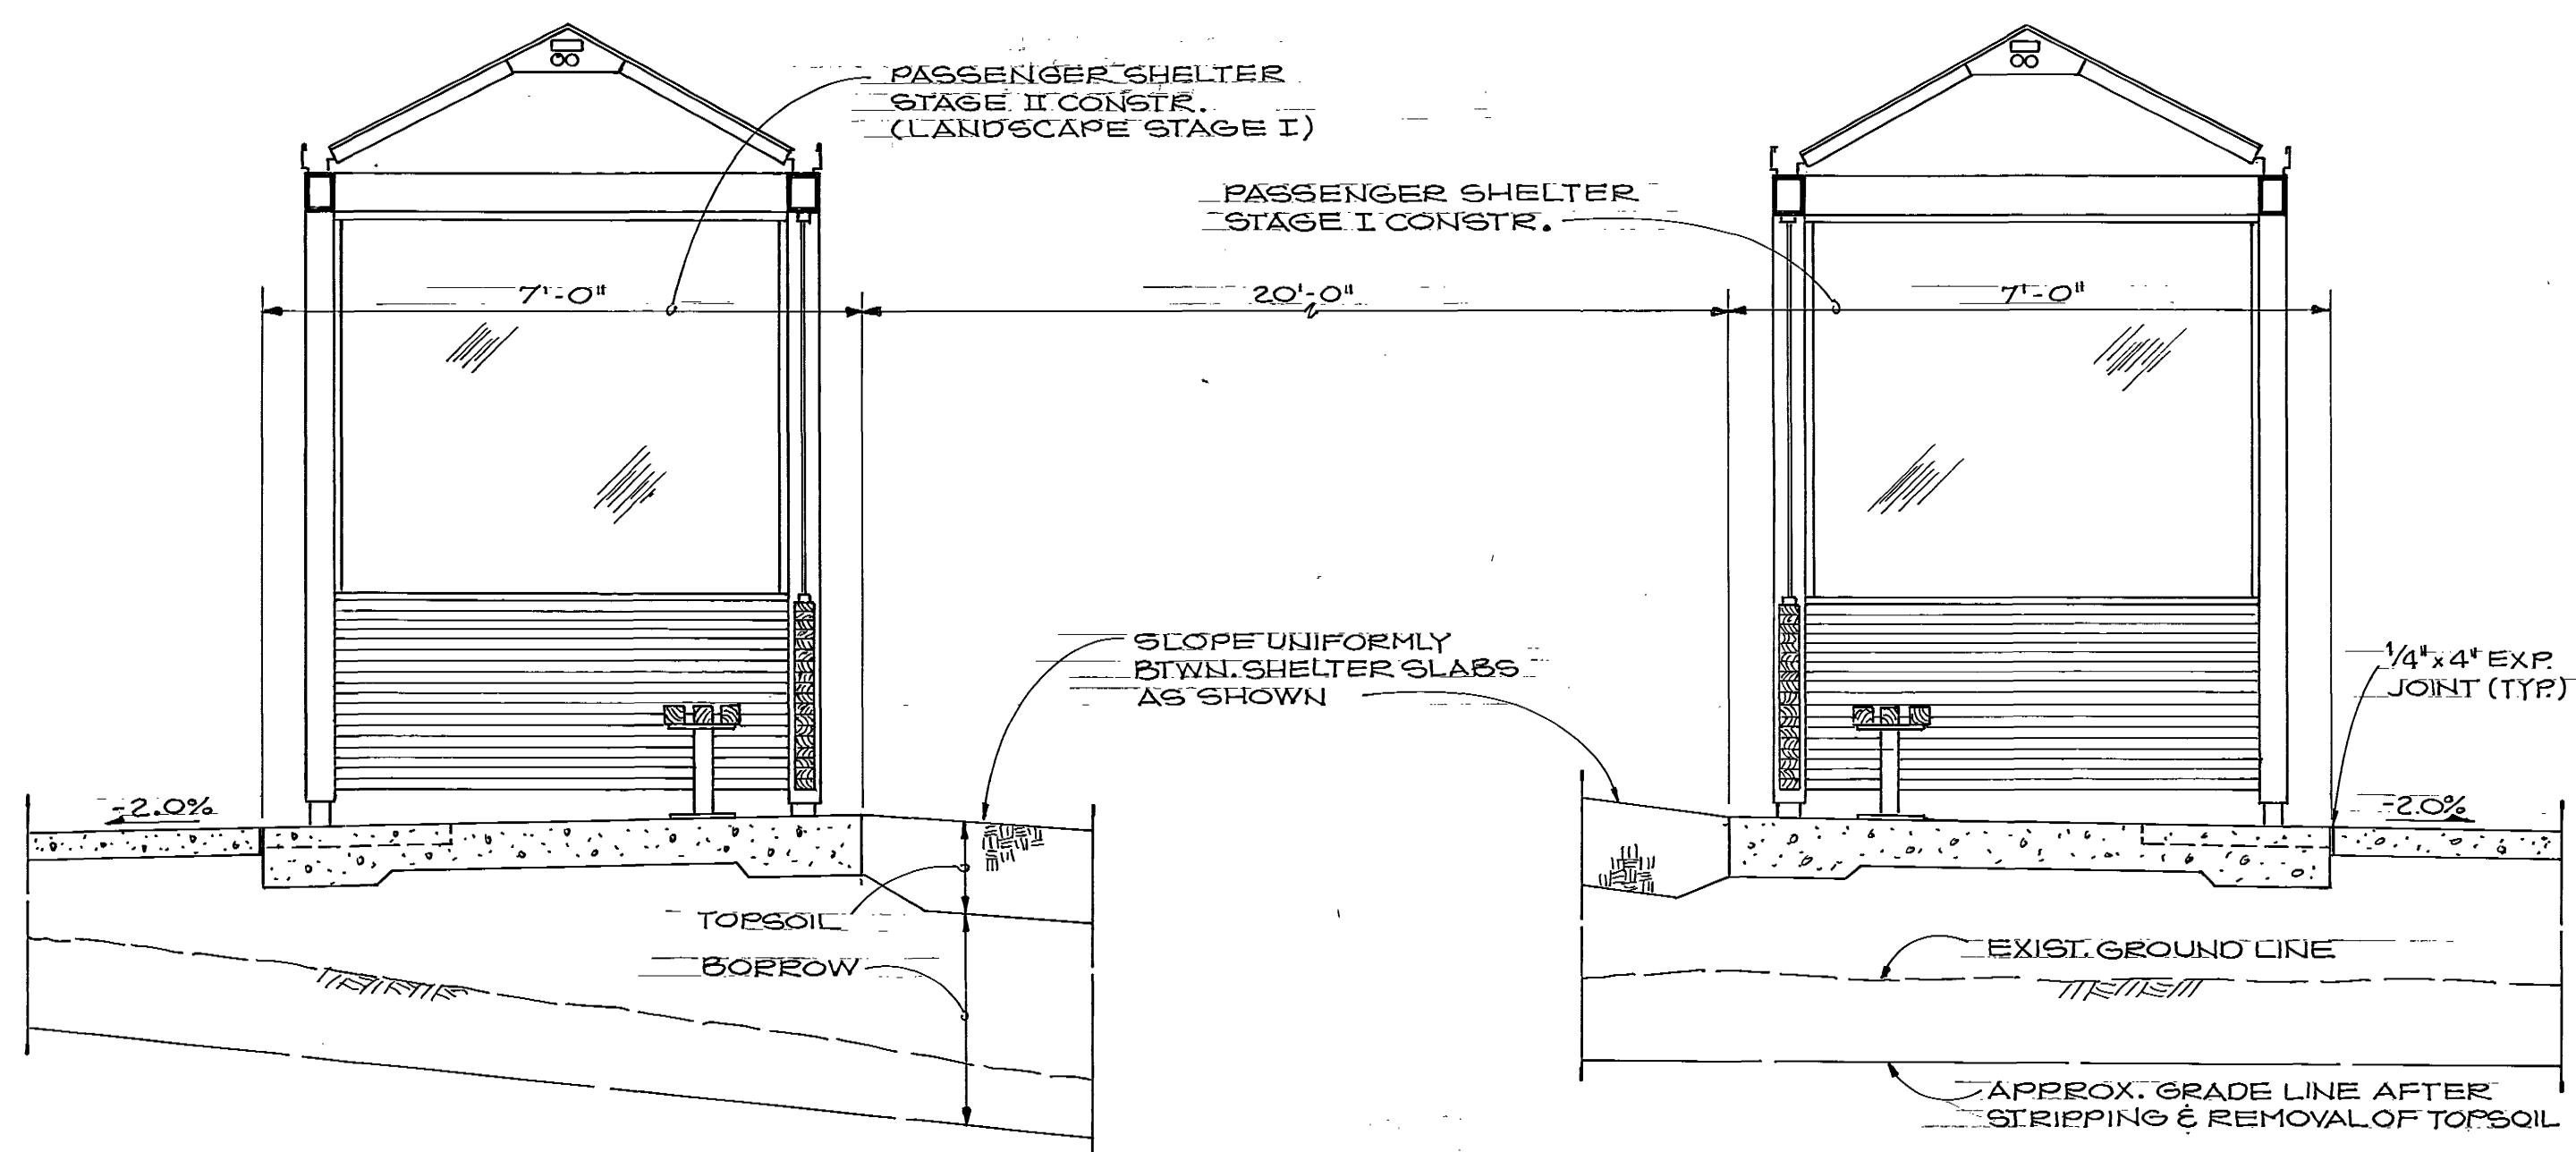

SECTION A
SCALE 1/2"=1'-0"

NOTES:

1. ARCHITECTURAL DRAWINGS THAT FOLLOW ARE METRO'S STANDARD DETAILS FOR SYSTEM-WIDE PASSENGER SHELTERS AND DRIVERS TOILETS AT PARK-AND-RIDE FACILITIES. ONLY THE DETAILS NECESSARY TO CONSTRUCT THE SHELTERS AND TOILET AS DEPICTED ON THIS SHEET ARE APPLICABLE.
2. WATER AND SANITARY SEWER CONNECTIONS ARE NOT SHOWN. SEE SHEETS C-4 AND C-6.
3. PROVIDE CEMENT CONCRETE PAD FOR LITTER CONTAINERS AT LOCATIONS SHOWN ON PLAN. PADS SHALL BE 2'-2" BY 2'-2" AND 4" IN THICKNESS.


SCHEDULE - PASSENGER SHELTERS AND DRIVERS TOILET

ITEM	STAGE I		STAGE II	
	TYPE	MATERIAL	TYPE	MATERIAL
FRAME	2 - F14 AND 1 - F12	STEEL	2 - F14	STEEL
ROOF	2 - R32 AND 1 - R31	METAL	2 - R32	METAL
PANEL	6 - P23 AND 6 - P33	GL. & WOOD	6 - P23 AND 6 - P33	GL. & WOOD
PANEL	3 - P22 AND 3 - P32	GL. & WOOD	4 - P22 AND 4 - P32	GL. & WOOD
FOOTING	1 @ 7'-0" x 26'-4" & 1 @ 7'-0" x 18'-0"	REINF. CONC.	2 @ 7'-0" x 18'-0"	REINF. CONC.
BENCH	4 - S12	WOOD	4 - S12	WOOD
LIGHT	2 @ 8' & 1 @ 3'	FLOUR.	2 @ 8'	FLOUR.
LITTER	2	METAL	2	METAL

"AS CONSTRUCTED"
FEB. 10, 1978


111205

MUNICIPALITY OF METROPOLITAN SEATTLE — TRANSIT DIVISION
AUBURN PARK-AND-RIDE FACILITY
PASSENGER SHELTER SITE PLAN

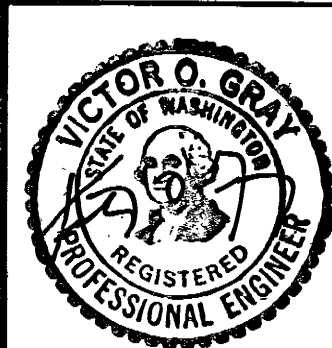

VICTOR O. GRAY & COMPANY, INC.
CONSULTING ENGINEERS & PLANNERS
RICHARD HAAG & ASSOCIATES
LANDSCAPE ARCHITECTS
JD 21 — LIGHTING ENGINEERS

Date 9/76
File No. 7605
Sheet 16 of 27
A-1
Sheet Number

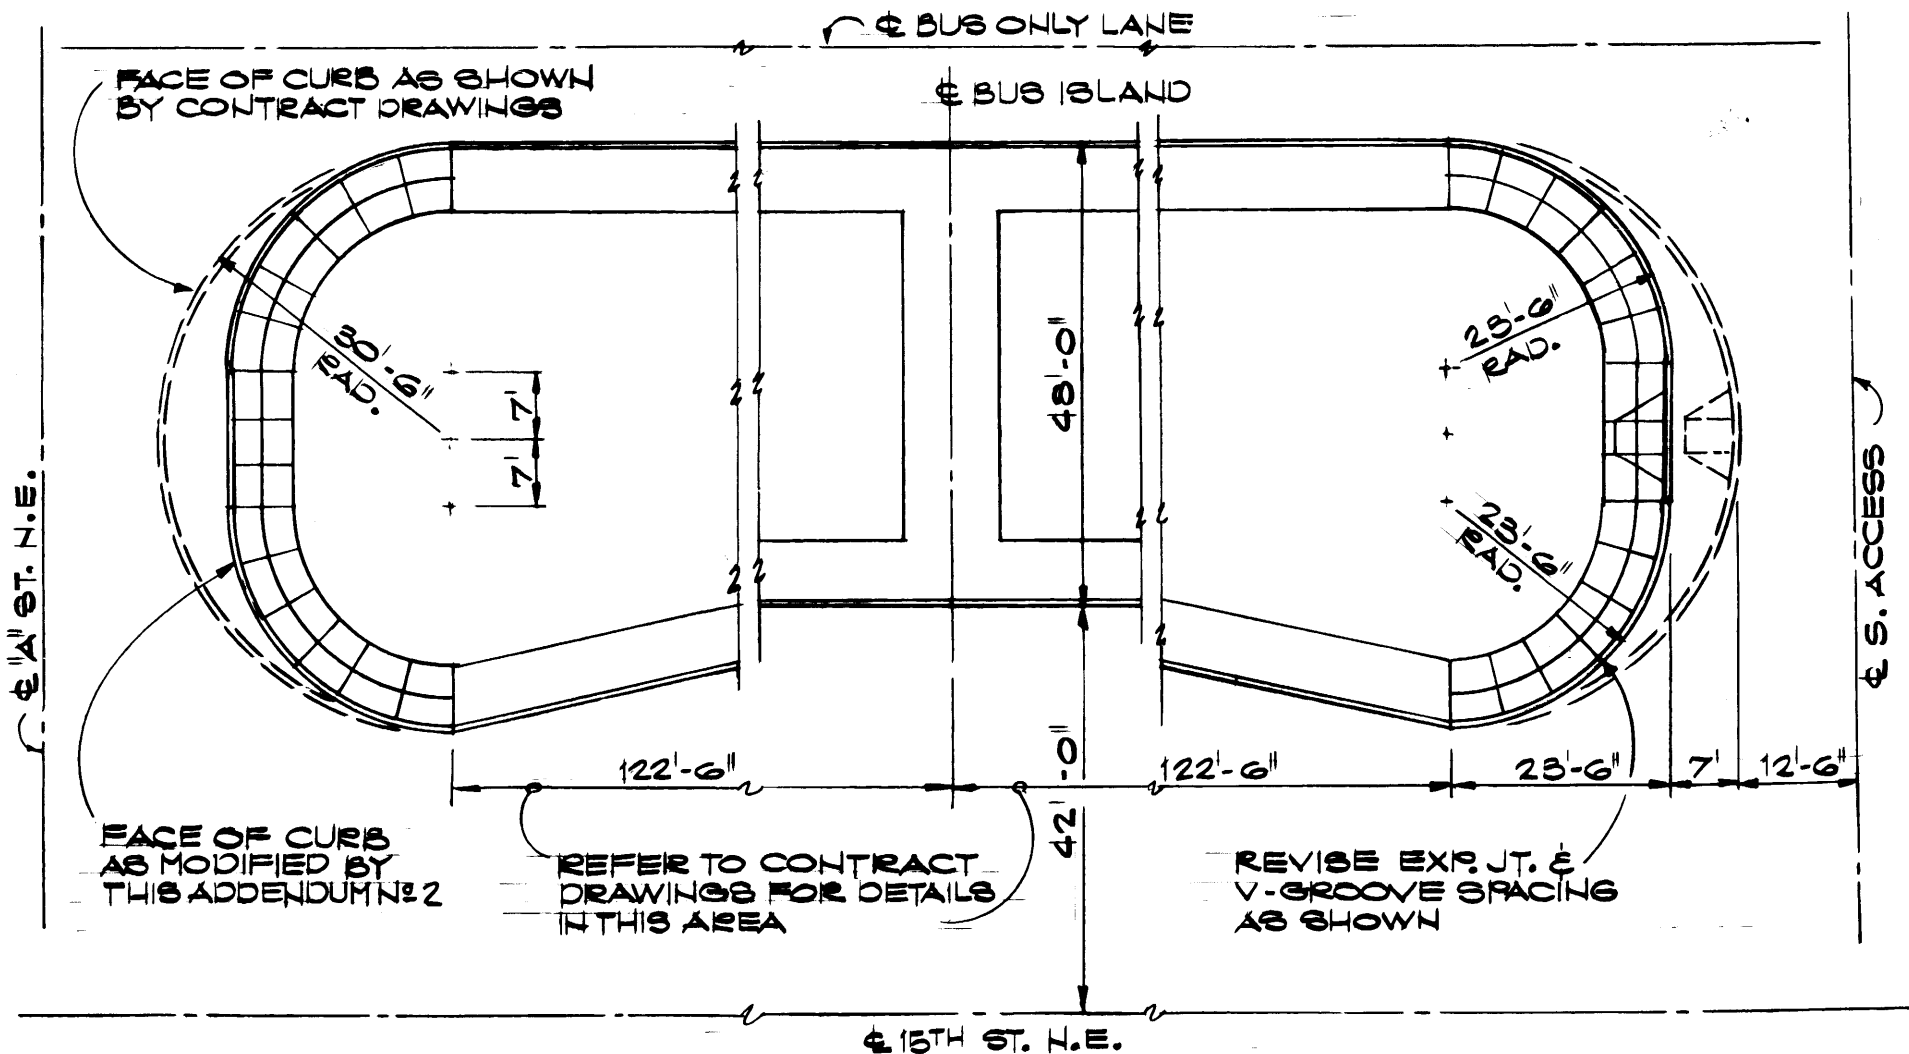

REVISED PLAN OF BUS ISLAND

MUNICIPALITY OF METROPOLITAN SEATTLE
KING COUNTY, WASHINGTON
CONTRACT NO. TGA-76
AUBURN PARK-AND-RIDE FACILITY

ADDENDUM NO. 2
REF. NO. 1
MARCH 1, 1977
BY: R.F.H.

CP1

111206

"AS CONSTRUCTED"
FEB 10, 1978